

COMPONENTS OF CONTRACT PLANS SET

- ROADWAY PLANS
- SIGNING AND PAVEMENT MARKING PLANS
- SIGNALIZATION PLANS
- INTELLIGENT TRANSPORTATION SYSTEMS PLANS
- LIGHTING PLANS
- LANDSCAPE PLANS
- ARCHITECTURAL PLANS
- STRUCTURE PLANS

A DETAILED INDEX APPEARS ON THE KEY SHEET OF EACH COMPONENT

INDEX OF ROADWAY PLANS

SHEET NO.	SHEET DESCRIPTION
1	KEY SHEET
2-2A	SUMMARY OF PAY ITEMS
3	DRAINAGE MAP
4-5	TYPICAL SECTIONS
6	TYPICAL SECTION DETAILS
7	SUMMARY OF QUANTITIES
8-9	SUMMARY OF DRAINAGE STRUCTURES
10	PROJECT LAYOUT
11-15	ROADWAY PLAN-PROFILES
16-17	SPECIAL PROFILES
18	INTERSECTION LAYOUT/DETAIL
19-25	DRAINAGE STRUCTURES
26-32	BOX CULVERT DETAILS
33	LATERAL DITCH PLAN-PROFILES
34	LATERAL DITCH CROSS SECTIONS
35	SPECIAL DETAILS
36	ROADWAY SOIL SURVEY
37-47	CROSS SECTIONS
48	STORMWATER POLLUTION PREVENTION PLAN
49-52	TRAFFIC CONTROL PLANS
53-57	UTILITY ADJUSTMENTS
58-62	SELECTIVE CLEARING AND GRUBBING

GOVERNING STANDARDS AND SPECIFICATIONS:
FLORIDA DEPARTMENT OF TRANSPORTATION,
DESIGN STANDARDS DATED 2008,
AND STANDARD SPECIFICATIONS FOR ROAD AND
BRIDGE CONSTRUCTION DATED 2010,
AS AMENDED BY CONTRACT DOCUMENTS.

APPLICABLE DESIGN STANDARDS MODIFICATIONS: I-1-10

For Design Standards Modifications click on
"Design Standards" at the following web sites:
<http://www.dot.state.fl.us/rddesign/>

REVISIONS

FINANCIAL PROJECT ID 000001-1-52-01

- △ Roadway Sheets 1, 6, 7 & 13 (Revised 01-10-09)
- △ Signing & Pavement Marking Sheets S-2 & S-3 (Revised 3-10-09)
- △ Signalization Sheets T-1 & T-2 (Revised 3-10-09)
- △ Roadway Sheets 14 & 33 (Revised 3-31-09)
- Summary Of Pay Items (Revised 3-31-09)

FINANCIAL PROJECT ID 000002-1-52-02


- △ Roadway Sheets 1, 8 & 10 (Revised 1-30-09)
- Structure Sheets B-1 & C-1 thru C-10 (Revised 1-30-09)

**STATE OF FLORIDA
DEPARTMENT OF TRANSPORTATION**



CONTRACT PLANS

FINANCIAL PROJECT ID 000001-1-52-01
(FEDERAL FUNDS)
BAY COUNTY (46001)
STATE ROAD NO. 220

EXAMPLE ONLY: CONTRACT PLANS SET
MAY NOT CONTAIN ALL OF THE
LISTED COMPONENTS/SHEETS.

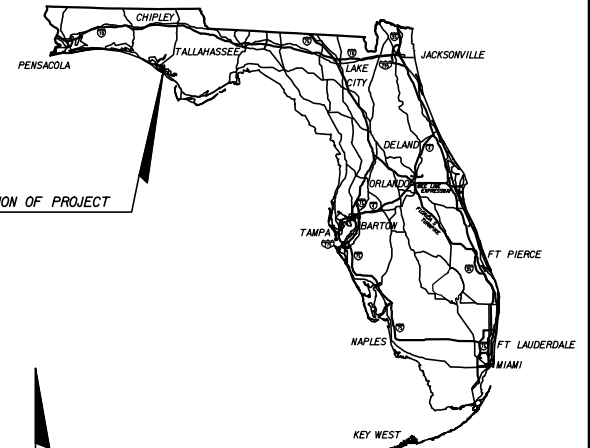

CONSTRUCTION CONTRACT NO. T0000

 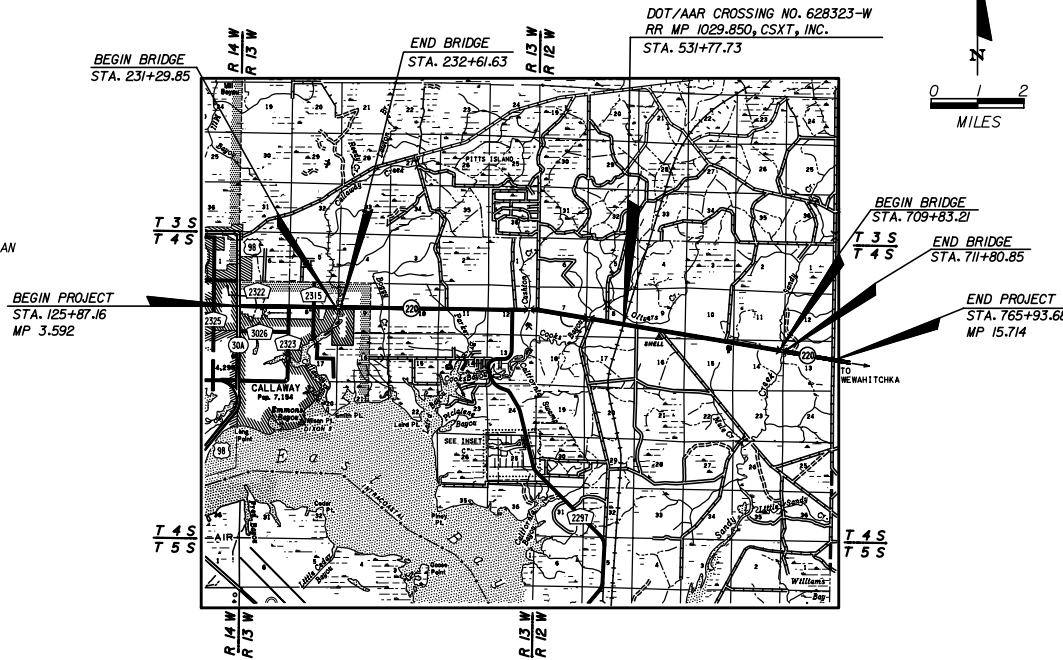

ROADWAY SHOP DRAWINGS
TO BE SUBMITTED TO:

NAME(S) AND ADDRESS(ES) OF
ENGINEER(S) RESPONSIBLE FOR REVIEW
OF SHOP DRAWINGS, WHEN REQUIRED.

PLANS PREPARED BY:

NAME, ADDRESS, CONSULTANT CONTRACT NUMBER,
VENDOR NUMBER, AND CERTIFICATE OF
AUTHORIZATION NUMBER OF THE CONSULTANT FIRM
WHEN THE PLANS ARE PREPARED BY A CONSULTANT.

NOTE: THIS PROJECT TO BE LET TO CONTRACT
WITH FINANCIAL PROJECT ID 000002-1-52-02.

NOTE: THE SCALE OF THESE PLANS MAY
HAVE CHANGED DUE TO REPRODUCTION.

EXHIBIT KS-1
Date: 1/1/10

LENGTH OF PROJECT		
	LINEAR FEET	MILES
ROADWAY	63,677.10	12.060
BRIDGES	329.42	0.062
NET LENGTH OF PROJ.	64,006.52	12.122
EXCEPTIONS		
GROSS LENGTH OF PROJ.	64,006.52	12.122

KEY SHEET REVISIONS	
DATE	DESCRIPTION
1-10-09	Revised sequence of contract plans.

ROADWAY PLANS
ENGINEER OF RECORD: _____



P.E. NO. : _____

FISCAL YEAR	SHEET NO.

FDOT PROJECT MANAGER :

#USER# #DATE# #TIME# #FILE#

ELECTRONIC SIGNATURE NOTE WHEN SHEET IS ELECTRONICALLY SIGNED AND SEALED

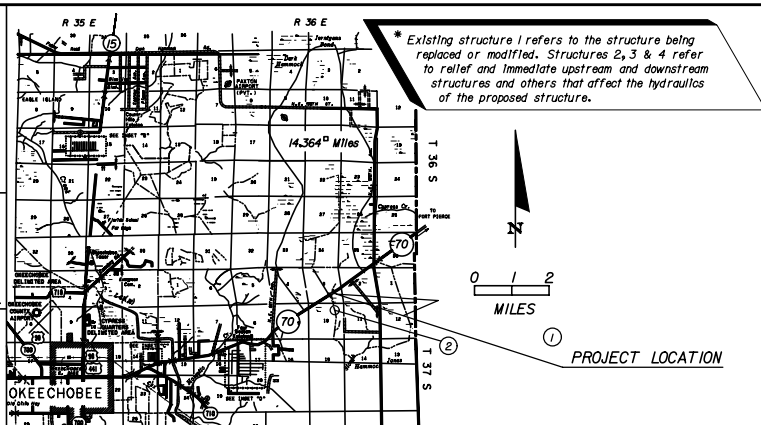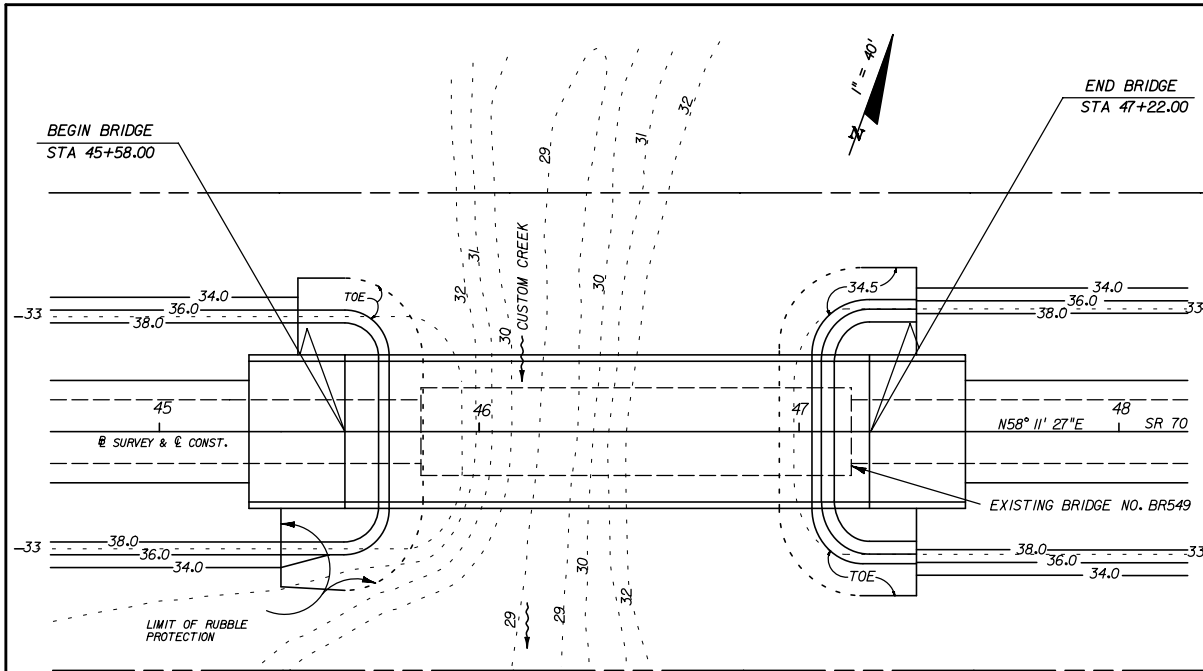

(REFERENCE)	* EXISTING STRUCTURES				PROPOSED STRUCTURE
	(1)	(2)	(3)	(4)	
FOUNDATION	Conc. Piles	Timber			Conc. Piles
OVERALL LENGTH	135	200			164 (rem. #1)
SPAN LENGTH	5 @ 27	20 @ 10			4 @ 41
TYPE CONSTRUCTION	Concrete	Timber			Concrete
AREA OF OPENING @ D.F.	1000	Unknown			1020
BRIDGE WIDTH	28'	Railroad (South)			44'
ELEV. LOW MEMBER	40.35	38.32			41.17

HYDRAULIC DESIGN DATA

NOTE: The hydraulic data is shown for informational purposes only to indicate the flood discharges and water surface elevations which may be anticipated in any given year. This data was generated using highly variable factors determined by a study of the watershed. Many judgements and assumptions are required to establish these factors. The resultant hydraulic data is sensitive to changes, particularly antecedent conditions, urbanization, channelization and land use. Users of this data are cautioned against the assumption of precision which cannot be obtained.

TERMS:
Design Flood: Utilized to assure a desired level of hydraulic performance.
Base Flood: Has a 1% chance of being exceeded in any given year (100 year frequency)
Overtopping Flood: Causes flow over the highway, over a watershed divide, or thru emergency relief structures.
Greatest Flood: The most severe that can be predicted where overtopping is not practicable.

WATER SURFACE ELEVATIONS:	N.H.W. (Non-Tidal)		M.H.W. (Tidal)		OVERTOPPING or GREATEST FLOOD
	CONTROL (Non-Tidal)	M.L.W. (Tidal)	CONTROL (Non-Tidal)	M.L.W. (Tidal)	
FLOOD DATA:	MAX. EVENT OF RECORD	DESIGN FLOOD	BASE FLOOD		
STAGE ELEV. NAVD (ft)	38.7 (rem. #2)	38.91	39.27		39.57
DISCHARGE (cfs)	unknown	3280	3950		4630
AVERAGE VELOCITY (ft/s)		3.22	3.58		4.13
EXCEEDANCE PROB. (%)		2	1		0.2
FREQUENCY (yr.)		50	100		500


SCOUR PREDICTIONS FOR PROPOSED STRUCTURE DESCRIBED ABOVE:

NUMBERS	PIER INFORMATION	LONG TERM SCOUR ELEV.	TOTAL SCOUR ELEVATION	
			WORST CASE < 100 yr. FREQ. (yr.)	WORST CASE < 500 yr. FREQ. (yr.)
2 & 3	** SIZE AND TYPE	N/A	18.4	16.4
4 (rem. #3)	24" Conc. Piles	N/A	27.6	25.6

HYDRAULIC RECOMMENDATIONS

- BEGIN BRIDGE STATION 45+58.00 END BRIDGE STATION 47+22.00 SKEW ANGLE 0°
- CLEARANCE PROVIDED: NAV. HORIZ. 39.0 VERT. 8.04 ABOVE EL. 33.14 DRIFT: HORIZ. 39.0 VERT. 2.26 ABOVE EL. 38.91
- MINIMUM CLEARANCE: NAV. HORIZ. 10.0 VERT. 6.0 ABOVE EL. 33.14 DRIFT: HORIZ. N/A VERT. 2.0 ABOVE EL. 38.91
- ABUTMENTS: BEGIN BRIDGE END BRIDGE

REMARKS: (1) Bridge lengthened to accommodate predicted channel migration to the west.
 (2) Based on mark provided by local resident of 43 years.
 (3) Due to predicted channel migration to the west and lack of meander cutoff, Pier No. 4 will not experience main channel scour depths.

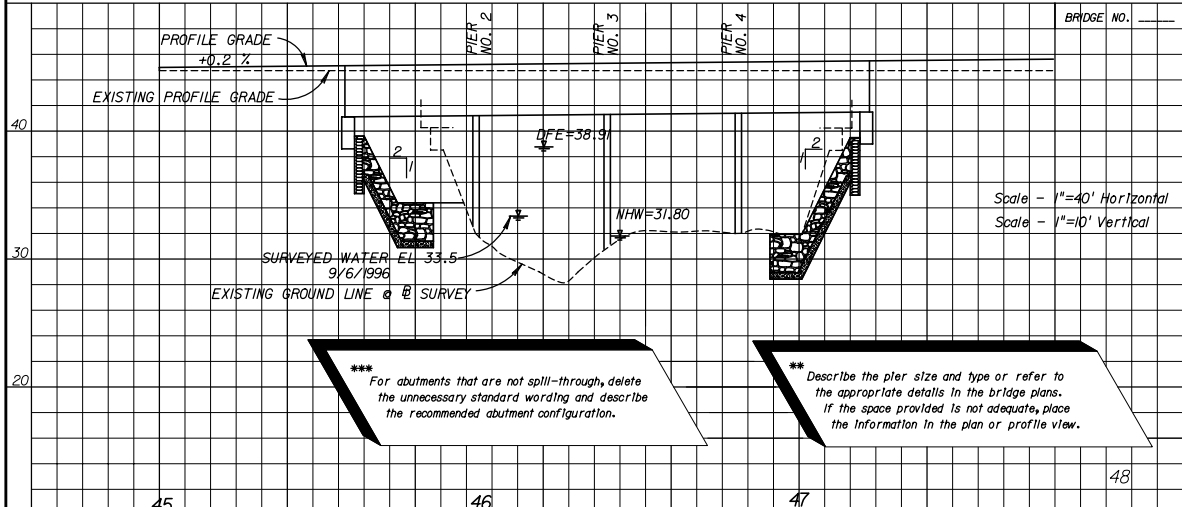

*** For abutments that are not spill-through, delete the unnecessary standard wording and describe the recommended abutment configuration.


** Describe the pier size and type or refer to the appropriate details in the bridge plans. If the space provided is not adequate, place the information in the plan or profile view.

REVISIONS	
DATE	DESCRIPTION

STATE OF FLORIDA DEPARTMENT OF TRANSPORTATION			BRIDGE HYDRAULIC RECOMMENDATIONS	SHEET NO.
ROAD NO.	COUNTY	FINANCIAL PROJECT ID		
70	LEON	123456-1-52-01		

NOTICE: THE OFFICIAL RECORD OF THIS SHEET IS THE ELECTRONIC FILE SIGNED AND SEALED UNDER RULE 68G05-23.003, F.A.C.

EXHIBIT BHD-1
Date: 1/1/10

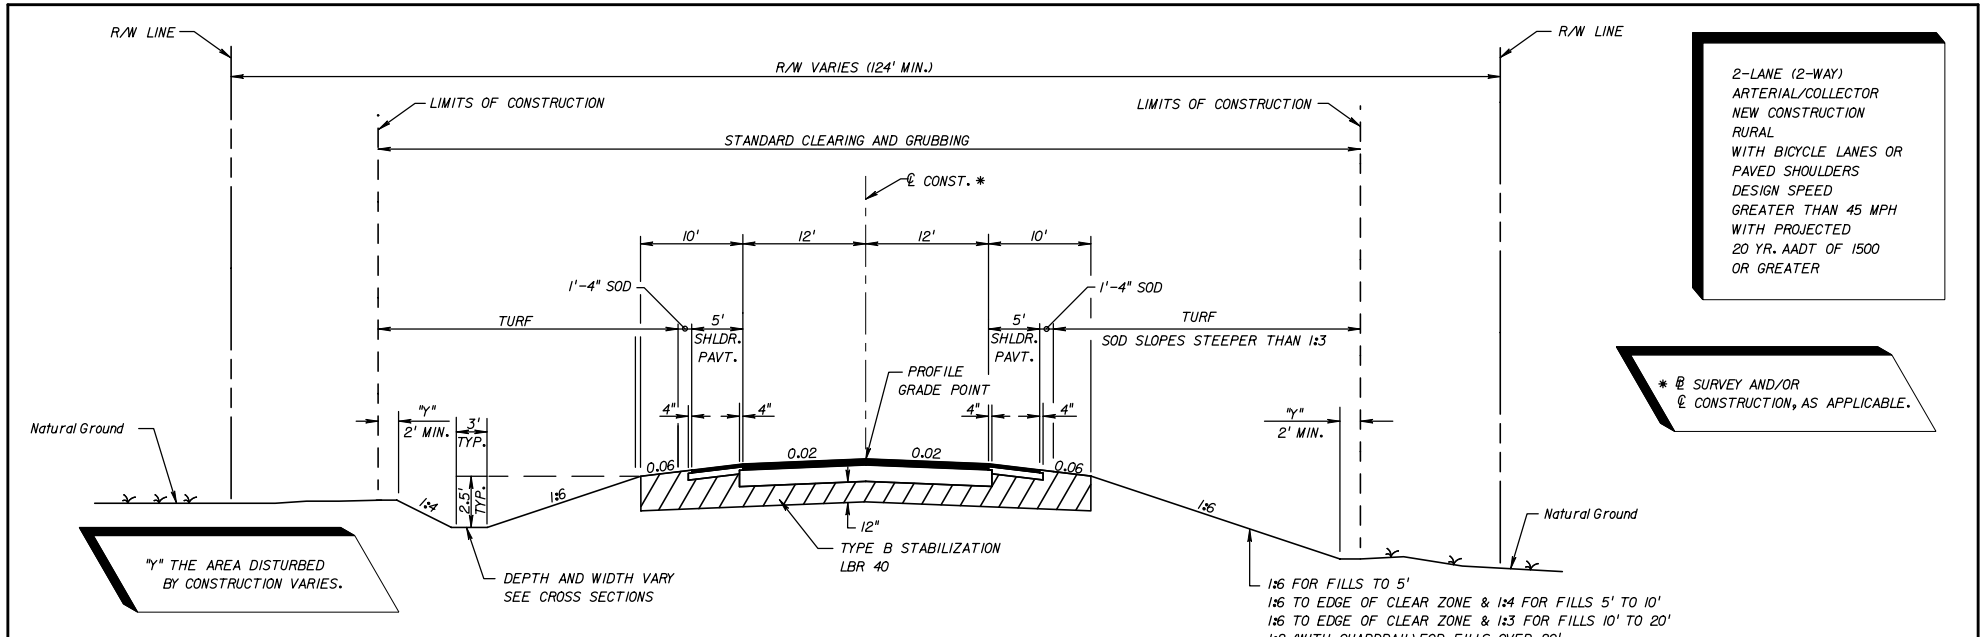

2-LANE (2-WAY)
 ARTERIAL/COLLECTOR
 NEW CONSTRUCTION
 RURAL
 WITH BICYCLE LANES OR
 PAVED SHOULDERS
 DESIGN SPEED
 GREATER THAN 45 MPH
 WITH PROJECTED
 20 YR. AADT OF 1500
 OR GREATER

* @ SURVEY AND/OR
 @ CONSTRUCTION, AS APPLICABLE.

NOTE:
 HEIGHT OF FILL IS THE VERTICAL DISTANCE
 FROM THE EDGE OF THE OUTSIDE TRAVEL LANE
 TO TOE OF FRONT SLOPE.

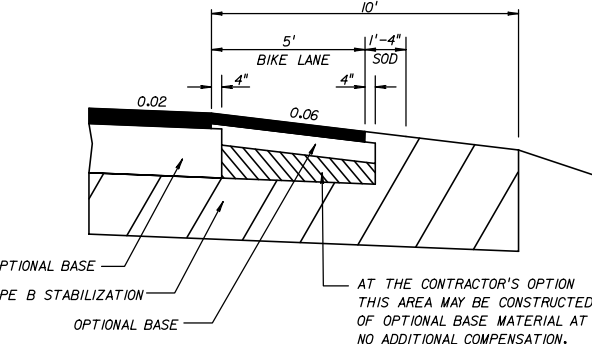


EXHIBIT TYP-1
 Date: 1/1/10

TRAFFIC DATA

CURRENT YEAR = 1998 AADT = 6800
 ESTIMATED OPENING YEAR = 2000 AADT = 7600
 ESTIMATED DESIGN YEAR = 2020 AADT = 12000
 K = 6% D = 55% T = 2% (24 HOUR)
 DESIGN HOUR T = 1%
 DESIGN SPEED = 55 MPH

TRAFFIC DATA IS REQUIRED TO BE NOTED FOR
 CURRENT YEAR, OPENING YEAR AND DESIGN YEAR.
 POSTED SPEED (MPH) IS OPTIONAL.

FOR STANDARD TYPICAL SECTION NOTES
 REFER TO EXHIBIT 6-1, THIS CHAPTER.

**TYPICAL SECTION
 SR 10 (U.S. 90-A)
 STA. 10+00.00 TO STA. 267+34.89**

NEW CONSTRUCTION

OPTIONAL BASE GROUP 8 WITH
 TYPE SP STRUCTURAL COURSE (TRAFFIC C) (2")
 AND FRICTION COURSE FC-12.5 (TRAFFIC C) (1/2") (RUBBER)


SHOULDER PAVEMENT

OPTIONAL BASE GROUP 1 WITH
 FRICTION COURSE FC-12.5 (TRAFFIC C) (1/2") (RUBBER)

SHOULDER PAVEMENT DETAIL

REVISIONS				STATE OF FLORIDA DEPARTMENT OF TRANSPORTATION			TYPICAL SECTION	SHEET NO.
DATE	DESCRIPTION	DATE	DESCRIPTION	ROAD NO.	COUNTY	FINANCIAL PROJECT ID		
					LEON	123456-1-52-01		

NOTICE: THE OFFICIAL RECORD OF THIS SHEET IS THE ELECTRONIC FILE SIGNED AND SEALED UNDER RULE 6805-23.003, F.A.C.

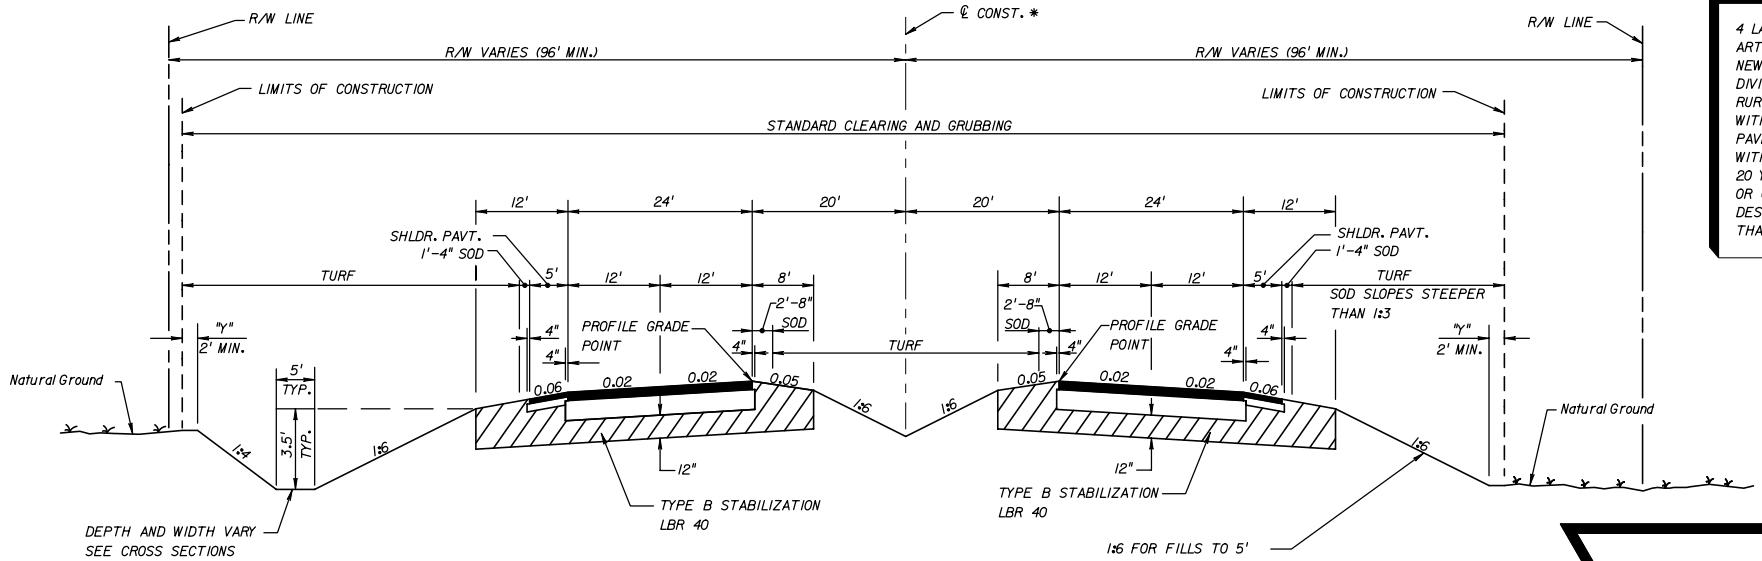

4 LANE
ARTERIAL/COLLECTOR
NEW CONSTRUCTION
DIVIDED
RURAL
WITH BICYCLE LANES OR
PAVED SHOULDERS
WITH PROJECTED
20 YR. AADT OF 1500
OR GREATER
DESIGN SPEED GREATER
THAN 50 MPH

TRAFFIC DATA

CURRENT YEAR = 1998 AADT = 22300
 ESTIMATED OPENING YEAR = 2000 AADT = 23300
 ESTIMATED DESIGN YEAR = 2020 AADT = 51500
 K = 9% D = 56% T = 10% (24 HOUR)
 DESIGN HOUR T = 5%
 DESIGN SPEED = 70 MPH

**TYPICAL SECTION
SR 500
STA. 63+65.42 TO STA. 328+65.14**

NEW CONSTRUCTION

OPTIONAL BASE GROUP 9 WITH
 TYPE SP STRUCTURAL COURSE (TRAFFIC D) (2")
 TYPE SP STRUCTURAL COURSE (TRAFFIC D) (1 1/2") (PG 76-22)
 AND FRICTION COURSE FC-5 (3/4") (PG 76-22)

SHOULDER PAVEMENT

OPTIONAL BASE GROUP 1 WITH
 TYPE SP STRUCTURAL COURSE (TRAFFIC D) (1 1/2") (PG 76-22)
 AND FRICTION COURSE FC-5 (3/4") (PG 76-22)

1:6 FOR FILLS TO 5'
 1:6 TO EDGE OF CLEAR ZONE & 1:4 FOR FILLS 5' TO 10'
 1:6 TO EDGE OF CLEAR ZONE & 1:3 FOR FILLS 10' TO 20'
 1:2 (WITH GUARDRAIL) FILLS OVER 20'


NOTE:
 HEIGHT OF FILL IS THE VERTICAL DISTANCE
 FROM THE EDGE OF THE OUTSIDE TRAVEL LANE
 TO TOE OF FRONT SLOPE.

* @ SURVEY AND/OR
 @ CONSTRUCTION, AS APPLICABLE.

"y" THE AREA DISTURBED BY
 CONSTRUCTION VARIES.

TRAFFIC DATA IS REQUIRED TO BE
 NOTED FOR CURRENT YEAR,
 OPENING YEAR, AND DESIGN YEAR.
 POSTED SPEED (MPH) IS OPTIONAL.

FOR STANDARD TYPICAL SECTION NOTES
 REFER TO EXHIBIT 6-1, THIS CHAPTER.

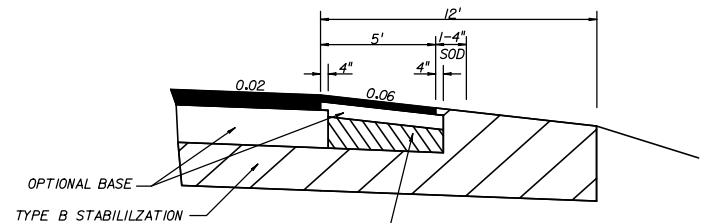

AT THE CONTRACTOR'S OPTION
 THIS AREA MAY BE CONSTRUCTED
 OF OPTIONAL BASE MATERIAL
 AT NO ADDITIONAL COMPENSATION

SHOULDER PAVEMENT DETAIL

EXHIBIT TYP-2
 Date: 1/1/10

REVISIONS				STATE OF FLORIDA DEPARTMENT OF TRANSPORTATION			TYPICAL SECTION	SHEET NO.
DATE	DESCRIPTION	DATE	DESCRIPTION	ROAD NO.	COUNTY	FINANCIAL PROJECT ID		
				10	LEON	123456-1-52-01		


#USER# #DATE# #TIME# #FILE#

NOTICE: THE OFFICIAL RECORD OF THIS SHEET IS THE ELECTRONIC FILE SIGNED AND SEALED UNDER RULE 6805-23.003, F.A.C.

5-LANE SECTIONS ARE TO INCLUDE SECTIONS OF RAISED OR RESTRICTIVE MEDIAN. SEE PPM TABLE 2.2.1.

*** @ SURVEY AND/OR @ CONSTRUCTION, AS APPLICABLE.

5-LANE ARTERIAL/COLLECTOR NEW CONSTRUCTION UNDIVIDED URBAN WITH BICYCLE LANES MINIMUM RIGHT OF WAY DESIGN SPEED 40 MPH OR LESS WITH PROJECTED 20 YR. AADT OF 1500 OR GREATER

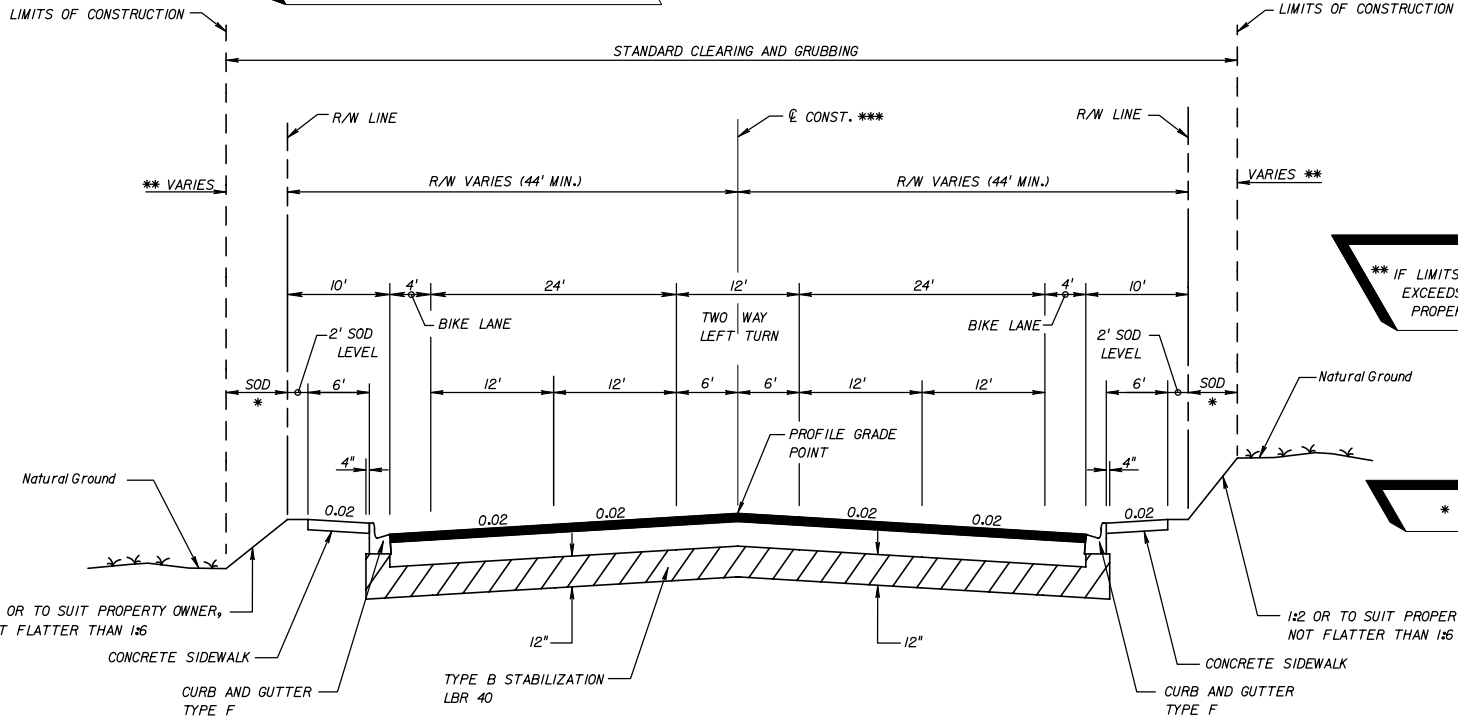

** IF LIMITS OF CONSTRUCTION EXCEEDS RIGHT OF WAY, A PROPERTY AGREEMENT IS REQUIRED.

* TURF OR SOD

TRAFFIC DATA

CURRENT YEAR = 1998 AADT = 9900
 ESTIMATED OPENING YEAR = 2000 AADT = 10600
 ESTIMATED DESIGN YEAR = 2020 AADT = 14000
 K = 6% D = 55% T = 2% (24 HOUR)
 DESIGN HOUR T = 1%
 DESIGN SPEED = 40 MPH

TRAFFIC DATA IS REQUIRED TO BE NOTED FOR CURRENT YEAR, OPENING YEAR AND DESIGN YEAR. POSTED SPEED (MPH) IS OPTIONAL.

**TYPICAL SECTION
 SR 00 (DUVAL STREET)
 STA. 252+12.00 TO STA. 323+19.42**

NEW CONSTRUCTION

OPTIONAL BASE GROUP B WITH
 TYPE SP STRUCTURAL COURSE (TRAFFIC B) (1 1/2")
 AND FRICTION COURSE FC-12.5 (TRAFFIC B) (1 1/2") (RUBBER)

FOR STANDARD TYPICAL SECTION NOTES REFER TO EXHIBIT 6-1, THIS CHAPTER.

EXHIBIT TYP-3
 Date: 1/1/10

REVISIONS				STATE OF FLORIDA DEPARTMENT OF TRANSPORTATION			TYPICAL SECTION	SHEET NO.
DATE	DESCRIPTION	DATE	DESCRIPTION	ROAD NO.	COUNTY	FINANCIAL PROJECT ID		
				10	LEON	123456-1-52-01		


#USER# #DATE# #TIME# #FILE#

NOTICE: THE OFFICIAL RECORD OF THIS SHEET IS THE ELECTRONIC FILE SIGNED AND SEALED UNDER RULE 68G5-23.003, F.A.C.

5-LANE SECTIONS ARE TO INCLUDE SECTIONS OF RAISED OR RESTRICTIVE MEDIAN. SEE PPM TABLE 2.2.J.

*** @ SURVEY AND/OR @ CONSTRUCTION, AS APPLICABLE.

5-LANE ARTERIAL/COLLECTOR NEW CONSTRUCTION UNDIVIDED URBAN WITH BICYCLE LANES DESIGN SPEED 40 MPH OR LESS WITH PROJECTED 20 YR. AADT OF 1500 OR GREATER

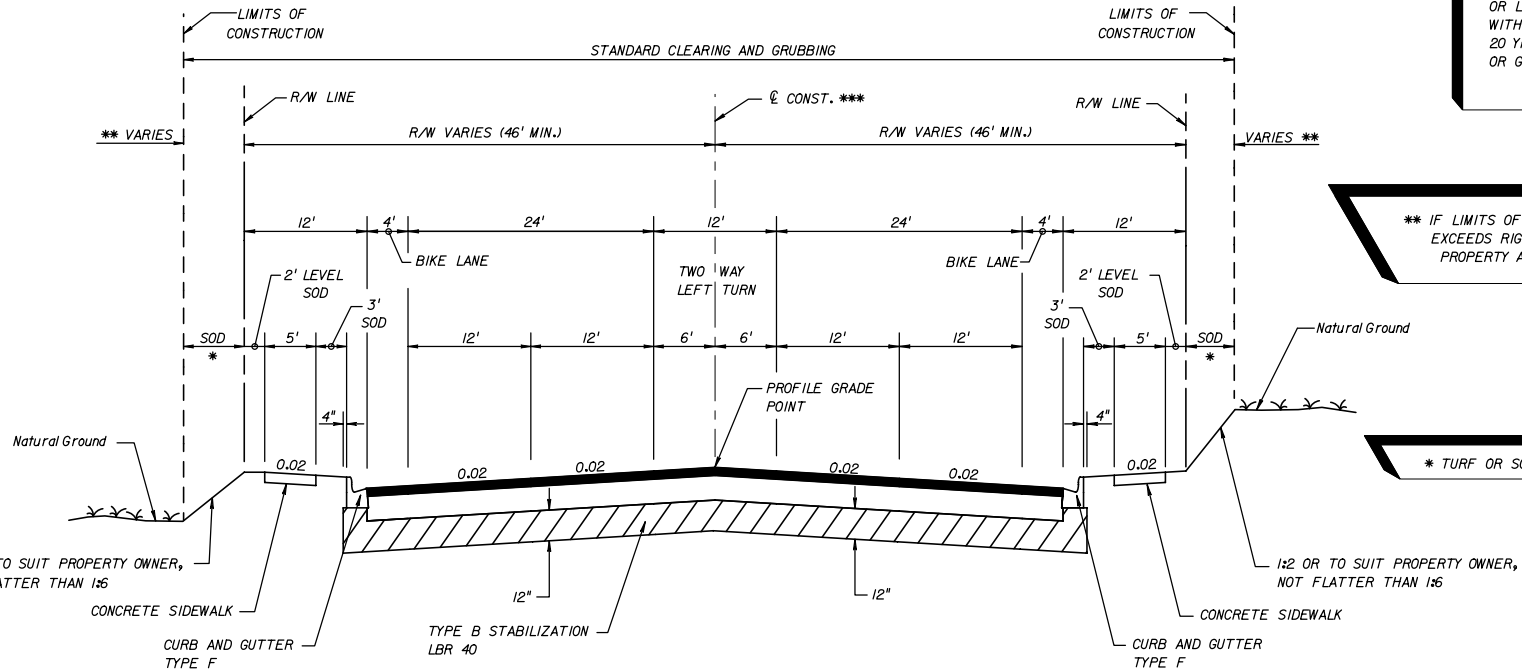

** IF LIMITS OF CONSTRUCTION EXCEEDS RIGHT OF WAY, A PROPERTY AGREEMENT IS REQUIRED.

* TURF OR SOD

TRAFFIC DATA

CURRENT YEAR = 1998 AADT = 20819
 ESTIMATED OPENING YEAR = 2003 AADT = 24100
 ESTIMATED DESIGN YEAR = 2023 AADT = 24900
 K = 9% D = 60% T = 2% (24 HOUR)
 DESIGN HOUR T = 1%
 DESIGN SPEED = 40 MPH

TRAFFIC DATA IS REQUIRED TO BE NOTED FOR CURRENT YEAR, OPENING YEAR AND DESIGN YEAR. POSTED SPEED (MPH) IS OPTIONAL.

**TYPICAL SECTION
 SR 00 (MATTHEWS STREET)
 STA. 202+42.00 TO STA. 263+29.68**

NEW CONSTRUCTION

OPTIONAL BASE GROUP 8 WITH
 TYPE SP STRUCTURAL COURSE (TRAFFIC B) (1/2")
 AND FRICTION COURSE FC-12.5 (TRAFFIC B) (1/2") (RUBBER)

FOR STANDARD TYPICAL SECTION NOTES REFER TO EXHIBIT 6-1, THIS CHAPTER.


EXHIBIT TYP-4
 Date: 1/1/10

REVISIONS		STATE OF FLORIDA DEPARTMENT OF TRANSPORTATION			SHEET NO.
DATE	DESCRIPTION	DATE	DESCRIPTION		
				ROAD NO. COUNTY FINANCIAL PROJECT ID 10 LEON 123456-1-52-01	
				#USER# #DATE# #TIME# #FILE#	

NOTICE: THE OFFICIAL RECORD OF THIS SHEET IS THE ELECTRONIC FILE SIGNED AND SEALED UNDER RULE 6805-23.003, F.A.C.

*** @ SURVEY AND/OR
@ CONSTRUCTION, AS APPLICABLE.

4-LANE
ARTERIAL
NEW CONSTRUCTION
DIVIDED
URBAN
WITH BIKE LANES
DESIGN SPEED 45 MPH OR LESS

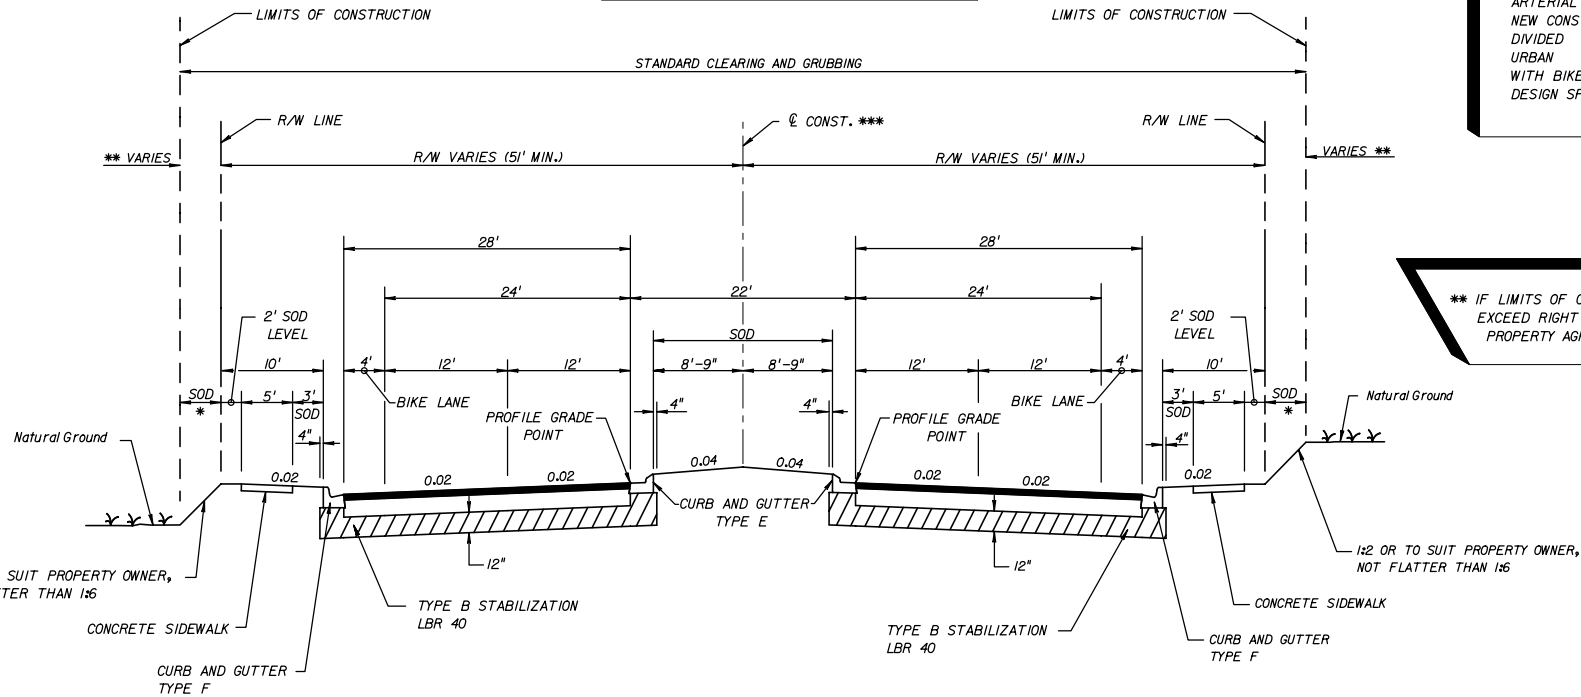

** IF LIMITS OF CONSTRUCTION
EXCEED RIGHT OF WAY, A
PROPERTY AGREEMENT IS REQUIRED.

1:2 OR TO SUIT PROPERTY OWNER,
NOT FLATTER THAN 1:6

1:2 OR TO SUIT PROPERTY OWNER,
NOT FLATTER THAN 1:6

TYPICAL SECTION
SR 00 (WILSON STREET)
STA. 98+40.00 TO STA. 202+33.00

NEW CONSTRUCTION

OPTIONAL BASE GROUP 9 WITH
TYPE SP STRUCTURAL COURSE (TRAFFIC B) (1 1/2")
AND FRICTION COURSE FC-12.5 (TRAFFIC B) (1 1/2") (RUBBER)

TRAFFIC DATA

CURRENT YEAR = 1998 AADT = 22800
ESTIMATED OPENING YEAR = 2000 AADT = 25800
ESTIMATED DESIGN YEAR = 2020 AADT = 30600
K = 6% D = 55% T = 2% (24 HOUR)
DESIGN HOUR T = 1%
DESIGN SPEED = 45 MPH

TRAFFIC DATA IS REQUIRED TO BE
NOTED FOR CURRENT YEAR, OPENING
YEAR AND DESIGN YEAR.
POSTED SPEED (MPH) IS OPTIONAL.

* TURF OR SOD

FOR STANDARD TYPICAL SECTION NOTES
REFER TO EXHIBIT 6-1, THIS CHAPTER.

EXHIBIT TYP-5
Date: 1/1/10

REVISIONS				STATE OF FLORIDA DEPARTMENT OF TRANSPORTATION			SHEET NO.
DATE	DESCRIPTION	DATE	DESCRIPTION	ROAD NO.	COUNTY	FINANCIAL PROJECT ID	
				10	LEON	123456-1-52-01	

#USER#

#DATE#

#TIME#

#FILE#


TYPICAL SECTION

NOTICE: THE OFFICIAL RECORD OF THIS SHEET IS THE ELECTRONIC FILE SIGNED AND SEALED UNDER RULE 6805-23.003, F.A.C.

*** @ SURVEY AND/OR
@ CONSTRUCTION, AS APPLICABLE.

** IF LIMITS OF CONSTRUCTION
EXCEED RIGHT OF WAY, A
PROPERTY AGREEMENT IS REQUIRED.

6-LANE
ARTERIAL
NEW CONSTRUCTION
DIVIDED
URBAN
WITH BIKE LANES
DESIGN SPEED 45 MPH OR LESS

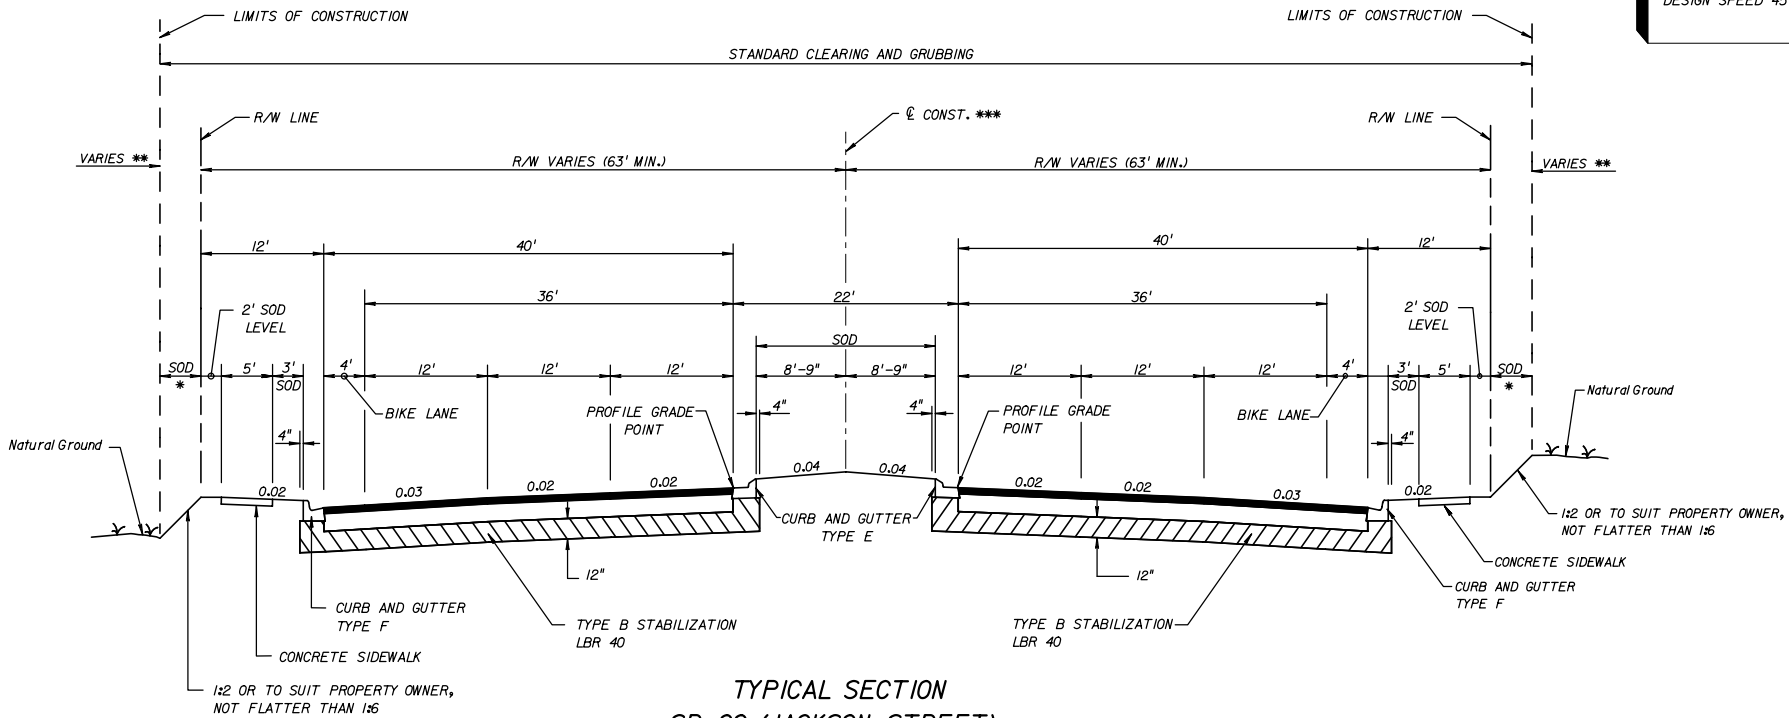

**TYPICAL SECTION
SR 00 (JACKSON STREET)
STA. 101+21.00 TO STA. 221+44.00**

NEW CONSTRUCTION

OPTIONAL BASE GROUP 9 WITH
TYPE SP STRUCTURAL COURSE (TRAFFIC C) (2")
AND FRICTION COURSE FC-12.5 (TRAFFIC C) (1 1/2") (RUBBER)

TRAFFIC DATA

CURRENT YEAR = 1998 AADT = 22800
ESTIMATED OPENING YEAR = 2000 AADT = 25800
ESTIMATED DESIGN YEAR = 2020 AADT = 30600
K = 6% D = 55% T = 2% (24 HOUR)
DESIGN HOUR T = 1%
DESIGN SPEED = 45 MPH

TRAFFIC DATA IS REQUIRED TO BE
NOTED FOR CURRENT YEAR, OPENING
YEAR AND DESIGN YEAR.

* TURF OR SOD

FOR STANDARD TYPICAL SECTION NOTES
REFER TO EXHIBIT 6-1, THIS CHAPTER.

EXHIBIT TYP-6
Date: 1/1/10

REVISIONS				STATE OF FLORIDA DEPARTMENT OF TRANSPORTATION			SHEET NO.
DATE	DESCRIPTION	DATE	DESCRIPTION	ROAD NO.	COUNTY	FINANCIAL PROJECT ID	
				10	LEON	123456-1-52-01	


TYPICAL SECTION

#USER# #DATE# #TIME# #FILE#

*** @ SURVEY AND/OR
 @ CONSTRUCTION, AS APPLICABLE.

** IF LIMITS OF CONSTRUCTION
 EXCEED RIGHT OF WAY, A
 PROPERTY AGREEMENT IS REQUIRED.

6-LANE
 ARTERIAL
 NEW CONSTRUCTION
 DIVIDED
 URBAN
 WITH BIKE LANES
 DESIGN SPEED 45 MPH OR LESS

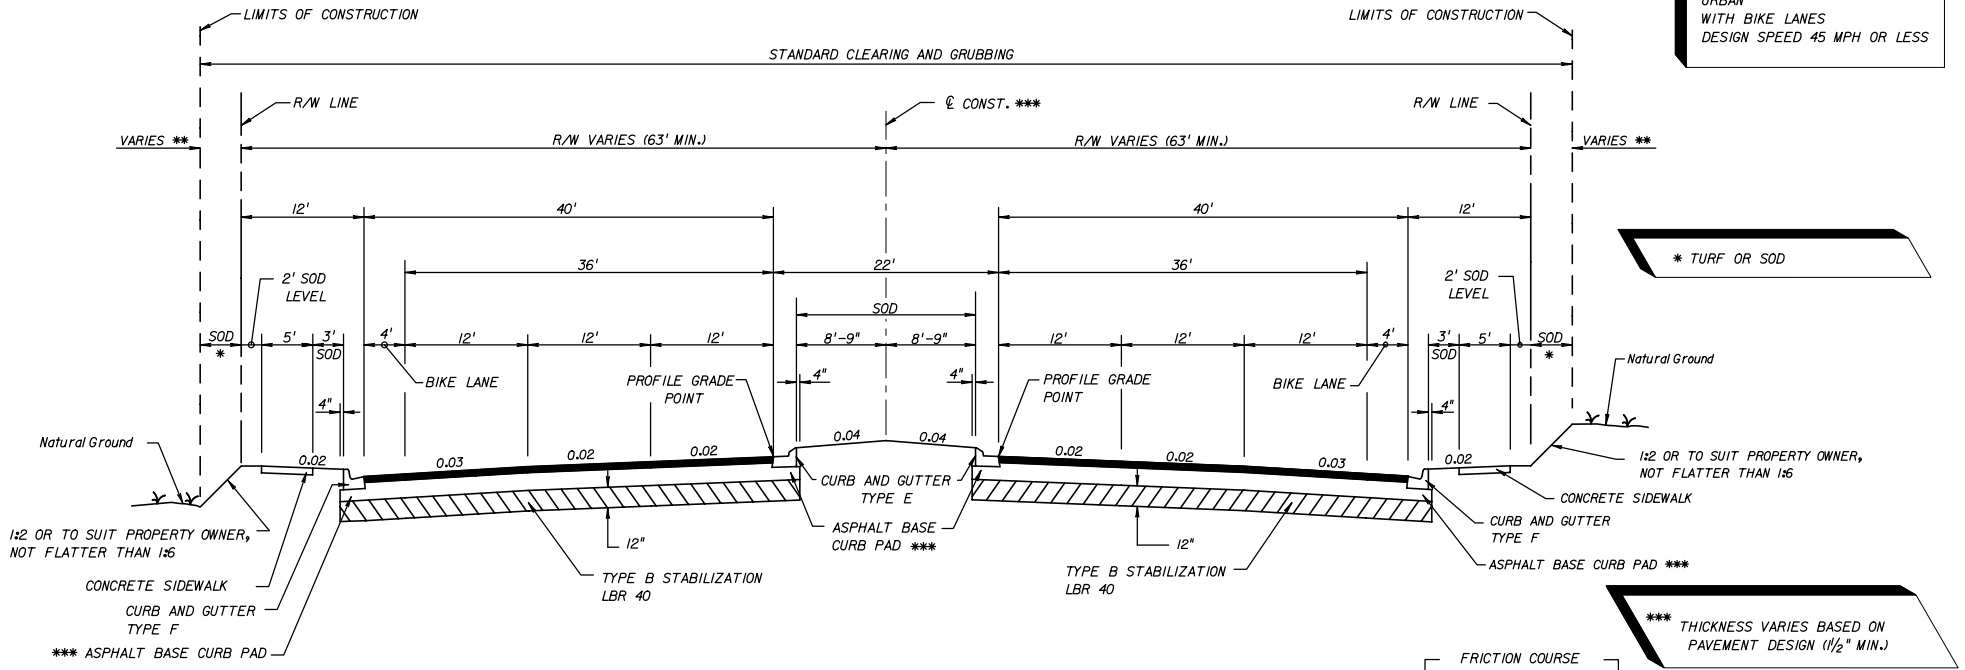


* TURF OR SOD

*** THICKNESS VARIES BASED ON
 PAVEMENT DESIGN (1/2" MIN.)

TYPICAL SECTION
SR 00 (JACKSON STREET)
STA. 101+21.00 TO STA. 221+44.00

NEW CONSTRUCTION

OPTIONAL BASE GROUP 9 (TYPE B-12.5 ONLY), WITH
 TYPE SP STRUCTURAL COURSE (TRAFFIC C) (3")
 AND FRICTION COURSE FC-12.5 (TRAFFIC C) (1/2") (RUBBER)

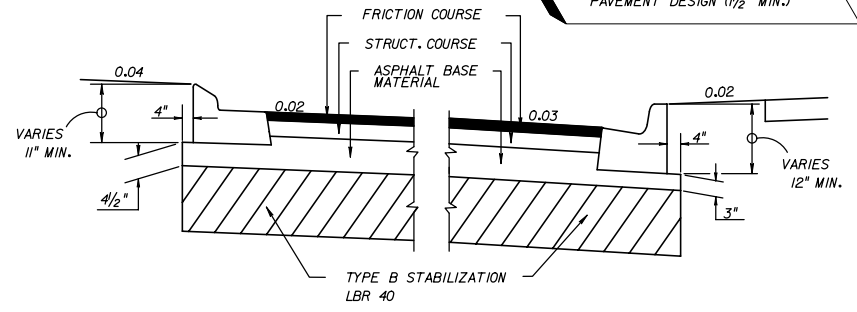

DETAIL OF ASPHALT BASE CURB PAD

TRAFFIC DATA

CURRENT YEAR = 1998 AADT = 22800
 ESTIMATED OPENING YEAR = 2000 AADT = 25800
 ESTIMATED DESIGN YEAR = 2020 AADT = 30600
 K = 6% D = 55% T = 2% (24 HOUR)
 DESIGN HOUR T = 1%
 DESIGN SPEED = 45 MPH

FOR STANDARD TYPICAL SECTION NOTES
 REFER TO EXHIBIT 6-1, THIS CHAPTER

TRAFFIC DATA IS REQUIRED TO BE
 NOTED FOR CURRENT YEAR, OPENING
 YEAR AND DESIGN YEAR.


EXHIBIT TYP-6A
 Date: 1/1/10

REVISIONS		STATE OF FLORIDA DEPARTMENT OF TRANSPORTATION			SHEET NO.
DATE	DESCRIPTION	DATE	DESCRIPTION	FINANCIAL PROJECT ID	
				10 LEON 123456-1-52-01	TYPICAL SECTION

NOTICE: THE OFFICIAL RECORD OF THIS SHEET IS THE ELECTRONIC FILE SIGNED AND SEALED UNDER RULE 6805-23.003, F.A.C.

* @ SURVEY AND/OR
 @ CONSTRUCTION, AS APPLICABLE.

EXISTING
 2-LANE (2-WAY)
 ARTERIAL/COLLECTOR
 MILLING AND RESURFACING
 NO CROSS SLOPE
 CORRECTION REQUIRED
 UNDIVIDED
 RURAL
 (WITH EXISTING BIKE LANES
 OR PAVED SHOULDERS)
 WITH PROJECTED 20 YR.
 AADT OF 1500 OR GREATER

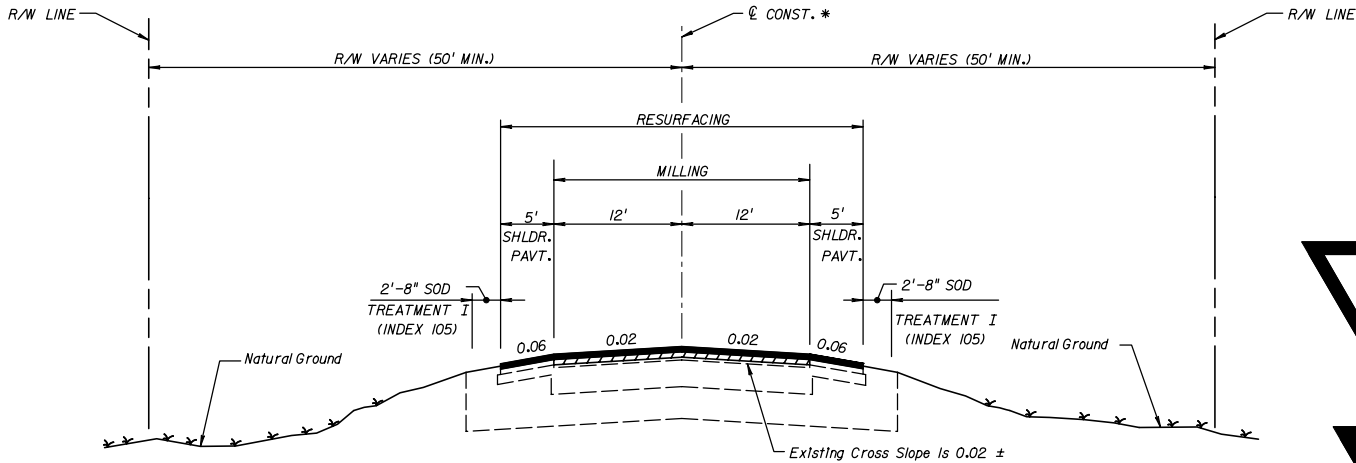

SOME PROJECTS MAY REQUIRE SHOULDER WORK.
 WHEN REQUIRED THIS SHOULD BE IDENTIFIED
 ON THE TYPICAL SECTION SHEET.

FOR STANDARD TYPICAL SECTION NOTES
 REFER TO EXHIBIT 6-1, THIS CHAPTER.

TRAFFIC DATA
STA. 10+53.00 TO STA. 130+77.00

CURRENT YEAR = 1998 AADT = 9670
 ESTIMATED OPENING YEAR = 2000 AADT = 11900
 ESTIMATED DESIGN YEAR = 2010 AADT = 20200
 K = 10% D = 60% T = 7% (24 HOUR)
 DESIGN HOUR T = 3%
 DESIGN SPEED = 55 MPH

TYPICAL SECTION
SR 00
STA. 10+53.00 TO STA. 130+77.00
STA. 206+82.28 TO STA. 368+41.21

STA. 206+82.28 TO 368+41.21

CURRENT YEAR = 1998 AADT = 6835
 ESTIMATED OPENING YEAR = 2000 AADT = 8600
 ESTIMATED DESIGN YEAR = 2010 AADT = 15100
 K = 10% D = 65% T = 7% (24 HOUR)
 DESIGN HOUR T = 3%
 DESIGN SPEED = 55 MPH

MILLING


MILL EXISTING ASPHALT PAVEMENT (2" AVG. DEPTH)

RESURFACING

TYPE SP STRUCTURAL COURSE (TRAFFIC B) (2")
 AND FRICTION COURSE FC-9.5 (TRAFFIC B) (1") (RUBBER)

SHOULDER PAVEMENT RESURFACING

FRICTION COURSE FC-9.5 (TRAFFIC B) (1") (RUBBER)

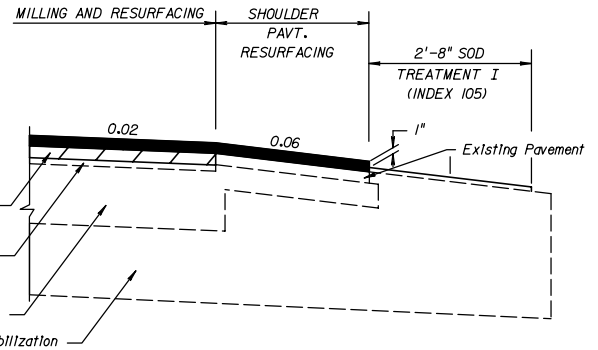

SHOULDER PAVEMENT DETAIL


TRAFFIC DATA IS REQUIRED TO BE NOTED FOR
 CURRENT YEAR, OPENING YEAR AND DESIGN YEAR.

EXHIBIT TYP-7
 Date: 1/1/10

REVISIONS				STATE OF FLORIDA DEPARTMENT OF TRANSPORTATION			TYPICAL SECTION	SHEET NO.
DATE	DESCRIPTION	DATE	DESCRIPTION	ROAD NO.	COUNTY	FINANCIAL PROJECT ID		
				10	LEON	123456-1-52-01		

#USER# #DATE# #TIME# #FILE#

NOTICE: THE OFFICIAL RECORD OF THIS SHEET IS THE ELECTRONIC FILE SIGNED AND SEALED UNDER RULE 6805-23.003, F.A.C.

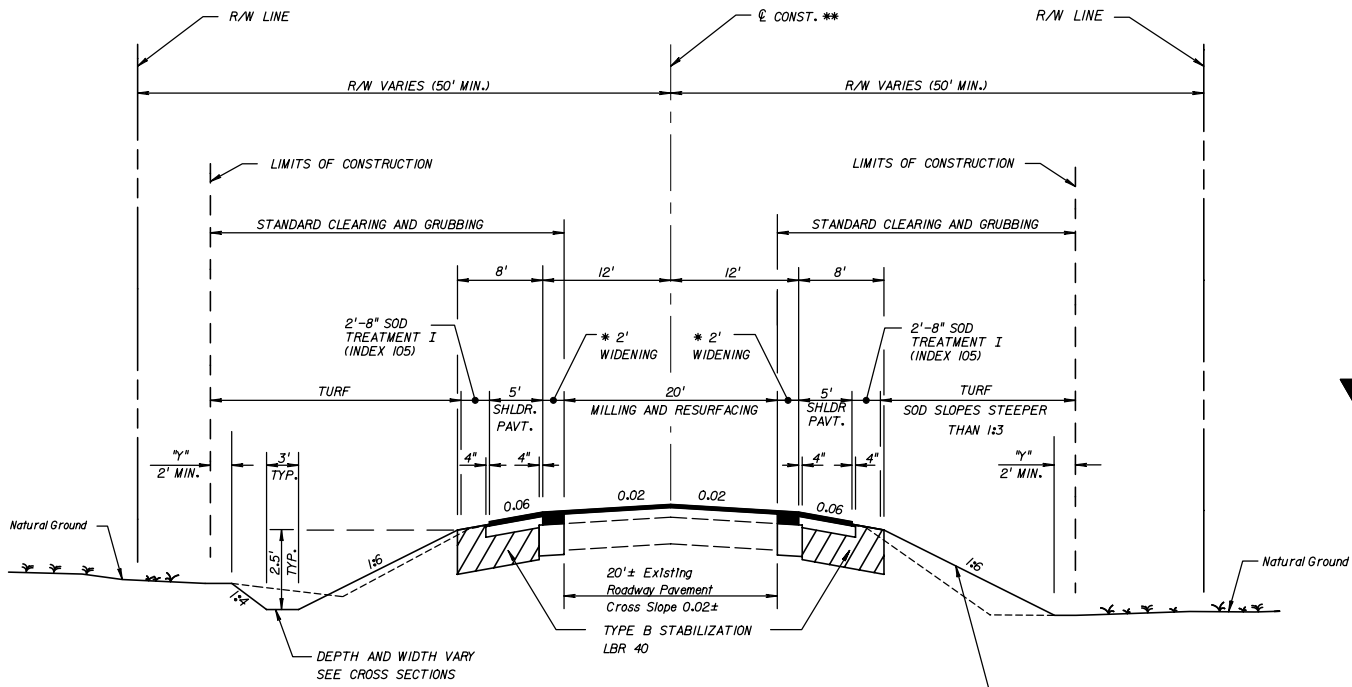

EXISTING
2-LANE (2-WAY)
ARTERIAL/COLLECTOR
WIDENING
MILLING AND RESURFACING
UNDIVIDED
RURAL
CONST. 5' SHOULDER
PAVEMENT OR BIKE LANE
WITH PROJECTED 20 YR.
AADT OF 1500 OR GREATER
DESIGN SPEED GREATER
THAN 50 MPH

** @ SURVEY AND/OR
@ CONSTRUCTION, AS APPLICABLE.

^y" THE AREA DISTURBED BY CONSTRUCTION VARIES.

1:6 FOR FILLS TO 5'
1:6 TO EDGE OF CLEAR ZONE & 1:4 FOR FILLS 5' TO 10'
1:6 TO EDGE OF CLEAR ZONE & 1:3 FOR FILLS 10' TO 20'
1:2 (WITH GUARDRAIL) FILLS OVER 20'

NOTE:
HEIGHT OF FILL IS THE VERTICAL DISTANCE
FROM THE EDGE OF THE OUTSIDE TRAVEL LANE
TO TOE OF FRONT SLOPE.

FOR STANDARD TYPICAL SECTION NOTES
REFER TO EXHIBIT 6-1, THIS CHAPTER.

* SEE SHEET 2 OF 2 FOR WIDENING
AND SHOULDER PAVEMENT DETAIL

EXHIBIT TYP-8
Date: 1/1/10
SHEET 1 OF 2

TRAFFIC DATA
STA. 20+25.00 TO STA. 48+16.56

CURRENT YEAR = 1998 AADT = 8700
ESTIMATED OPENING YEAR = 2000 AADT = 9200
ESTIMATED DESIGN YEAR = 2020 AADT = 23600
K = 10% D = 56% T = 5% (24 HOUR)
DESIGN HOUR T = 3%
DESIGN SPEED = 55 MPH

STA. 57+82.78 TO STA. 93+41.21

CURRENT YEAR = 1998 AADT = 6835
ESTIMATED OPENING YEAR = 2000 AADT = 8600
ESTIMATED DESIGN YEAR = 2020 AADT = 17200
K = 10% D = 65% T = 7% (24 HOUR)
DESIGN HOUR T = 3%
DESIGN SPEED = 55 MPH

TRAFFIC DATA IS REQUIRED TO BE NOTED FOR
CURRENT YEAR, OPENING YEAR AND DESIGN YEAR.

TYPICAL SECTION
SR 000
STA. 20+25.00 TO STA. 48+16.56
STA. 57+82.78 TO STA. 93+41.21

- MILLING**
MILL EXISTING ASPHALT PAVEMENT (2" AVG. DEPTH)
- RESURFACING**
TYPE SP STRUCTURAL COURSE (TRAFFIC C)(1 1/2")
AND FRICTION COURSE FC-12.5 (TRAFFIC C)(1 1/2")(RUBBER)
- WIDENING**
OPTIONAL BASE GROUP II WITH
TYPE SP STRUCTURAL COURSE (TRAFFIC C)(3")
AND FRICTION COURSE FC-12.5 (TRAFFIC C)(1 1/2")(RUBBER)

REVISIONS			
DATE	DESCRIPTION	DATE	DESCRIPTION


STATE OF FLORIDA DEPARTMENT OF TRANSPORTATION		
ROAD NO.	COUNTY	FINANCIAL PROJECT ID
10	LEON	123456-1-52-01

TYPICAL SECTION

SHEET NO.

NOTICE: THE OFFICIAL RECORD OF THIS SHEET IS THE ELECTRONIC FILE SIGNED AND SEALED UNDER RULE 6805-23.003, F.A.C.

THE NEED FOR STABILIZATION IN THE SHOULDER AREA ON RRR PROJECTS IS SITE SPECIFIC AND NOT ALWAYS REQUIRED. THE USE OF STABILIZING IN NARROW TRENCH WIDENING STRIPS IS NOT RECOMMENDED GENERALLY. SEE THE FLEXIBLE PAVEMENT DESIGN MANUAL FOR FURTHER CRITERIA.

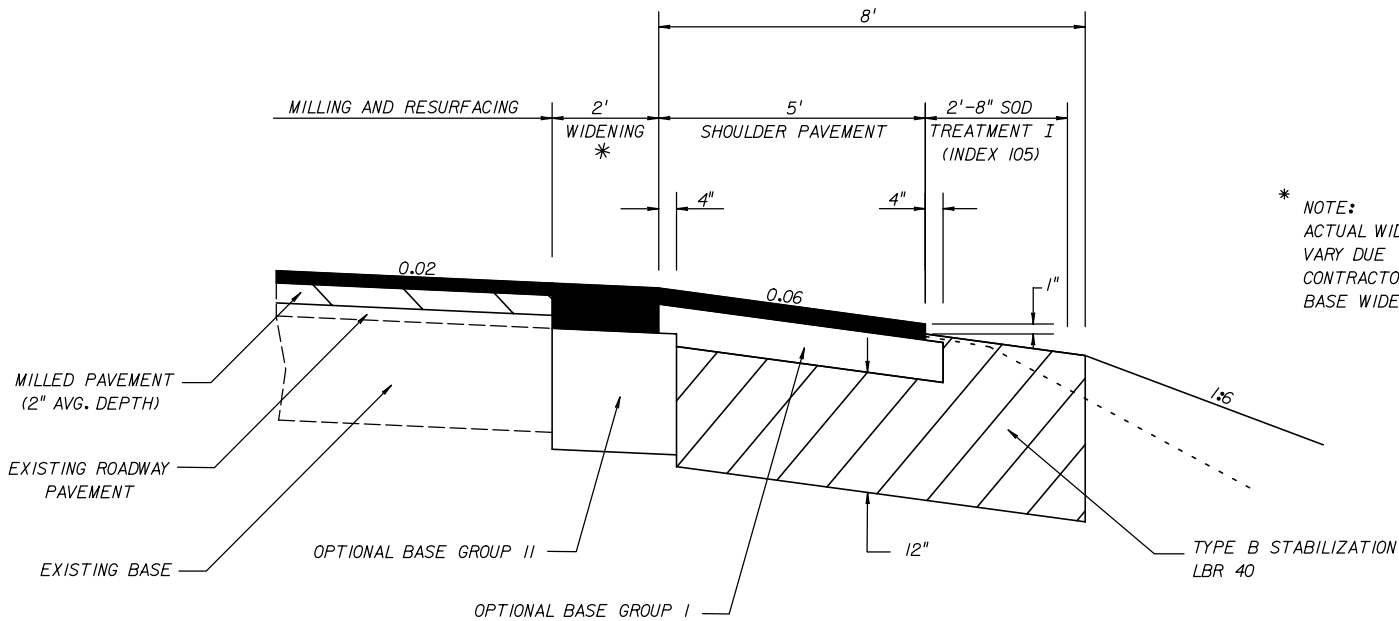

* NOTE:
ACTUAL WIDTH OF BASE WIDENING MAY VARY DUE TO ACTUAL PAVEMENT WIDTH. CONTRACTOR MAY ELECT TO PLACE UNIFORM BASE WIDENING AT NO ADDITIONAL COST.

WIDENING &
SHOULDER PAVEMENT DETAIL

WIDENING

OPTIONAL BASE GROUP II WITH
TYPE SP STRUCTURAL COURSE (TRAFFIC C) (3")
FRICTION COURSE FC-12.5 (TRAFFIC C) (1/2") (RUBBER)

SHOULDER PAVEMENT

OPTIONAL BASE GROUP I WITH
FRICTION COURSE FC-12.5 (TRAFFIC C) (1/2") (RUBBER)


FOR STANDARD TYPICAL SECTION NOTES REFER TO EXHIBIT 6-1, THIS CHAPTER

EXHIBIT TYP-8A
Date: 1/1/09

REVISIONS				STATE OF FLORIDA DEPARTMENT OF TRANSPORTATION			TYPICAL SECTION	SHEET NO.
DATE	DESCRIPTION	DATE	DESCRIPTION	ROAD NO.	COUNTY	FINANCIAL PROJECT ID		
				10	LEON	123456-1-52-01		

#USER# #DATE# #TIME# #FILE#

NOTICE: THE OFFICIAL RECORD OF THIS SHEET IS THE ELECTRONIC FILE SIGNED AND SEALED UNDER RULE 6805-23.003, F.A.C.

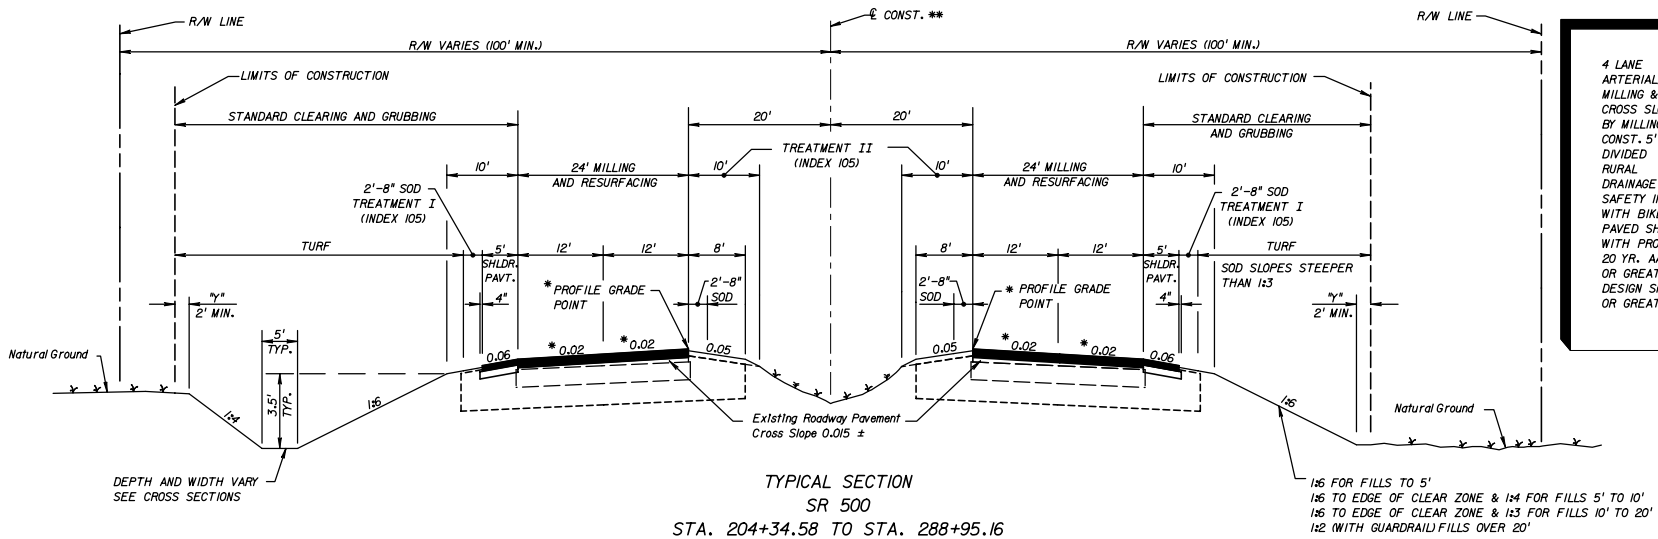

4 LANE
ARTERIAL/COLLECTOR
MILLING & RESURFACING
CROSS SLOPE CORRECTION
BY MILLING OR OVERBUILD
CONST. 5' SHLDR. PAV'T
DIVIDED
RURAL
DRAINAGE IMPROVEMENTS
SAFETY BIKE LANES OR
PAVED SHOULDERS
WITH PROJECTED
20 YR. AADT OF 1500
OR GREATER
DESIGN SPEED 45 MPH
OR GREATER

TYPICAL SECTION
SR 500
STA. 204+34.58 TO STA. 288+95.16

** @ SURVEY AND/OR
@ CONSTRUCTION, AS APPLICABLE.

TRAFFIC DATA
CURRENT YEAR = 1998 AADT = 18100
ESTIMATED OPENING YEAR = 2000 AADT = 21000
ESTIMATED DESIGN YEAR = 2012 AADT = 38900
K = 11X D = 58X T = 22X (24 HOUR)
DESIGN HOUR T = 11X
DESIGN SPEED = 60 MPH
POSTED SPEED = 55 MPH

TRAFFIC DATA IS REQUIRED TO BE NOTED FOR
CURRENT YEAR, OPENING YEAR, AND DESIGN YEAR.
POSTED SPEED (MPH) IS OPTIONAL.

* WHEN CROSS SLOPE CORRECTION IS NECESSARY
SPECIAL MILLING, OVERBUILD AND LAYERING DETAILS
MUST BE PROVIDED TO SUPPLEMENT TYPICAL SECTION.
THE NEED FOR AND LOCATION OF PROFILE GRADE
POINTS WILL DEPEND ON SITE SPECIFIC CONDITIONS.

MILLING
MILL EXISTING ASPHALT PAVEMENT (1/2" AVG. DEPTH)

RESURFACING
TYPE SP STRUCTURAL COURSE (TRAFFIC D) (1/2")
TYPE SP STRUCTURAL COURSE (TRAFFIC D) (1/2") (PG 76-22)
AND FRICTION COURSE FC-5 (3/4") (PG 76-22)

SHOULDER PAVEMENT
OPTIONAL BASE GROUP I WITH
TYPE SP STRUCTURAL COURSE (TRAFFIC D) (1/2") (PG 76-22)
AND FRICTION COURSE FC-5 (3/4") (PG 76-22)

STA. 316+53.67 TO STA. 527+82.00
MILLING
MILL EXISTING ASPHALT PAVEMENT (1/2" AVG. DEPTH)

OVERBUILD
TYPE SP OVERBUILD (TRAFFIC D) THICKNESS VARIES (1" TO 1 1/2")

RESURFACING
TYPE SP STRUCTURAL COURSE (TRAFFIC D) (1/2")
TYPE SP STRUCTURAL COURSE (TRAFFIC D) (1/2") (PG 76-22)
AND FRICTION COURSE FC-5 (3/4") (PG 76-22)

SHOULDER PAVEMENT
OPTIONAL BASE GROUP I WITH
TYPE SP STRUCTURAL COURSE (TRAFFIC D) (1/2") (PG 76-22)
AND FRICTION COURSE FC-5 (3/4") (PG 76-22)

NOTE:
HEIGHT OF FILL IS THE VERTICAL DISTANCE
FROM THE EDGE OF THE OUTSIDE TRAVEL LANE
TO TOE OF FRONT SLOPE.

"Y" THE AREA DISTURBED BY CONSTRUCTION VARIES.

FOR STANDARD TYPICAL SECTION NOTES
REFER TO EXHIBIT 6-1, THIS CHAPTER.


FOR MILLING AND RESURFACING DETAILS SEE
TYPICAL SECTION DETAILS SHEET 2 AND 3

EXHIBIT TYP-9
Date: 1/1/10
SHEET 1 OF 3

REVISIONS				STATE OF FLORIDA DEPARTMENT OF TRANSPORTATION			TYPICAL SECTION	SHEET NO.
DATE	DESCRIPTION	DATE	DESCRIPTION	ROAD NO.	COUNTY	FINANCIAL PROJECT ID		
				10	LEON	123456-1-52-01		

#USER# #DATE# #TIME# #FILE#

NOTICE: THE OFFICIAL RECORD OF THIS SHEET IS THE ELECTRONIC FILE SIGNED AND SEALED UNDER RULE 6805-23.003, F.A.C.

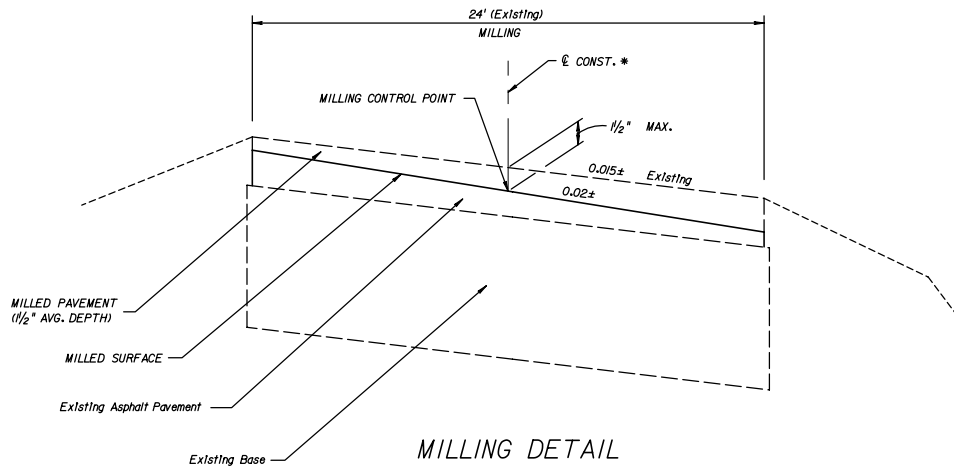


* @ SURVEY AND/OR
 @ CONSTRUCTION, AS APPLICABLE.

WHEN CROSS SLOPE CORRECTION IS NECESSARY
 SPECIAL MILLING AND LAYERING DETAILS MUST
 BE PROVIDED TO SUPPLEMENT TYPICAL SECTION.
 THE NEED FOR AND LOCATION OF PROFILE GRADE
 POINTS WILL DEPEND ON SITE SPECIFIC CONDITIONS.

EXAMPLE OF CROSS SLOPE CORRECTION BY MILLING.

FOR STANDARD TYPICAL SECTION NOTES
 REFER TO EXHIBIT 6-1, THIS CHAPTER.

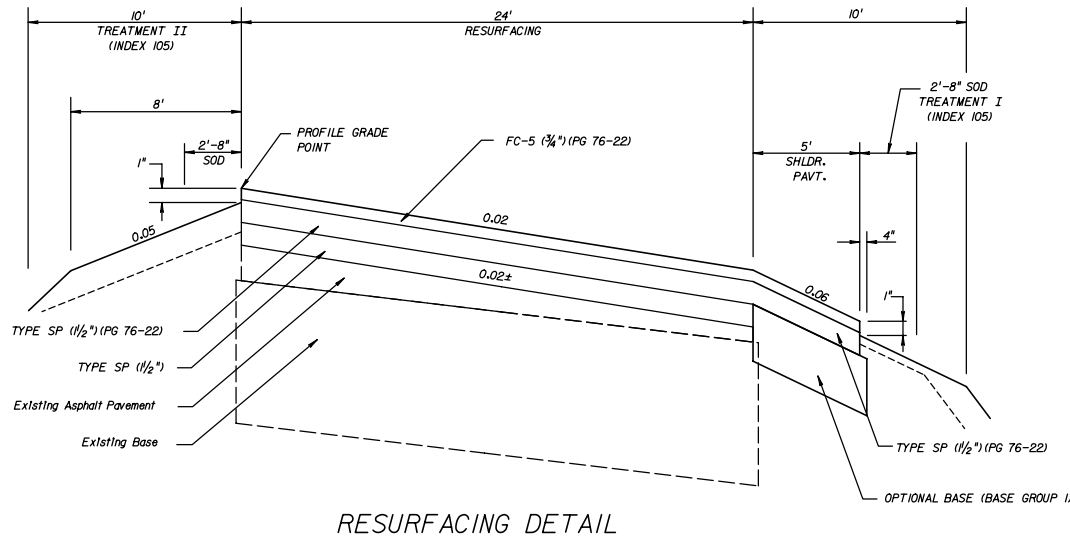

STA. 204+34.58 TO STA. 288+95.16


EXHIBIT TYP-9A
 Date: 1/1/10

SHEET 2 OF 3

REVISIONS				STATE OF FLORIDA DEPARTMENT OF TRANSPORTATION			TYPICAL SECTION DETAILS	SHEET NO.
DATE	DESCRIPTION	DATE	DESCRIPTION	ROAD NO.	COUNTY	FINANCIAL PROJECT ID		
				10	LEON	123456-1-52-01		

#USER# #DATE# #TIME# #FILE#


NOTICE: THE OFFICIAL RECORD OF THIS SHEET IS THE ELECTRONIC FILE SIGNED AND SEALED UNDER RULE 68G5-23.003, F.A.C.

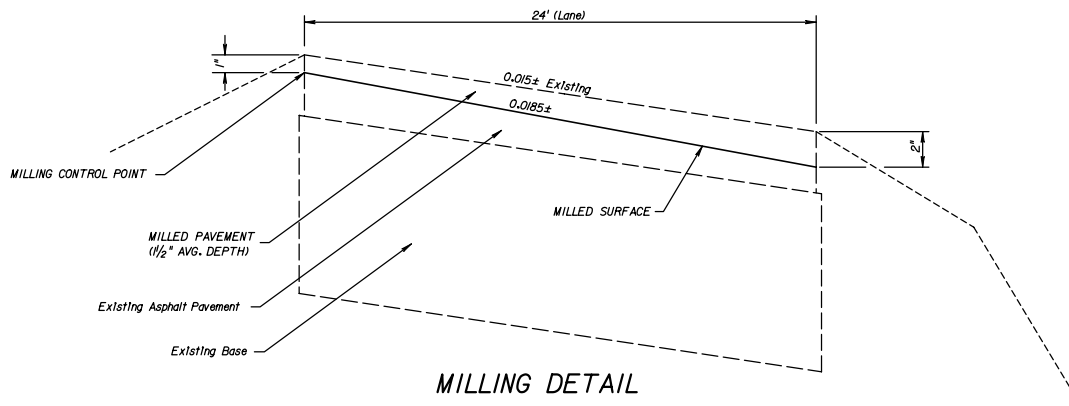

WHEN CROSS SLOPE CORRECTION IS NECESSARY SPECIAL MILLING, OVERBUILD AND LAYERING DETAILS MUST BE PROVIDED TO SUPPLEMENT TYPICAL SECTION. THE NEED FOR AND LOCATION OF PROFILE GRADES POINTS WILL DEPEND ON SITE SPECIFIC CONDITIONS.

EXAMPLE OF CROSS SLOPE CORRECTION BY MILLING AND OVERBUILD.

FOR STANDARD TYPICAL SECTION NOTES REFER TO EXHIBIT 6-1, THIS CHAPTER.

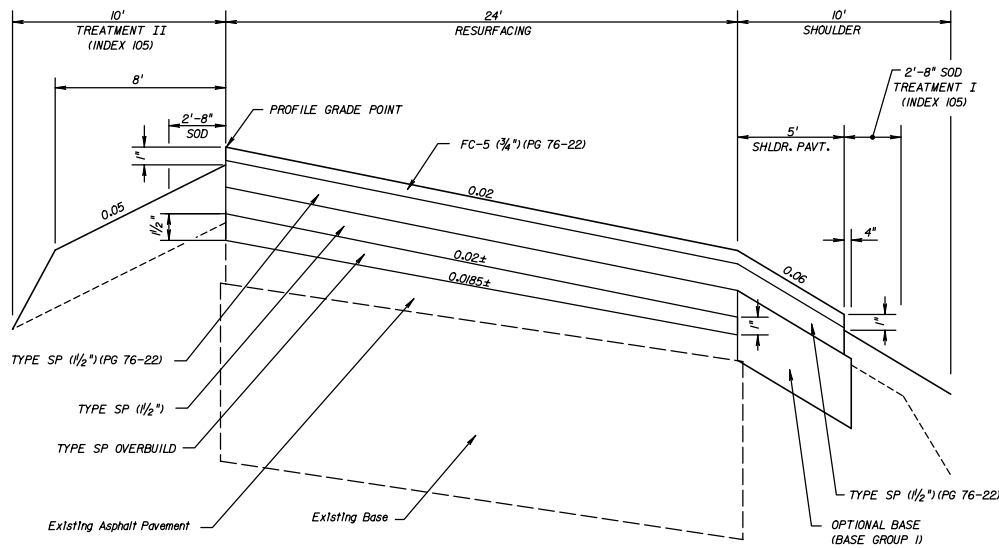

SUGGESTED CONSTRUCTION SEQUENCES SHOWN. OTHER SEQUENCES THAT MEET SPECIFICATIONS, THICKNESS AND CROSS SLOPE REQUIREMENTS MAY BE CONSIDERED BY THE ENGINEER.


STA. 316+53.67 TO STA. 527+82.00

EXHIBIT TYP-9B
Date: 1/1/10

SHEET 3 OF 3

REVISIONS				STATE OF FLORIDA DEPARTMENT OF TRANSPORTATION			TYPICAL SECTION DETAILS	SHEET NO.
DATE	DESCRIPTION	DATE	DESCRIPTION	ROAD NO.	COUNTY	FINANCIAL PROJECT ID		
				10	LEON	123456-1-52-01		

#USER# #DATE# #TIME# #FILE#

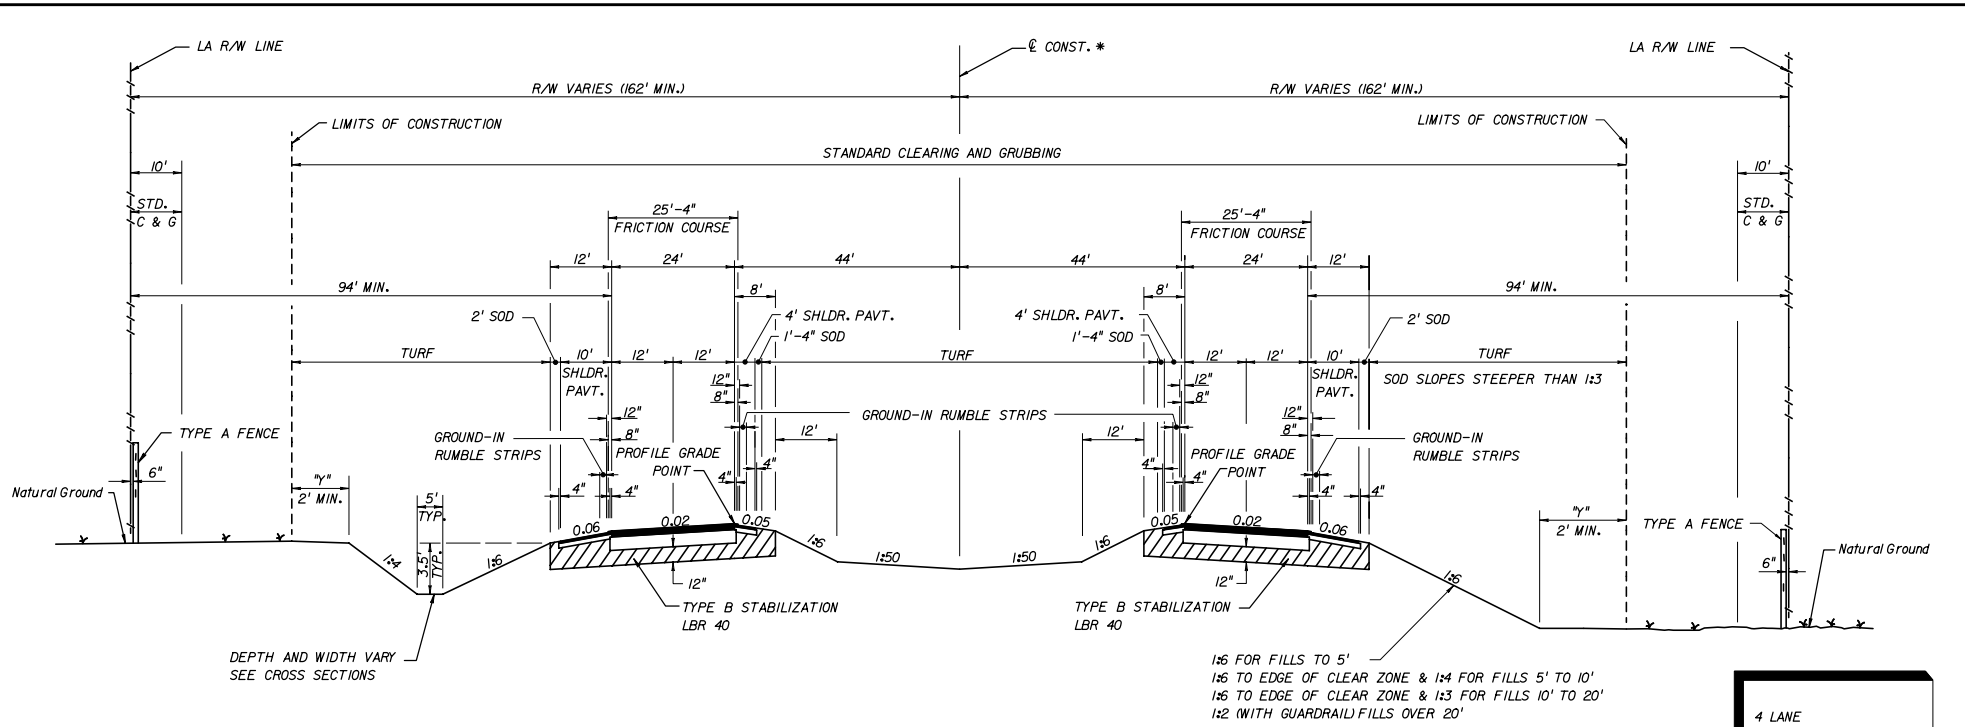

TRAFFIC DATA

CURRENT YEAR = 1998 AADT = 22300
 ESTIMATED OPENING YEAR = 2000 AADT = 23300
 ESTIMATED DESIGN YEAR = 2020 AADT = 51500
 K = 9 % D = 56 % T = 10 % (24 HOUR)
 DESIGN HOUR T = 5 %
 DESIGN SPEED = 70 MPH

TRAFFIC DATA IS REQUIRED TO BE NOTED FOR CURRENT YEAR, OPENING YEAR, AND DESIGN YEAR. POSTED SPEED (MPH) IS OPTIONAL.

FOR STANDARD TYPICAL SECTION NOTES REFER TO EXHIBIT 6-1, THIS CHAPTER

**TYPICAL SECTION
 SR 8
 STA. 567+25.67 TO STA. 1056+84.35**

NEW CONSTRUCTION

OPTIONAL BASE GROUP 9 WITH
 TYPE SP STRUCTURAL COURSE (TRAFFIC D) (2 1/2")
 TYPE SP STRUCTURAL COURSE (TRAFFIC D) (1 1/2") (PG 76-22) AND
 FRICTION COURSE FC-5 (3/4") (PG 76-22)

MEDIAN SHOULDER PAVEMENT

OPTIONAL BASE GROUP 1 WITH
 TYPE SP STRUCTURAL COURSE (TRAFFIC D) (1 1/2")
 TYPE SP STRUCTURAL COURSE (TRAFFIC D) (1 1/2") (PG 76-22) AND
 FRICTION COURSE FC-5 (3/4") (PG 76-22)

OUTSIDE SHOULDER PAVEMENT

OPTIONAL BASE GROUP 1 WITH
 TYPE SP STRUCTURAL COURSE (TRAFFIC B) (1 1/2") AND
 FRICTION COURSE FC-5 (3/4") (PG 76-22)

NOTE:
 HEIGHT OF FILL IS THE VERTICAL DISTANCE FROM THE EDGE OF THE OUTSIDE TRAVEL LANE TO TOE OF FRONT SLOPE.

* @ SURVEY AND/OR @ CONSTRUCTION, AS APPLICABLE.

"y" THE AREA DISTURBED BY CONSTRUCTION VARIES.


4 LANE INTERSTATE SYSTEM
 NEW CONSTRUCTION
 DIVIDED RURAL
 WITH PROJECTED 20 YR. AADT OF 1500 OR GREATER
 DESIGN SPEED TO MPH

EXHIBIT TYP-10
 Date: 1/1/10

REVISIONS				STATE OF FLORIDA DEPARTMENT OF TRANSPORTATION			TYPICAL SECTION	SHEET NO.
DATE	DESCRIPTION	DATE	DESCRIPTION	ROAD NO.	COUNTY	FINANCIAL PROJECT ID		
				10	LEON	123456-1-52-01		


#USER# #DATE# #TIME# #FILE#

NOTICE: THE OFFICIAL RECORD OF THIS SHEET IS THE ELECTRONIC FILE SIGNED AND SEALED UNDER RULE 6805-23.003, F.A.C.

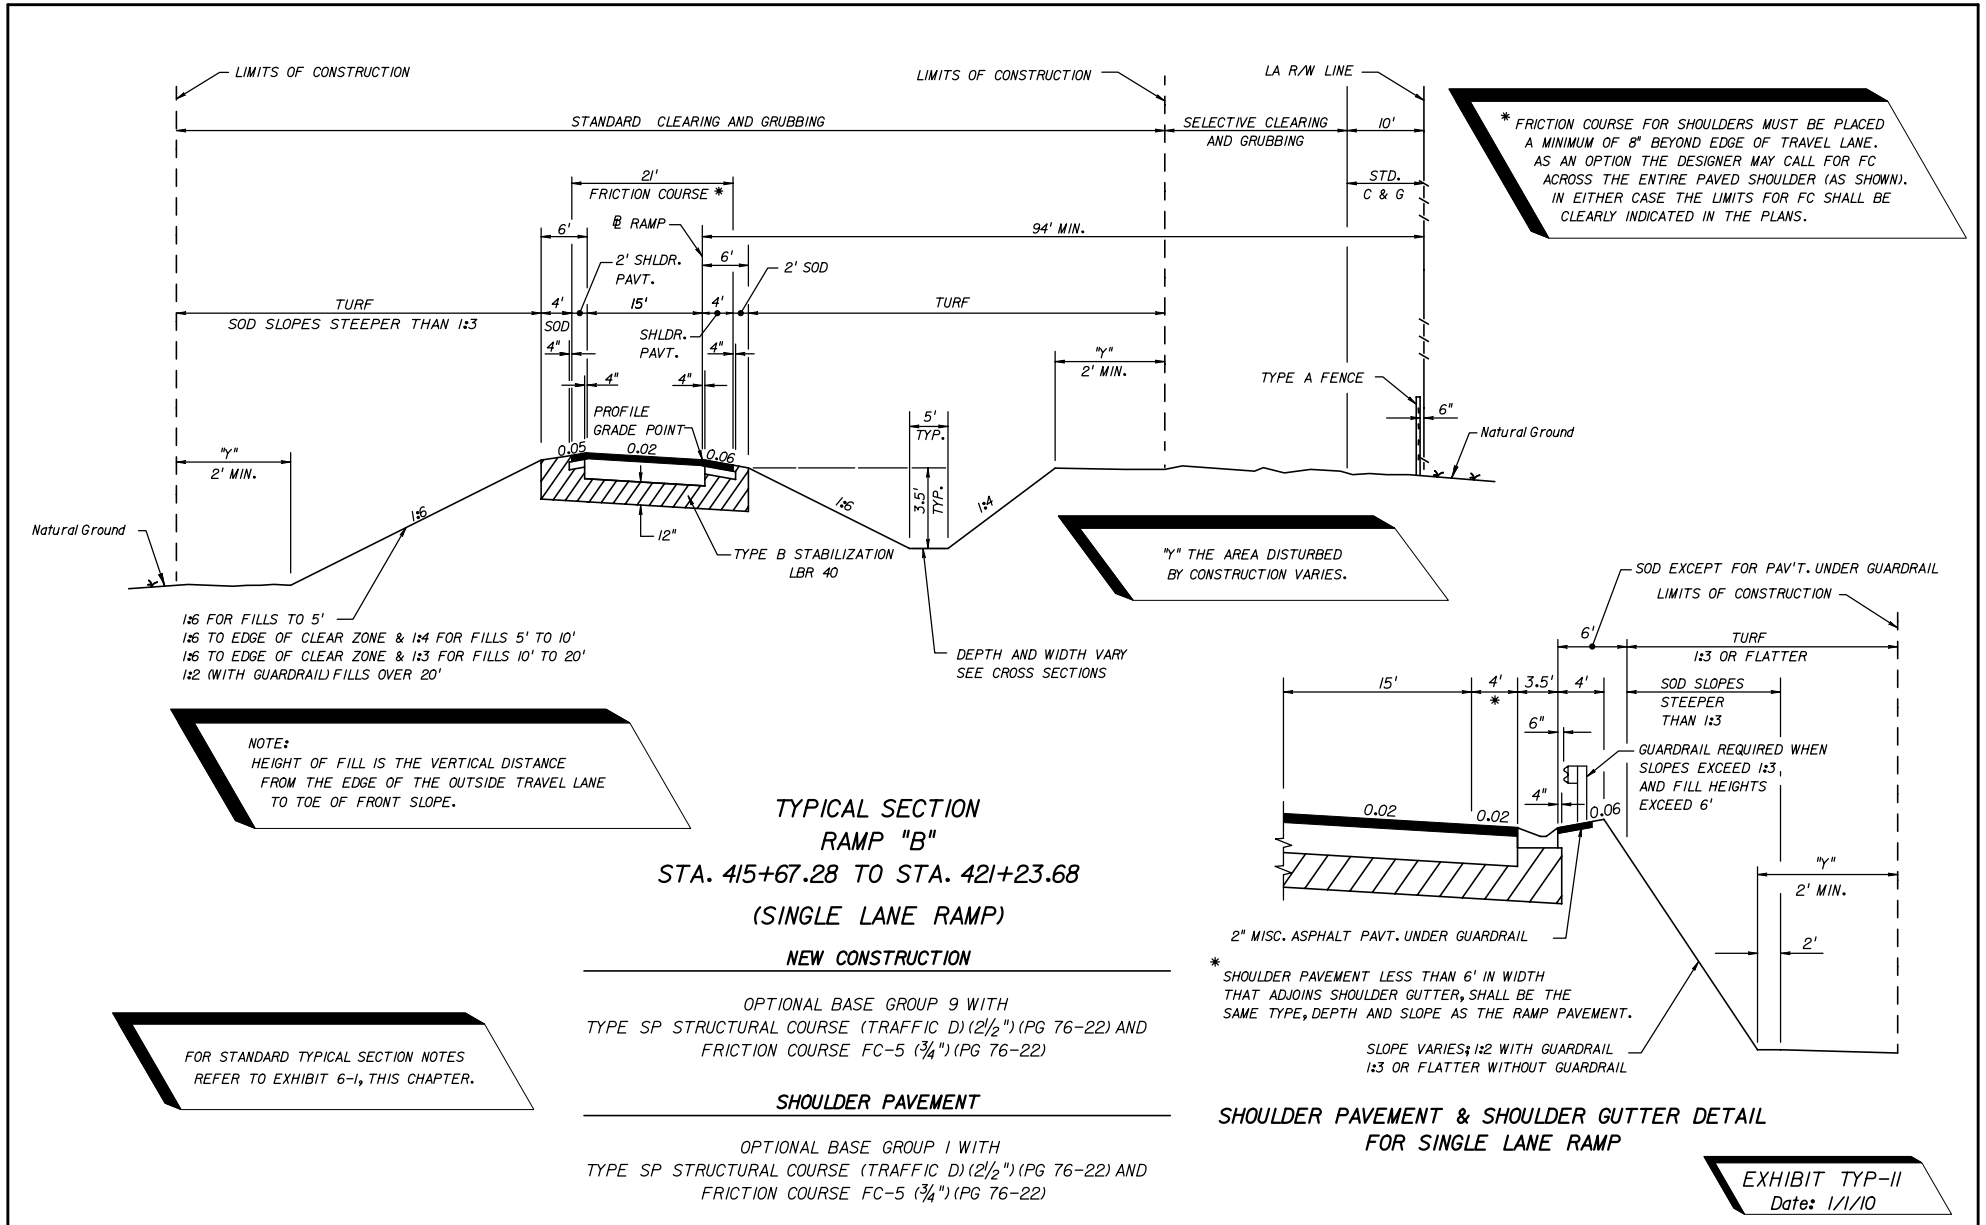

REVISIONS				STATE OF FLORIDA DEPARTMENT OF TRANSPORTATION			RAMP TYPICAL SECTION	SHEET NO.
DATE	DESCRIPTION	DATE	DESCRIPTION	ROAD NO.	COUNTY	FINANCIAL PROJECT ID		
				10	LEON	123456-1-52-01		

NOTICE: THE OFFICIAL RECORD OF THIS SHEET IS THE ELECTRONIC FILE SIGNED AND SEALED UNDER RULE 68G5-23.003, F.A.C.

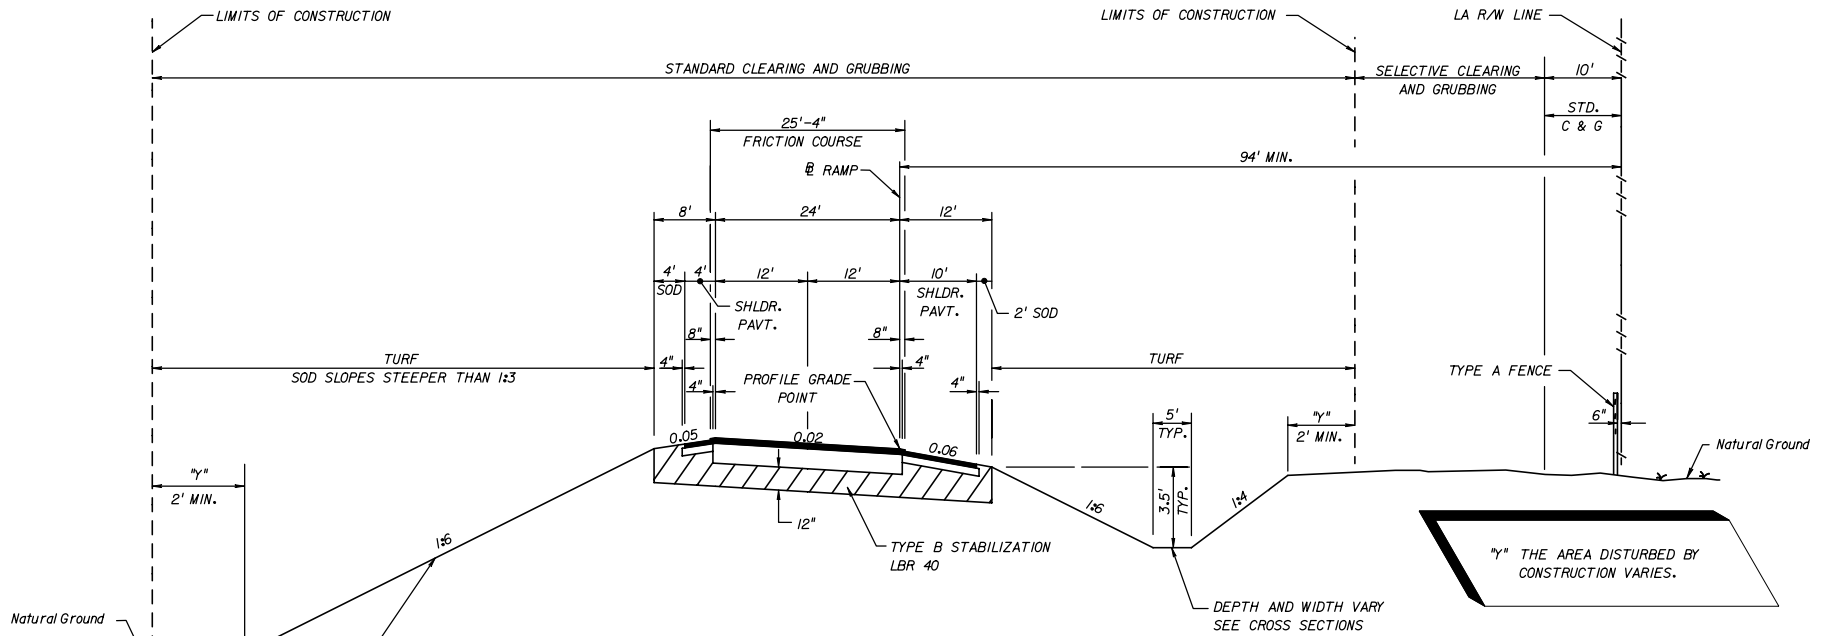

**TYPICAL SECTION
RAMP "C"
STA. 623+28.64 TO STA. 629+13.78
(TWO LANE RAMP)**

NEW CONSTRUCTION


OPTIONAL BASE GROUP 9 WITH
TYPE SP STRUCTURAL COURSE (TRAFFIC D) (2") (PG 76-22) AND
FRICTION COURSE FC-5 (3/4") (PG 76-22)

LEFT SHOULDER PAVEMENT

OPTIONAL BASE GROUP 1 WITH
TYPE SP STRUCTURAL COURSE (TRAFFIC D) (2") (PG 76-22) AND
FRICTION COURSE FC-5 (3/4") (PG 76-22)

RIGHT SHOULDER PAVEMENT

OPTIONAL BASE GROUP 1 WITH
TYPE SP STRUCTURAL COURSE (TRAFFIC B) (2") AND
FRICTION COURSE FC-5 (3/4") (PG 76-22)

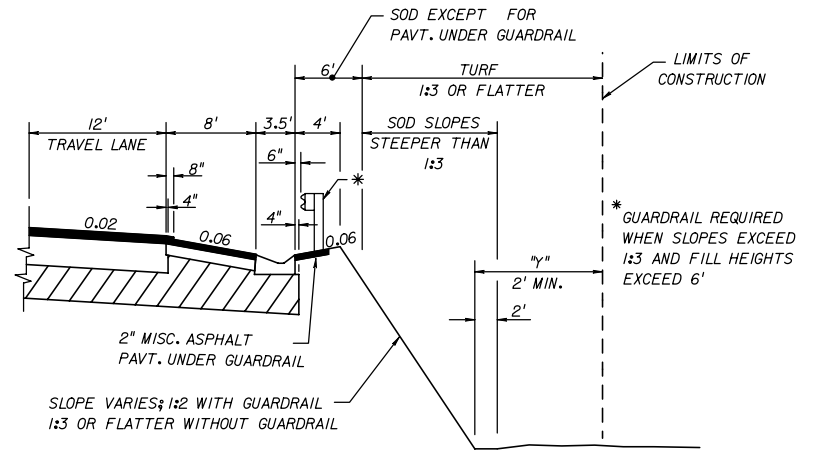

**SHOULDER PAVEMENT & SHOULDER GUTTER DETAIL
MAINLINE AND MULTILANE RAMPS**

**EXHIBIT TYP-12
Date: 1/1/10**

1:6 FOR FILLS TO 5'
1:6 TO EDGE OF CLEAR ZONE & 1:4 FOR FILLS 5' TO 10'
1:6 TO EDGE OF CLEAR ZONE & 1:3 FOR FILLS 10' TO 20'
1:2 (WITH GUARDRAIL) FILLS OVER 20'

NOTE:
HEIGHT OF FILL IS THE VERTICAL DISTANCE FROM THE EDGE OF THE OUTSIDE TRAVEL LANE TO TOE OF FRONT SLOPE.

FOR STANDARD TYPICAL SECTION NOTES REFER TO EXHIBIT 6-1, THIS CHAPTER

REVISIONS				STATE OF FLORIDA DEPARTMENT OF TRANSPORTATION			RAMP TYPICAL SECTION	SHEET NO.
DATE	DESCRIPTION	DATE	DESCRIPTION	ROAD NO.	COUNTY	FINANCIAL PROJECT ID		
				10	LEON	123456-1-52-01		

#USER# #DATE# #TIME# #FILE#


NOTICE: THE OFFICIAL RECORD OF THIS SHEET IS THE ELECTRONIC FILE SIGNED AND SEALED UNDER RULE 6805-23.003, F.A.C.

** @ SURVEY AND/OR
@ CONSTRUCTION, AS APPLICABLE.

IF LANDSCAPING IS DESIRED, TREES SHALL BE
TYPES THAT WILL NOT HAVE AN EXPECTED
GROWTH GREATER THAN 4" IN DIAMETER
MEASURED 6" ABOVE THE GROUND.

TURF SLOPES 1:3 OR FLATTER
* SOD SLOPES STEEPER THAN 1:3

4-LANE
ARTERIAL
NEW CONSTRUCTION
DIVIDED
URBAN AND SUBURBAN
WITH BIKE LANES
DESIGN SPEED 55 MPH OR LESS

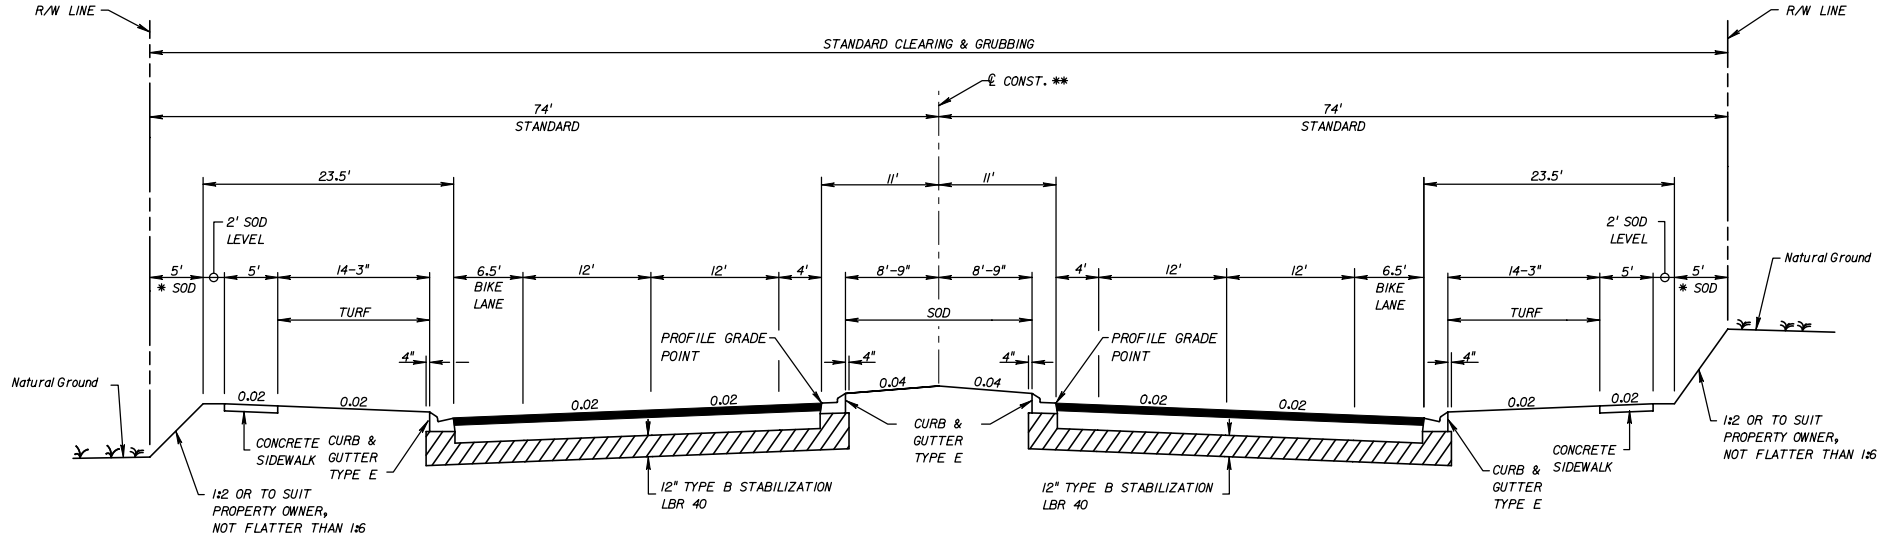

TRAFFIC DATA

CURRENT YEAR = 1999 AADT = 22800
ESTIMATED OPENING YEAR = 2002 AADT = 25800
ESTIMATED DESIGN YEAR = 2022 AADT = 30600
K = 6% D = 55% T = 2% (24 HOUR)
DESIGN HOUR T = 1%
DESIGN SPEED = 55 MPH

**TYPICAL SECTION
SR 00 (SARA AVE.)
STA. 50+40.00 TO STA. 125+50.00**

NEW CONSTRUCTION

OPTIONAL BASE GROUP 9 WITH
TYPE SP STRUCTURAL COURSE (TRAFFIC C) (3 1/2")
AND FRICTION COURSE FC-5 (3/4") (RUBBER)

TRAFFIC DATA IS REQUIRED TO BE
NOTED FOR CURRENT YEAR, OPENING
YEAR AND DESIGN YEAR.
POSTED SPEED (MPH) IS OPTIONAL.

FOR STANDARD TYPICAL SECTION NOTES
REFER TO EXHIBIT 6-1, THIS CHAPTER.

EXHIBIT TYP-13
Date: 1/1/10


REVISIONS		STATE OF FLORIDA DEPARTMENT OF TRANSPORTATION			TYPICAL SECTION	SHEET NO.
DATE	DESCRIPTION	DATE	DESCRIPTION	ROAD NO.		
				10		
				LEON		
				123456-1-52-01		

#USER# #DATE# #TIME# #FILE#

NOTICE: THE OFFICIAL RECORD OF THIS SHEET IS THE ELECTRONIC FILE SIGNED AND SEALED UNDER RULE 6805-23.003, F.A.C.

** @ SURVEY AND/OR
 @ CONSTRUCTION, AS APPLICABLE.

4-LANE
 ARTERIAL
 NEW CONSTRUCTION
 DIVIDED
 URBAN AND SUBURBAN
 WITH BIKE LANES
 DESIGN SPEED 55 MPH OR LESS

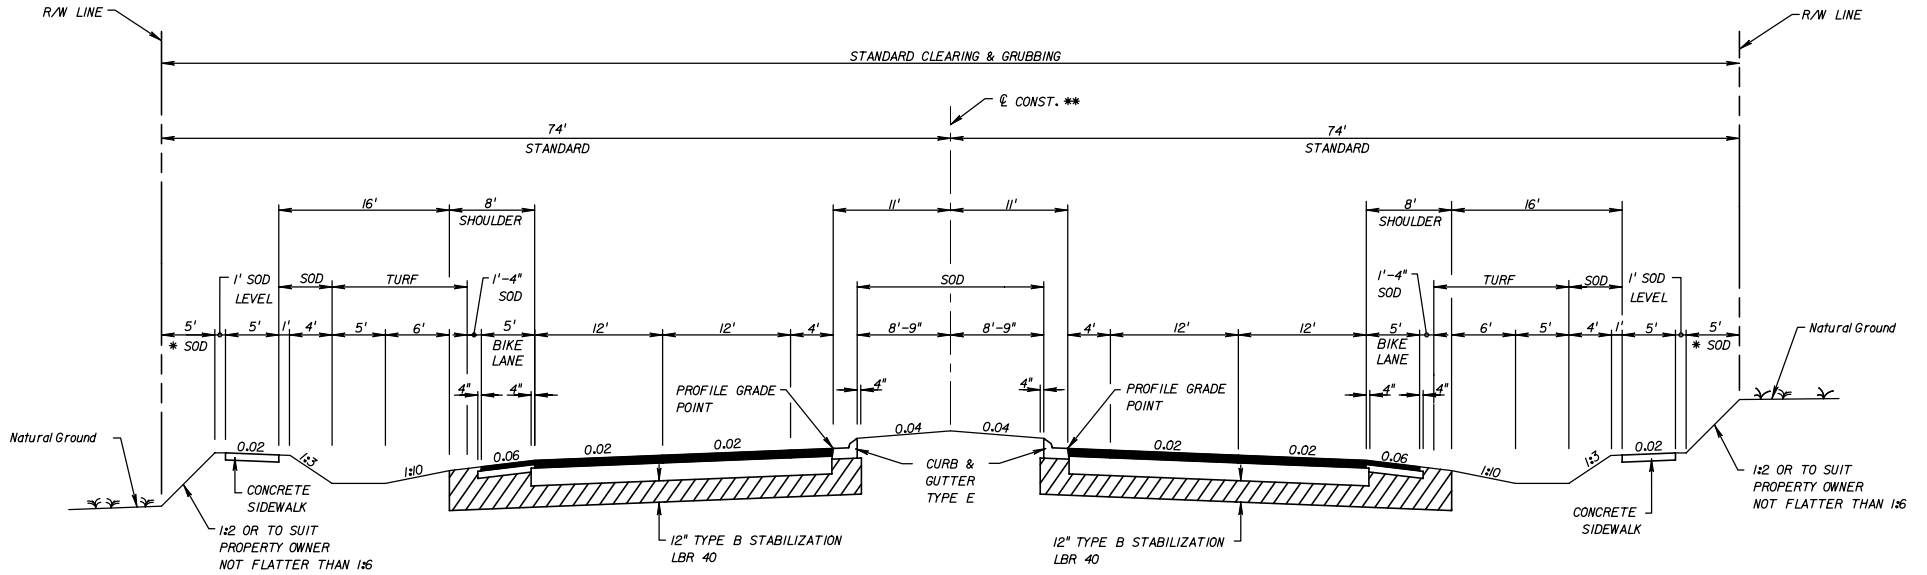

TRAFFIC DATA

CURRENT YEAR = 1999 AADT = 22800
 ESTIMATED OPENING YEAR = 2002 AADT = 25800
 ESTIMATED DESIGN YEAR = 2022 AADT = 30600
 K = 6% D = 55% T = 2% (24 HOUR)
 DESIGN HOUR T = 1%
 DESIGN SPEED = 55 MPH

TRAFFIC DATA IS REQUIRED TO BE
 NOTED FOR CURRENT YEAR, OPENING
 YEAR AND DESIGN YEAR.
 POSTED SPEED (MPH) IS OPTIONAL.

FOR STANDARD TYPICAL SECTION NOTES
 REFER TO EXHIBIT 6-1, THIS CHAPTER.

**TYPICAL SECTION
 SR 00 (CODY ROAD)
 STA. 100+40.00 TO STA. 225+50.00**

NEW CONSTRUCTION

OPTIONAL BASE GROUP 9 WITH
 TYPE SP STRUCTURAL COURSE (TRAFFIC C) (3/2")
 AND FRICTION COURSE FC-5 (3/4") (RUBBER)

SHOULDER PAVEMENT

OPTIONAL BASE GROUP 1 WITH
 TYPE SP STRUCTURAL COURSE (TRAFFIC C) (1/2")
 AND FRICTION COURSE FC-5 (3/4") (RUBBER)

TURF SLOPES 1:3 OR FLATTER
 * SOD SLOPES STEEPER THAN 1:3


IF LANDSCAPING IS DESIRED, TREES SHALL BE
 TYPES THAT WILL NOT HAVE AN EXPECTED
 GROWTH GREATER THAN 4" IN DIAMETER
 MEASURED 6" ABOVE THE GROUND.

EXHIBIT TYP-14
 Date: 1/1/10

REVISIONS				STATE OF FLORIDA DEPARTMENT OF TRANSPORTATION			TYPICAL SECTION	SHEET NO.
DATE	DESCRIPTION	DATE	DESCRIPTION	ROAD NO.	COUNTY	FINANCIAL PROJECT ID		
				10	LEON	123456-1-52-01		

#USER# #DATE# #TIME# #FILE#

NOTICE: THE OFFICIAL RECORD OF THIS SHEET IS THE ELECTRONIC FILE SIGNED AND SEALED UNDER RULE 6805-23.003, F.A.C.

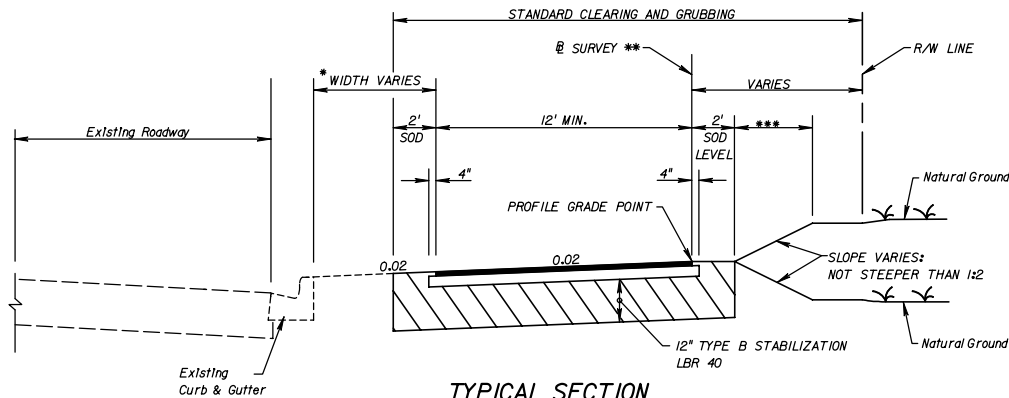

**TYPICAL SECTION
SHARED USE PATH
SR 00 (WILLOW WAY)
STA. 122+00.000 TO STA. 210+65.000
PATH**


OPTIONAL BASE GROUP 1 WITH
TYPE SP STRUCTURAL COURSE (TRAFFIC A) (1")

* FOR ROADWAYS WITH CURBS, A MINIMUM SEPARATION OF 4 FEET MEASURED FROM THE BACK OF CURB SHOULD BE PROVIDED.

*** TURF OR SOD

NOTE:
THE DESIGN SPEED FOR SHARED USE PATHS IS 20 MPH.

** @ SURVEY AND/OR
@ CONSTRUCTION, AS APPLICABLE.

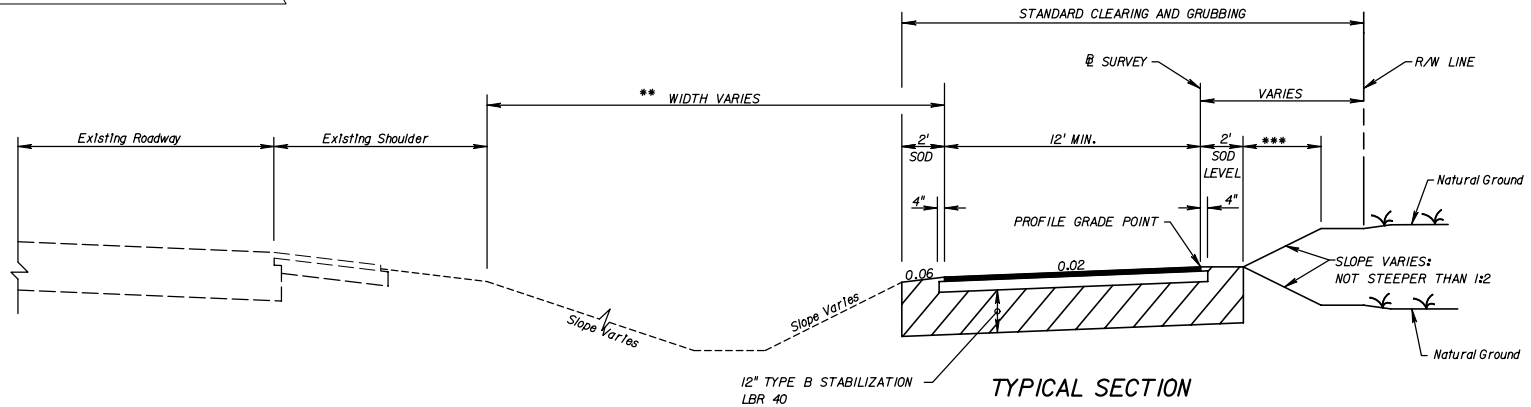

**TYPICAL SECTION
SHARED USE PATH
SR 00 (DEXTON HEIGHTS)
STA. 22+00.000 TO STA. 51+65.000
PATH**

OPTIONAL BASE GROUP 1 WITH
TYPE SP STRUCTURAL COURSE (TRAFFIC A) (1")

** FOR ROADWAYS WITH FLUSH SHOULDERS, A MINIMUM SEPARATION OF 5 FEET MEASURED FROM THE OUTSIDE EDGE OF SHOULDER TO THE INSIDE EDGE OF THE SHARED USE PATH SHOULD BE PROVIDED.

EXHIBIT TYP-15
Date: 1/1/10

REVISIONS			
DATE	DESCRIPTION	DATE	DESCRIPTION

STATE OF FLORIDA DEPARTMENT OF TRANSPORTATION		
ROAD NO.	COUNTY	FINANCIAL PROJECT ID
10	LEON	123456-1-52-01

SHARED USE PATH

SHEET NO.


#USER# #DATE# #TIME# #FILE#

NOTICE: THE OFFICIAL RECORD OF THIS SHEET IS THE ELECTRONIC FILE SIGNED AND SEALED UNDER RULE 6805-23.003, F.A.C.

*** @ SURVEY AND/OR
 @ CONSTRUCTION, AS APPLICABLE.

**** IF LIMITS OF CONSTRUCTION
 EXCEED RIGHT OF WAY, A
 PROPERTY AGREEMENT IS REQUIRED.

6-LANE
 ARTERIAL
 NEW CONSTRUCTION
 DIVIDED
 URBAN AND SUBURBAN
 WITH BIKE LANES
 DESIGN SPEED 50 MPH OR LESS

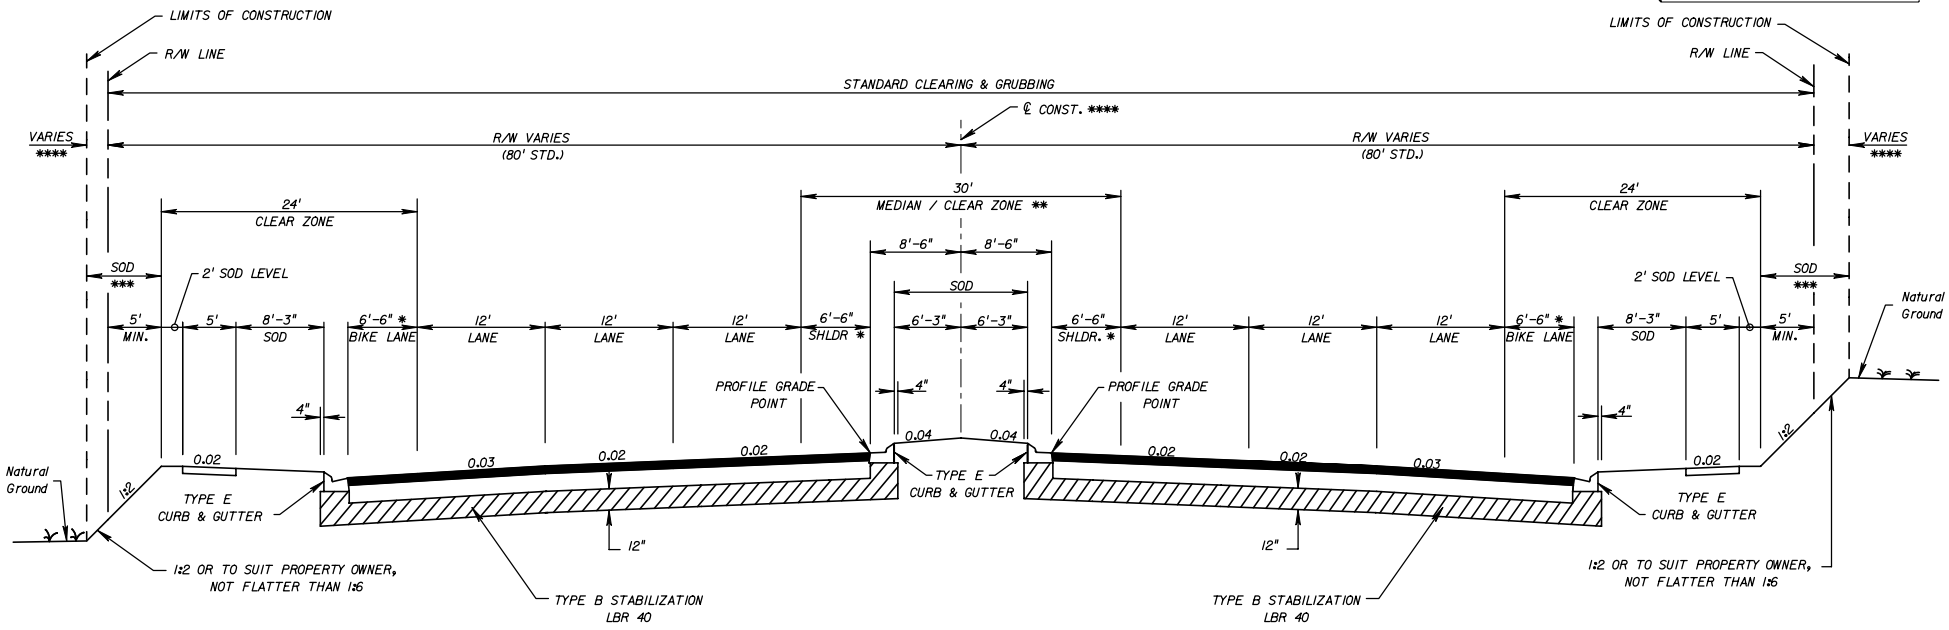

TYPICAL SECTION
SR 00 (SOUTH INDEPENDENCE STREET)
STA. 401+30.00 TO STA. 788+66.00

TRAFFIC DATA
 CURRENT YEAR = 1998 AADT = 22800
 ESTIMATED OPENING YEAR = 2000 AADT = 25800
 ESTIMATED DESIGN YEAR = 2020 AADT = 30600
 K = 6% D = 55% T = 2% (24 HOUR)
 DESIGN HOUR T = 1%
 DESIGN SPEED = 50 MPH

TRAFFIC DATA IS REQUIRED TO BE
 NOTED FOR CURRENT YEAR, OPENING
 YEAR AND DESIGN YEAR.

FOR STANDARD TYPICAL SECTION NOTES
 REFER TO EXHIBIT 6-1, THIS CHAPTER.

NEW CONSTRUCTION
 OPTIONAL BASE GROUP 9 WITH
 TYPE SP STRUCTURAL COURSE (TRAFFIC C) (3/2")
 AND FRICTION COURSE FC-5 (3/4") (RUBBER)

* PROVIDES FOR 8' OF USABLE SHOULDER

** THE 30' MEDIAN AREA PROVIDES SUFFICIENT WIDTH FOR:
 - 24' CLEAR ZONE
 - DUAL LEFT TURN LANES (11' lanes, 4' separator in median shoulder)
 - DIRECTIONAL MEDIAN OPENING (4' separators in median shoulder)

*** TURF OR SOD

EXHIBIT TYP-16
 Date: 1/1/10

REVISIONS		STATE OF FLORIDA DEPARTMENT OF TRANSPORTATION			SHEET NO.
DATE	DESCRIPTION	DATE	DESCRIPTION	FINANCIAL PROJECT ID	
				10 LEON 123456-1-52-01	

TYPICAL SECTION

#USER# #DATE# #TIME# #FILE#

NOTICE: THE OFFICIAL RECORD OF THIS SHEET IS THE ELECTRONIC FILE SIGNED AND SEALED UNDER RULE 6805-23.003, F.A.C.

SUMMARY OF PERFORMANCE TURF, SOD

LOCATION STA. TO STA.	SIDE	P			F			FIELD BOOK REFERENCE
		L	W	SY	L	W	SY	
<i>NB I-00</i>								
570+00 - 580+62	Med.	1062	1.33	157				
570+00 - 574+57	Rt.	457	1.33	68				
575+45 - 576+80	Rt.	135	1.33	20				
576+80 - 579+95	Rt.	315	56	1960				
579+95 - 580+62	Rt.	67	32	238				
580+62 - 586+37	Med.	575	1.33	85				
580+62 - 586+37	Rt.	575	1.33	85				
<i>SB I-00</i>								
570+00 - 580+62	Med.	1062	1.33	157				
570+00 - 574+57	Lt.	457	1.33	68				
575+45 - 577+25	Lt.	180	1.33	27				
577+25 - 580+34	Lt.	309	48	1648				
580+34 - 580+62	Lt.	28	37	115				
580+62 - 586+37	Med.	575	1.33	85				
580+62 - 586+37	Lt.	575	1.33	85				
<i>RAMP A</i>								
182+99 - 187+24	Lt.	425	1.33	63				
180+87 - 187+74	Rt.	687	1.33	102				
<i>RAMP B</i>								
276+62 - 281+75	Lt.	513	1.33	76				
274+47 - 280+29	Rt.	582	1.33	86				
<i>RAMP C</i>								
382+45 - 386+88	Rt.	443	1.33	65				
381+95 - 388+30	Lt.	635	1.33	94				
<i>RAMP D</i>								
481+05 - 485+63	Lt.	458	1.33	68				
480+64 - 487+31	Rt.	667	1.33	99				
<i>DRAINAGE STRUCTURES</i>				807				
<i>PAVED DITCHES</i>				278				
<i>TOTAL</i>				6536				

SUMMARY OF SIDE DRAIN & MITERED END SECTIONS

LOCATION STA. TO STA.	SIDE	PIPE LENGTH (LF)					MES (EA)				
		UP TO 24"			25" TO 36"		15"	18"	24"	30"	36"
		15"	18"	24"	30"	36"					
P 150+10 - 150+50	Rt.	40					2				
F 160+85 - 161+21	Lt.		36					2			
P 176+36 - 176+78	Lt.				42					2	
F 181+46 - 181+98	Rt.			52					2		
P 192+46 - 192+82	Lt.	36					2				
F 194+50 - 195+14	Rt.				64					2	
P											
F											
P											
F											
P											
F											
<i>UNIT QUANTITY</i>		76	36	52	42	64	4	2	2	2	2
<i>PLAN QUANTITY</i>		164			106		4	2	2	2	2
<i>FINAL QUANTITY</i>											

EXHIBIT SQ-1
Date: 1/1/09

REVISIONS				STATE OF FLORIDA DEPARTMENT OF TRANSPORTATION	SUMMARY OF QUANTITIES	SHEET NO.
DATE	DESCRIPTION	DATE	DESCRIPTION			

SUMMARY OF GUARDRAIL

LOCATION		GUARDRAIL (LF)										END ANCHORAGE ASSEMBLIES (EA)								REMARKS	FIELD BOOK REFERENCE
STATION	SIDE	ROADWAY						PEDESTRIAN SAFETY TREATMENT		RUB RAIL		FLARED		PARALLEL		TYPE II		TYPE CRT			
		ROADWAY		DOUBLE FACE		MOD. THRIE BEAM DOUBLE FACE		P	F	P	F	P	F	P	F	P	F	P	F		
		P	F	P	F	P	F														
FROM 600+50	Rt.	87.5							FROM		FROM 600+70										
TO 601+37									TO		TO 601+20										
FROM 600+10	Lt.	125.0							FROM		FROM										
TO 601+35									TO		TO										
FROM 602+25	Rt.	100.0							FROM 602+30		FROM										
TO 603+25									TO 603+00		TO										
FROM 600+50	Med.		275.0						FROM		FROM										
TO 603+25										TO		TO									
FROM 604+25	Rt.	62.5							FROM		FROM										
TO 604+87									TO		TO										
FROM 602+45	Lt.	75.0							FROM		FROM										
TO 603+20									TO		TO										
FROM 604+50	Med.							150.0	FROM		FROM										
TO 606+00										TO		TO									
TOTAL			450		275		150							3		1		7		1	

SUMMARY OF DITCH PAVEMENT AND PERFORMANCE TURF, SOD

LOCATION	SIDE	RIPRAP (SAND CEMENT)		RIPRAP (RUBBLE)		CONCRETE		PERF. TURF (SOD)		REMARKS	FIELD BOOK REFERENCE
		CY		TN		SY		SY			
		P	F	P	F	P	F	P	F		
128+17	Lt		21.6								
128+52	Rt		24.2								
137+12 (S-2)	Lt					26		8			
156+14 (S-6)	Lt					30		9			
158+00 (S-7)	Lt/Rt					96		42			
161+20 (S-9)	Lt					40		10			
168+40 (S-12)	Rt					108		12			
172+87 (S-15)	Rt					56		10			
180+12 (S-17)	Lt					20		8			
182+57 (S-20)	Rt					20		7			
TOTAL			45.8			396		106			

WHEN A PEDESTRIAN SAFETY TREATMENT, AND/OR RUB RAIL TREATMENT, IS TO BE PROVIDED FOR A RUN OF GUARDRAIL, THE BEGINNING AND END STATION IS TO BE NOTED AS SHOWN IN THE SUMMARY OF GUARDRAIL ABOVE. OTHERWISE, THESE COLUMNS MAY BE DELETED.

EXHIBIT SQ-2
Date: 1/1/09

REVISIONS				STATE OF FLORIDA DEPARTMENT OF TRANSPORTATION			SUMMARY OF QUANTITIES	SHEET NO.
DATE	DESCRIPTION	DATE	DESCRIPTION	ROAD NO.	COUNTY	FINANCIAL PROJECT ID		
				10	LEON	123456-1-52-01		

NOTICE: THE OFFICIAL RECORD OF THIS SHEET IS THE ELECTRONIC FILE SIGNED AND SEALED UNDER RULE 6805-23.003, F.A.C.

SUMMARY OF EARTHWORK		
DESCRIPTION	P	F
	CY	CY
ROADWAY EXCAVATION, MAINLINE	10,000	
ROADWAY EXCAVATION, ADAMS ST.	800	
REGULAR EXCAVATION, POND #1	1,005	
REGULAR EXCAVATION FROM LATERAL DITCHES	5,000	
TOTAL REGULAR EXCAVATION	16,805	
EMBANKMENT, MAINLINE	20,000	
EMBANKMENT, ADAMS ST.	7,000	
TOTAL EMBANKMENT	27,000	
SUBSOIL EXCAVATION, MAINLINE	2,080	
SUBSOIL EXCAVATION, ADAMS ST.	1,100	
TOTAL SUBSOIL EXCAVATION	3,180	

SUMMARY OF EARTHWORK		
DESCRIPTION	P	F
	CY	CY
FILL, MAINLINE	253	
FILL, GUARDRAIL LOCATIONS	70	
FILL, CROSS DRAINS	100	
SUB-TOTAL FILL	423	
FILL ADJUSTMENT (20%)(423 x 0.20)	+85	
SUB-TOTAL WITH FILL ADJUSTMENT	508	
TRUCK ADJUSTMENT (25%)(571 x 0.25)	+127	
TOTAL BORROW EXCAVATION	635	

Earthwork has been calculated using the _____ base option.
 If another option is constructed, there shall be no revision to the
 earthwork quantities for which payment is made by Plan Quantity.

FOR PROJECTS WITH CROSS SECTIONS

FOR PROJECTS WITHOUT CROSS SECTIONS
 Adjustment percentages shown are for example only.
 Contact District Materials Office or Construction
 for actual percentages to be used for each project.

EXHIBIT SQ-3
 Date: 1/1/09

REVISIONS				STATE OF FLORIDA DEPARTMENT OF TRANSPORTATION			SUMMARY OF QUANTITIES	SHEET NO.
DATE	DESCRIPTION	DATE	DESCRIPTION	ROAD NO.	COUNTY	FINANCIAL PROJECT ID		
				10	LEON	123456-1-52-01		

NOTICE: THE OFFICIAL RECORD OF THIS SHEET IS THE ELECTRONIC FILE SIGNED AND SEALED UNDER RULE 68G5-23.003, F.A.C.

SUMMARY OF PERMANENT CRASH CUSHIONS

STATION	SIDE	DESIGN SPEED	OPTIONS ALLOWED	TRANSITION REQUIRED Y/N	PAY ITEMS								
					544-75-40		544-75-22		544-75-9		544-75-14		
					P	F	P	F	P	F	P	F	
100+50	Rt	60	QuadGuard	Y	1								
			TAU II	Y									
			TRACC	Y									
103+10	Med	60	WideTRACC	Y			1						
110+65	Med	60	BRAKEMASTER	N					1				
125+23	Rt	70	QuadGuard HS	Y	1								
			TAU II	Y									
			TRACC	Y									
1175+15	Rt	35	QuadGuard	Y								1	
1321+37	Lt	50	QuadGuard	Y	1								
			TAU II	Y									
Total					3		1		1		1		

EXHIBIT SQ-4
Date: 1/1/09

REVISIONS				STATE OF FLORIDA DEPARTMENT OF TRANSPORTATION	SUMMARY OF QUANTITIES	SHEET NO.
DATE	DESCRIPTION	DATE	DESCRIPTION			

NOTICE: THE OFFICIAL RECORD OF THIS SHEET IS THE ELECTRONIC FILE SIGNED AND SEALED UNDER RULE 6805-23.003, F.A.C.

SUMMARY OF LITTER REMOVAL AND MOWING

CONST. PHASE	DURATION (DAYS)	FREQUENCY (DAYS)	LITTER REMOVAL			MOWING			REMARKS
			CYCLES	AREA		CYCLES	AREA		
				AC/CYCLE	TOTAL (AC)		AC/CYCLE	TOTAL (AC)	
1	42	30	1	8.7	8.7	1	8.7	8.7	
2	98	30	3	7.3	21.9	3	7.3	21.9	
3	114	30	4	5.8	23.2	4	5.8	23.2	
4	68	30	2	5.8	11.6	2	5.8	11.6	
			TOTAL	P	65.4	TOTAL	P	65.4	
				F			F		

EXHIBIT SQ-5
Date: 1/1/10

REVISIONS				STATE OF FLORIDA DEPARTMENT OF TRANSPORTATION			SUMMARY OF QUANTITIES	SHEET NO.
DATE	DESCRIPTION	DATE	DESCRIPTION	ROAD NO.	COUNTY	FINANCIAL PROJECT ID		
				10	LEON	123456-1-52-01		

#USER# #DATE# #TIME# #FILE#

GENERAL NOTES

- The Contractor may use any of the optional pipe materials tabulated for a given structure. Only the material options tabulated for a given structure can be used.
- Adjustment to the bid quantities, prices and payment will not be allowed due to increase or decrease in structure size, shape, length, width, depth or accessory construction necessary to accommodate the use of an optional pipe material other than the "plotted" option. Likewise there will be no added or reduced compensation for structure alterations required to relieve utility conflicts which arise from the use of an optional material other than the "plotted" option.
- Adjustment to the bid quantities, prices and payment will not be allowed due to increased or decreased excavation, bedding, borrow, backfilling, compaction, special installation requirements or disposal of excess materials due to use of any of the pipe optional materials. Likewise, adjustment in the quantities, prices and payment will not be allowed due to differences in end treatment size or types, pipe length, alternate jointing and connecting materials, saddles, cradles, filter fabrics, shoring or similar features due to the use of an optional material other than the "plotted" option.
- If adjustments are required due to plan errors or omissions or authorized field changes, the "plotted" material and not the material elected by the Contractor would be used to establish new pay quantities.
- The Contractor shall notify the Department in writing as to which optional pipe materials he chooses to use at the preconstruction conference. Once identified the Contractor may not change pipe material selected without the approval of the Engineer.
- Pipe shapes other than round (Elliptical/Arch) are summarized and paid for using equivalent round pipe diameter.

THIS EXAMPLE SHOULD BE USED WHEN PIPE FLOW LINES, AND/OR SIZES FOR INDIVIDUAL OPTIONS ARE NOT THE SAME (SEE STRUCTURE NO. 14) OR WHEN NUMEROUS EXCEPTIONS OCCUR.

STR. NO.	DSL YEARS	SIZE (Inches)	PLOTTED	MATERIAL & THICKNESS	FL	FL	AS BUILT	REMARKS
1	100	18	X	RCP CLASS II				
2	100	18	X	RCP CLASS II				
3	100	15	X	RCP CLASS II SRAP	7.0			
4	100	36	X	RCP CLASS II SRSP, 12 GA. SRAP, 12 GA. SRASP, 16 GA.	5.7			
5	100	15	X	RCP CLASS II SRAP	7.7			
6	100	36	X	RCP CLASS II SRSP, 12 GA. SRAP, 12 GA. SRASP, 16 GA.	6.4	5.7		
7	100	36	X	RCP CLASS II	6.5	6.4		
8	100	42	X	RCP CLASS II SRAP SRSP	7.9	7.7		
9	100	30	X	RCP CLASS II SRAP, 16 GA. SRSP, 16 GA.	6.8	6.5		
10	100	18	X	RCP CLASS II SRAP, 16 GA. SRSP, 14 GA. SRASP, 16 GA.	7.6	7.2		
11	100	18	X	RCP CLASS II SRAP, 16 GA. SRSP, 14 GA. SRASP, 16 GA.	8.0	7.6		
12	100	24	X	RCP CLASS III				ENDWALL
13	100	24x38 35x24	X	ERCP CLASS II ASPA, 14 GA.	10.4	10.3		
14	50	30	X	RCP CLASS III SRASP, 14 GA. SRAP, 14 GA. HDPE-1 PVC CAP, 16 GA. CSP, 16 GA. BIT. COATED	6.0	5.9		
14A	50	19x30 28x20	X	ERCP CLASS III ASPA 14 GA.	5.9	5.8		

EXHIBIT SDS-2a
Date: 1/1/09

REVISIONS				STATE OF FLORIDA DEPARTMENT OF TRANSPORTATION			OPTIONAL MATERIALS TABULATION	SHEET NO.
DATE	DESCRIPTION	DATE	DESCRIPTION	ROAD NO.	COUNTY	FINANCIAL PROJECT ID		
				10	LEON	123456-1-52-01		



CURVE DATA CLCONST2
 P1 STA. = 128+57.10
 DELTA = 5° 55' 58" (LT)
 D = 0° 45' 00"
 T = 395.87
 L = 791.02
 R = 7,639.44
 PRC STA. = 124+61.24
 PT STA. = 132+52.26

STA. 131+77.73 @ CONST. =
 STA. 50+30.36 @ N LAUREN PL.
 EQUATION
 PT STA. 132+52.26 @ CONST. BK. =
 STA. 32+50.03 @ SURVEY AHD. =
 STA. 132+50.03 @ CONST. AHD. =

STA. 133+60.02 @ CONST.
 GULF RAILWAY
 CROSSING NO. 620179

STA. 33+60.30 @ SURVEY
 GULF RAILWAY
 CROSSING NO. 620179

STA. 135+11.97 @ CONST. =
 STA. 30+30.00 @ S GABRIEL CT.

STA. 137+59.82 @ CONST. =
 STA. 30+03.39 @ JULIA AVE.
 RELOCATION

END PROJECT 123456-1-52-01
 STA. 154+85.00
 BEGIN PROJECT 123457-1-52-01

STA. 153+89.25 @ CONST. =
 STA. 30+30.00 @ N LILA AVE.

STA. 144+93.41 @ CONST. =
 STA. 30+30.00 @ N RAEA AVE.

STA. 44+93.82 @ SURVEY =
 STA. 30+00.00 @ N RAEA AVE.

STA. 44+46.95 @ SURVEY =
 STA. 30+00.00 @ S RAEA AVE.

STA. 53+89.36 @ SURVEY =
 STA. 30+00.00 @ N LILA AVE.

STA. 31+75.74 @ SURVEY =
 STA. 50+00.00 @ N LAUREN PL.

STA. 144+47.77 @ CONST. =
 STA. 30+30.01 @ S RAEA AVE.

STA. 37+66.86 @ CONST. =
 STA. 29+72.69 @ JULIA AVE.

STA. 36+29.44 @ SURVEY =
 STA. 20+00.00 @ SURVEY
 LATERAL DITCH


CURVE DATA CLCONST
 P1 STA. = 122+51.62
 DELTA = 6° 17' 42" (RT)
 D = 1° 30' 00"
 T = 210.04
 L = 419.65
 R = 3,819.50
 PC STA. = 120+41.58
 PT STA. = 124+61.23

BEGIN PROJECT 123456-1-52-01
 STA. 120+26.44
 END PROJECT 123455-1-52-01

STA. 131+77.36 @ CONST.
 STA. 50+30.36 @ S LAUREN PL.

STA. 125+63.48 @ CONST. =
 STA. 30+61.04 @ DIANE ST.

STA. 119+99.23 @ CONST. =
 STA. 451+67.01 @ CR 70

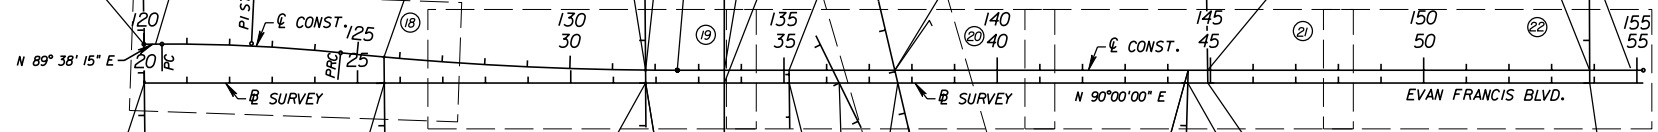

STA. 20+00.05 @ SURVEY =
 STA. 450+75.98 @ CR 70

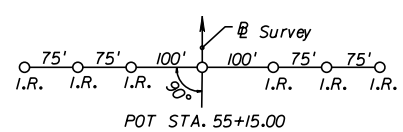
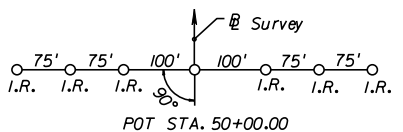
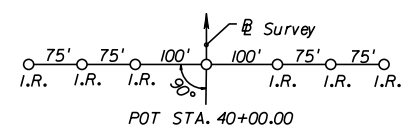
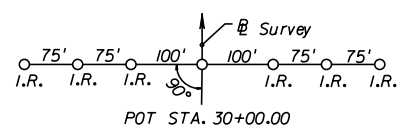
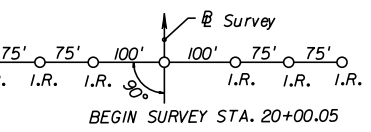


EXHIBIT: EX-PL-1
 Date: 1/1/09

REVISIONS				STATE OF FLORIDA DEPARTMENT OF TRANSPORTATION			PROJECT LAYOUT	SHEET NO.
DATE	DESCRIPTION	DATE	DESCRIPTION	ROAD NO.	COUNTY	FINANCIAL PROJECT ID		
					LEON	123456-1-52-01		

NOTICE: THE OFFICIAL RECORD OF THIS SHEET IS THE ELECTRONIC FILE SIGNED AND SEALED UNDER RULE 68G5-23.003, F.A.C.

GENERAL NOTES

1. BENCHMARK ELEVATIONS SHOWN ON THE PLANS ARE NORTH AMERICAN VERTICAL DATUM OF 1988 (NAVD 88)
2. BUILDINGS TO BE REMOVED BY OTHERS, UNLESS OTHERWISE NOTED.
3. EXISTING DRAINAGE STRUCTURES WITHIN CONSTRUCTION LIMITS SHALL REMAIN UNLESS OTHERWISE NOTED.
4. THE LOCATION(S) OF THE UTILITIES SHOWN IN THE PLANS (INCLUDING THOSE DESIGNATED Vv, Vh, AND Vvh) ARE BASED ON LIMITED INVESTIGATION TECHNIQUES AND SHOULD BE CONSIDERED APPROXIMATE ONLY. THE VERIFIED LOCATIONS/ELEVATIONS APPLY ONLY AT THE POINTS SHOWN. INTERPOLATIONS BETWEEN THESE POINTS HAVE NOT BEEN VERIFIED.
5. EXISTING UTILITIES ARE TO REMAIN IN PLACE UNLESS OTHERWISE NOTED.
6. UTILITY/AGENCY OWNERS:

COMPANY	CONTACT	TELEPHONE NUMBERS
SPRINT/FLORIDA, INC.	CHERYL FLORES	(850) 555-1234
QWEST	JIM WEST	(850) 555-2345
MC I WORLDCOM	ANDY WORLEY	(407) 555-3456
SPRINT COMMUNICATIONS	ROB SPRINTER	(404) 555-4567
CITY OF TALLAHASSEE UTILITIES	CHESTER DIGGER	(850) 555-5678
7. SPECIAL ATTENTION IS DIRECTED TO THE FACT THAT PORTIONS OF SOME DRAINAGE STRUCTURES EXTEND INTO THE STABILIZED PORTION OF THE ROADBED AND EXTREME CAUTION WILL BE NECESSARY IN STABILIZATION OPERATIONS AT THESE LOCATIONS.
8. ALL DRAINAGE STRUCTURES HAVE OPTIONAL MATERIALS. THE OPTIONAL MATERIALS TABULATION SHEET(S) SHOWS ALL MATERIALS ALLOWED AS WELL AS INDICATING WHICH MATERIAL IS PLOTTED ON THESE SHEETS AND USED AS THE BASIS FOR PAY QUANTITIES.
9. ANY PUBLIC LAND CORNER WITHIN THE LIMITS OF CONSTRUCTION IS TO BE PROTECTED. IF A CORNER MONUMENT IS IN DANGER OF BEING DESTROYED AND HAS NOT BEEN PROPERLY REFERENCED, THE ENGINEER SHOULD NOTIFY THE DISTRICT LOCATION SURVEYOR, WITHOUT DELAY, BY TELEPHONE.
10. EXISTING DRIVEWAYS WITHIN THE LIMITS OF THIS PROJECT ARE TO BE REPLACED AT THE SAME LOCATION AND WIDTH, UNLESS OTHERWISE SHOWN IN THE PLANS.

LIST ANY ABBREVIATIONS USED IN THE PLAN SET BUT NOT FOUND IN DESIGN STANDARDS, INDEX 001.


LIST OTHER SPECIAL PROJECT NOTES HERE (NOTES VARY PER DISTRICT)

NOTE: PLAN NOTES ARE INTENDED TO BE USED TO CLARIFY DESIGN DETAIL, CONSTRUCTION PRACTICES OR METHOD FOR PAYMENT. IN GENERAL, PLAN NOTES SHOULD BE KEPT TO A MINIMUM. ONLY THOSE NOTES THAT ARE JOB SPECIFIC SHOULD BE USED. PLAN NOTES SHOULD ONLY BE USED TO DETAIL UNIQUENESS AND NOT TO BROADEN OR CURTAIL REQUIREMENTS IN THE SPECIFICATIONS. NOTES THAT RESTATE THE STANDARD SPECIFICATIONS OR STANDARD INDEXES SHALL NOT BE USED. THIS WILL HELP TO PLACE PROPER EMPHASIS ON THOSE NOTES THAT ARE JOB SPECIFIC AND AVOID DISCREPANCY OF DOCUMENTS.

EXHIBIT GN-1
DATE: 1/1/09



REVISIONS				STATE OF FLORIDA DEPARTMENT OF TRANSPORTATION			GENERAL NOTES	SHEET NO.
DATE	DESCRIPTION	DATE	DESCRIPTION	ROAD NO.	COUNTY	FINANCIAL PROJECT ID		
				10	LEON	123456-1-52-01		

NOTICE: THE OFFICIAL RECORD OF THIS SHEET IS THE ELECTRONIC FILE SIGNED AND SEALED UNDER RULE 6805-23.003, F.A.C.

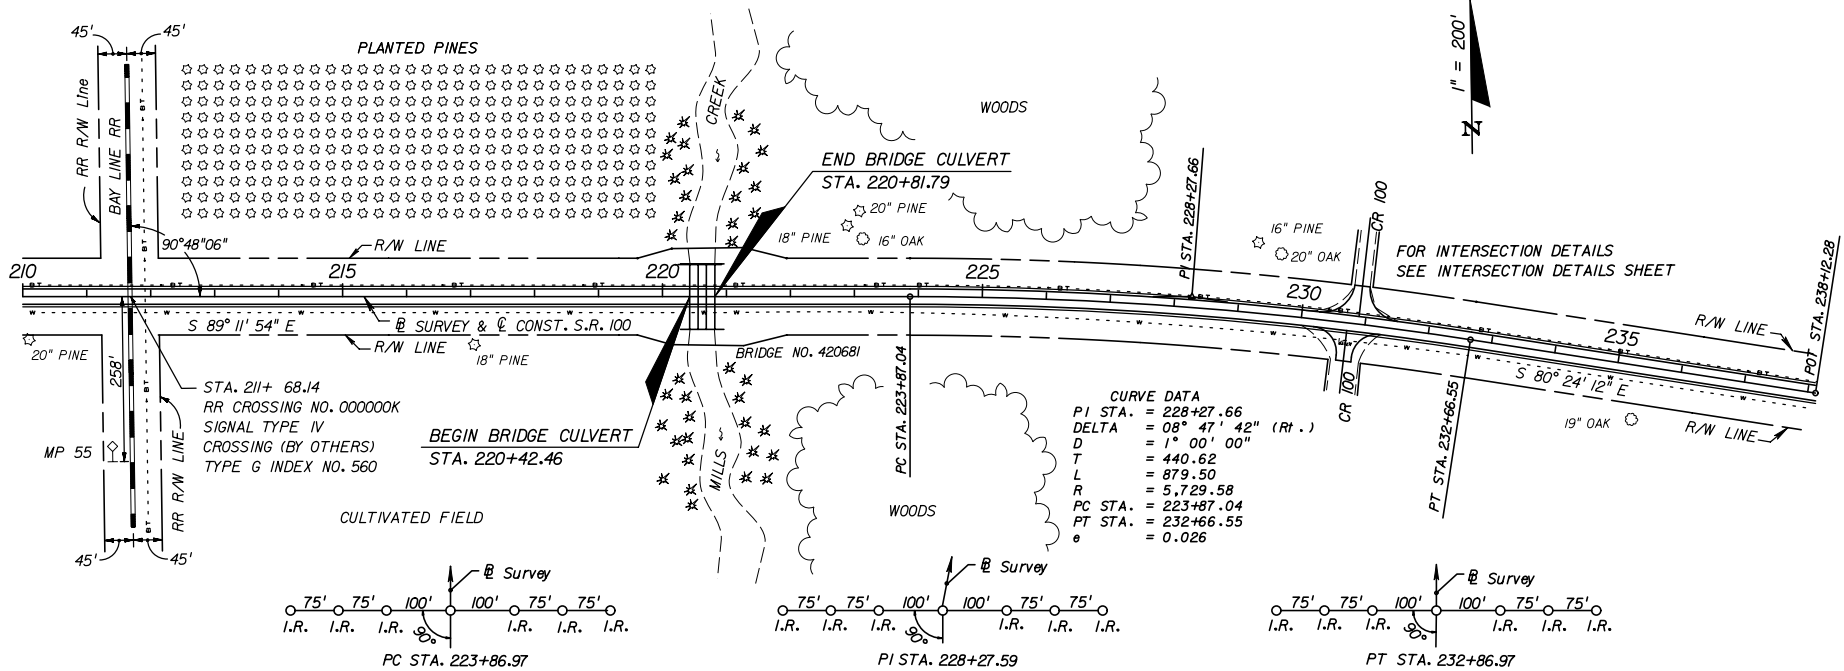

CURVE DATA

PI STA.	= 228+27.66
DELTA	= 08° 47' 42" (Rt.)
D	= 1° 00' 00"
T	= 440.62
L	= 879.50
R	= 5,729.58
PC STA.	= 223+87.04
PT STA.	= 232+66.55
e	= 0.026

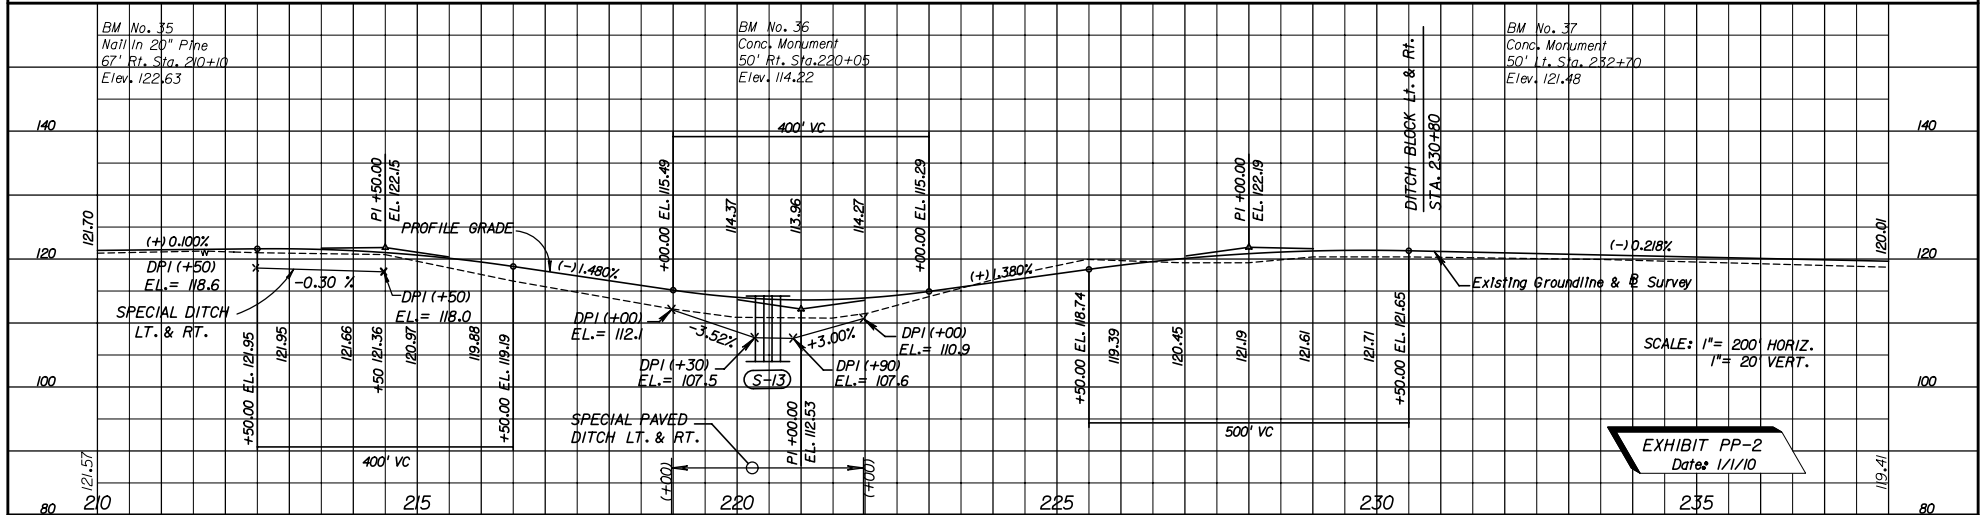 

REVISIONS	
DATE	DESCRIPTION

STATE OF FLORIDA DEPARTMENT OF TRANSPORTATION		
ROAD NO.	COUNTY	FINANCIAL PROJECT ID
10	LEON	123456-1-52-01


ROADWAY PLAN-PROFILE

SHEET NO.

NOTICE: THE OFFICIAL RECORD OF THIS SHEET IS THE ELECTRONIC FILE SIGNED AND SEALED UNDER RULE 68G5-23.003, F.A.C.

EXHIBIT PP-2
Date: 1/1/10

SCALE: 1" = 200' HORIZ.
1" = 20' VERT.

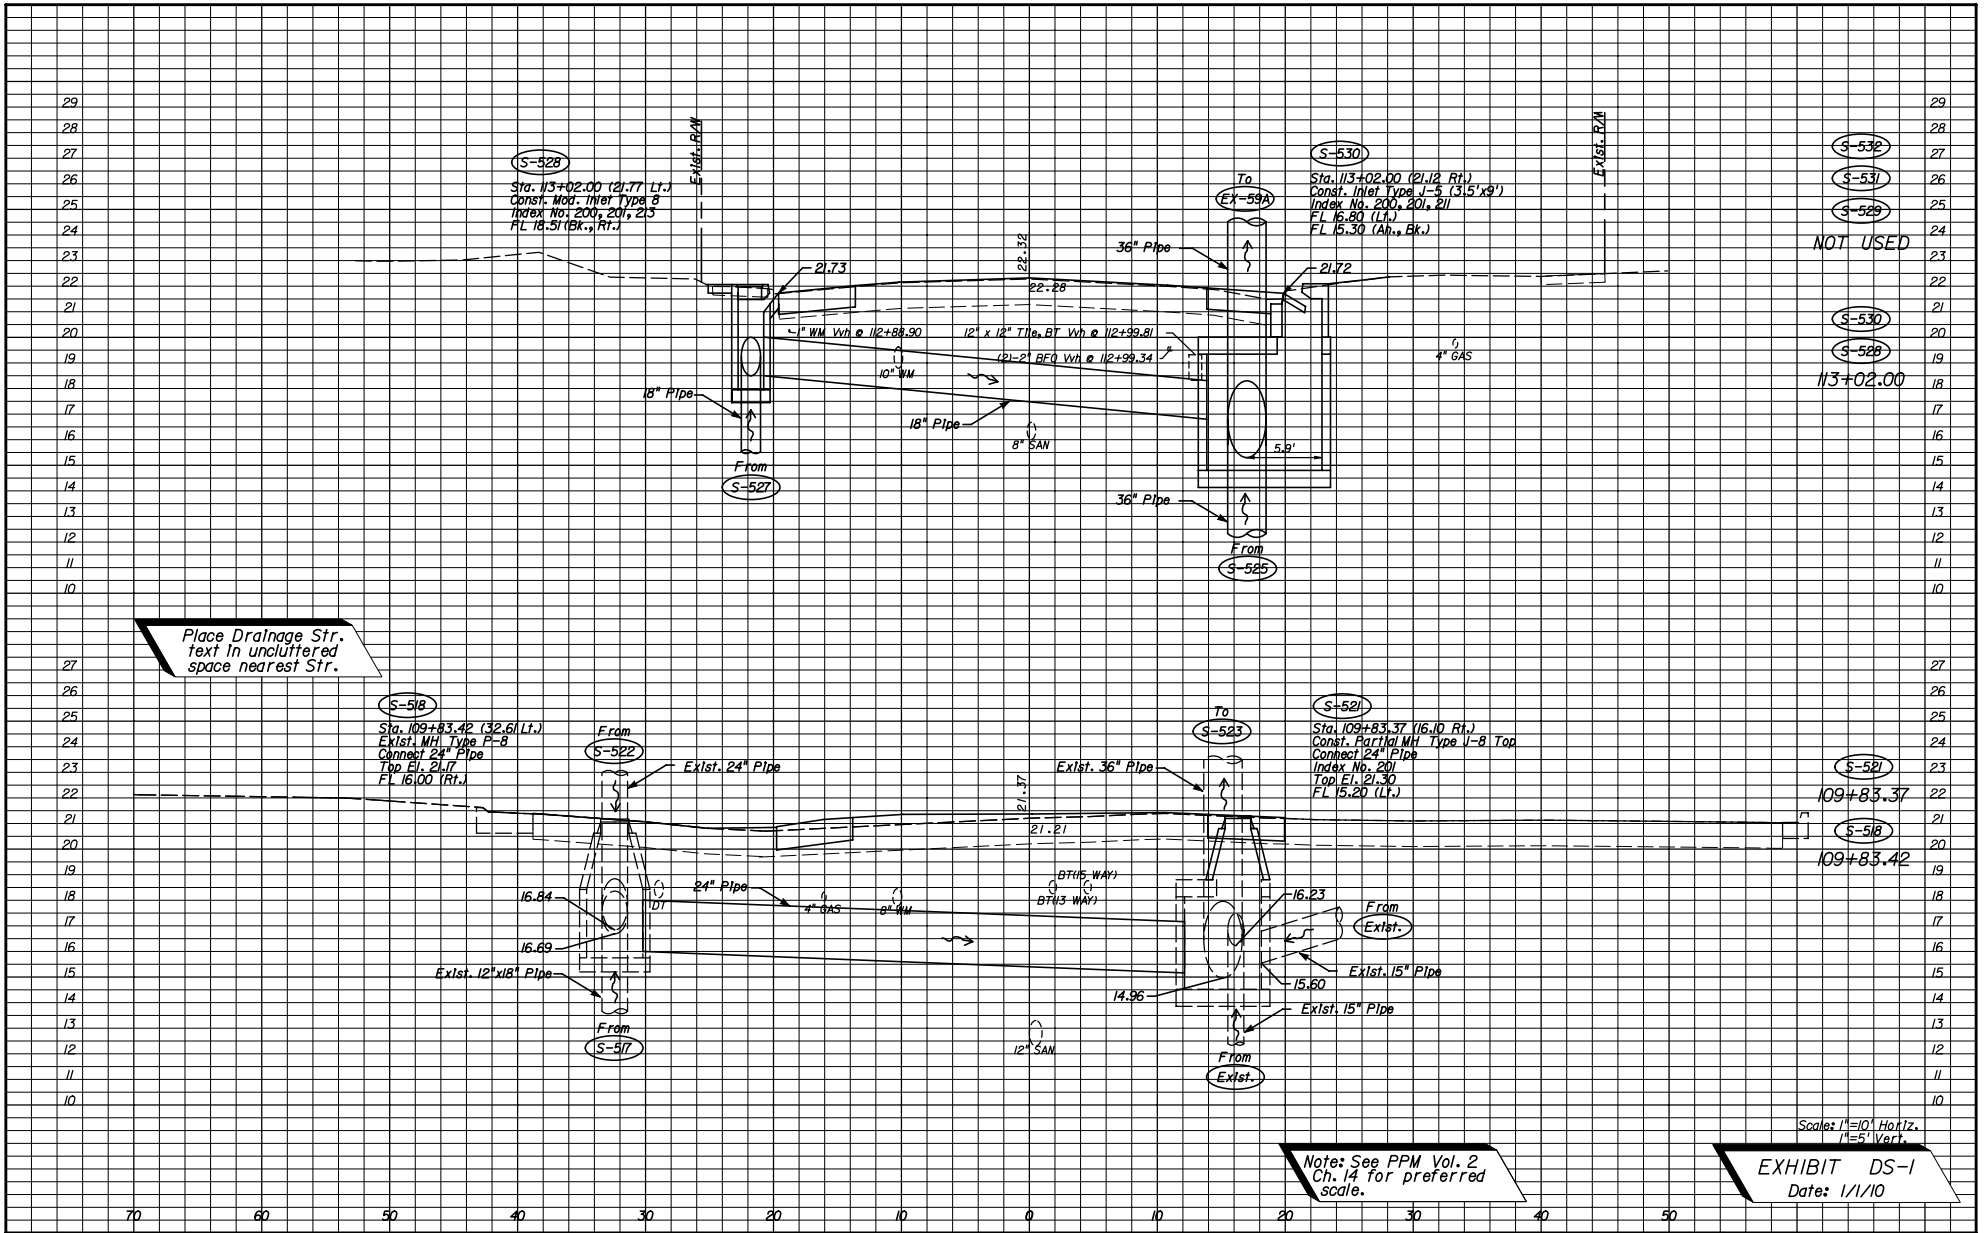

Place Drainage Str. text in uncluttered space nearest Str.


Notes: See PPM Vol. 2 Ch. 14 for preferred scale.

EXHIBIT DS-1
Date: 1/1/10

Scale: 1"=10' Horiz.
1"=5' Vert.

REVISIONS		STATE OF FLORIDA DEPARTMENT OF TRANSPORTATION		FINANCIAL PROJECT ID	DRAINAGE STRUCTURES	SHEET NO.
DATE	DESCRIPTION	DATE	DESCRIPTION			

NOTICE: THE OFFICIAL RECORD OF THIS SHEET IS THE ELECTRONIC FILE SIGNED AND SEALED UNDER RULE 61G05-23.003, F.A.C.

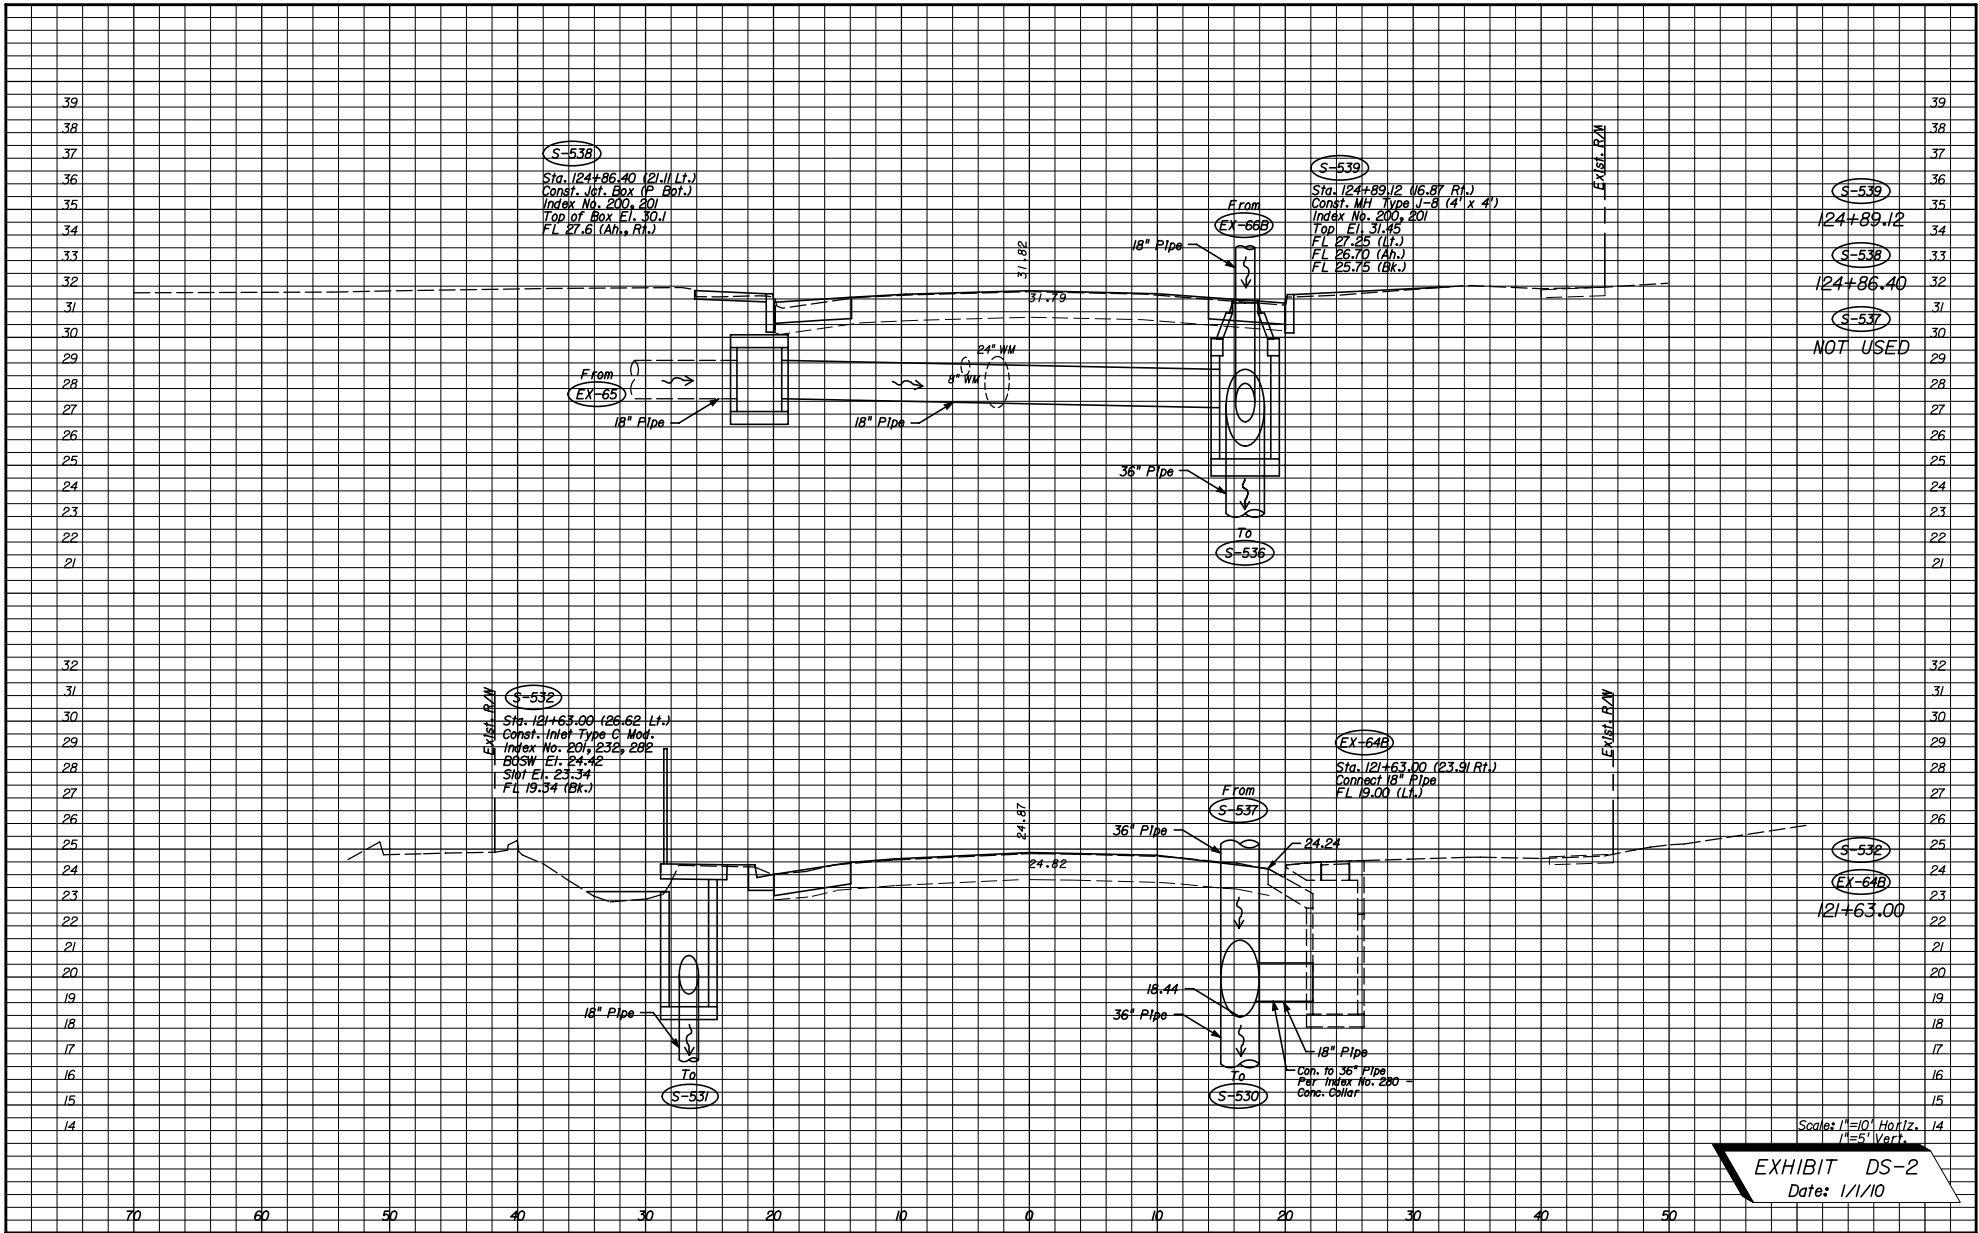


REVISIONS		STATE OF FLORIDA DEPARTMENT OF TRANSPORTATION		FINANCIAL PROJECT ID	DRAINAGE STRUCTURES	SHEET NO.
DATE	DESCRIPTION	DATE	DESCRIPTION			

NOTICE: THE OFFICIAL RECORD OF THIS SHEET IS THE ELECTRONIC FILE SIGNED AND SEALED UNDER RULE 61G05-23.003, F.A.C.


50
49
48
47
46
45
44
43
42
41
40
39
38

50
49
48
47
46
45
44
43
42
41
40
39
38

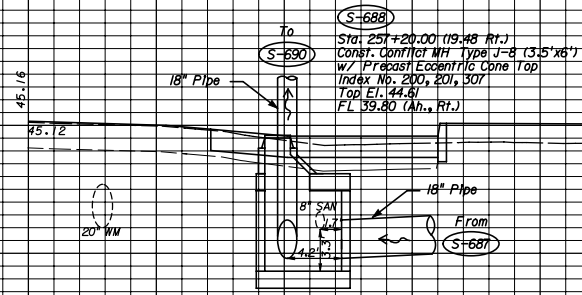

48
47
46
45
44
43
42
41
40
39
38
37
36
35
34
33
32
31

48
47
46
45
44
43
42
41
40
39
38
37
36
35
34
33
32
31

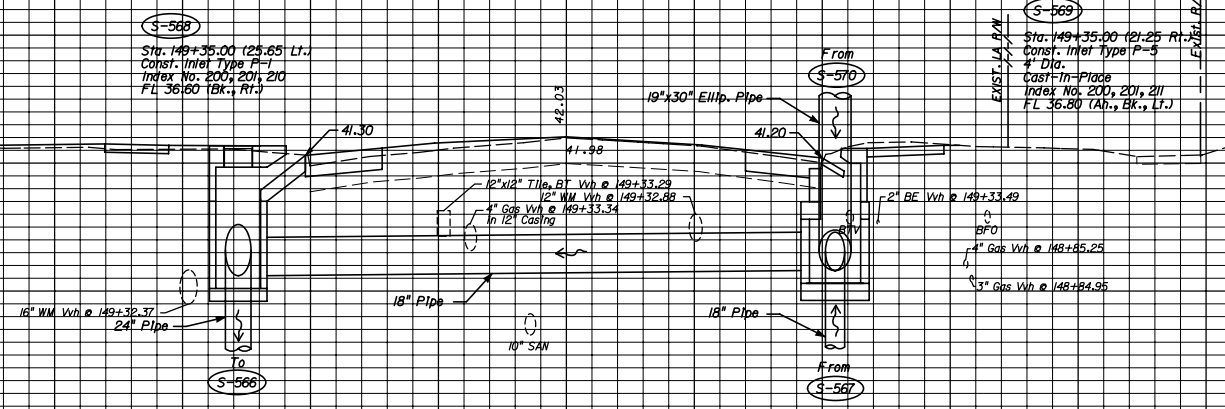

Scale: 1"=10' Horiz.
1"=5' Vert.


EXHIBIT DS-3
Date: 1/1/10

70 60 50 40 30 20 10 0 10 20 30 40 50

REVISIONS		STATE OF FLORIDA DEPARTMENT OF TRANSPORTATION		FINANCIAL PROJECT ID 123456-7-52-01	DRAINAGE STRUCTURES	SHEET NO.
DATE	DESCRIPTION	ROAD NO.	COUNTY			
		10	LEON			

#USER# #DATE# #TIME# #FILE#

NOTICE: THE OFFICIAL RECORD OF THIS SHEET IS THE ELECTRONIC FILE SIGNED AND SEALED UNDER RULE 61G05-23.003, F.A.C.

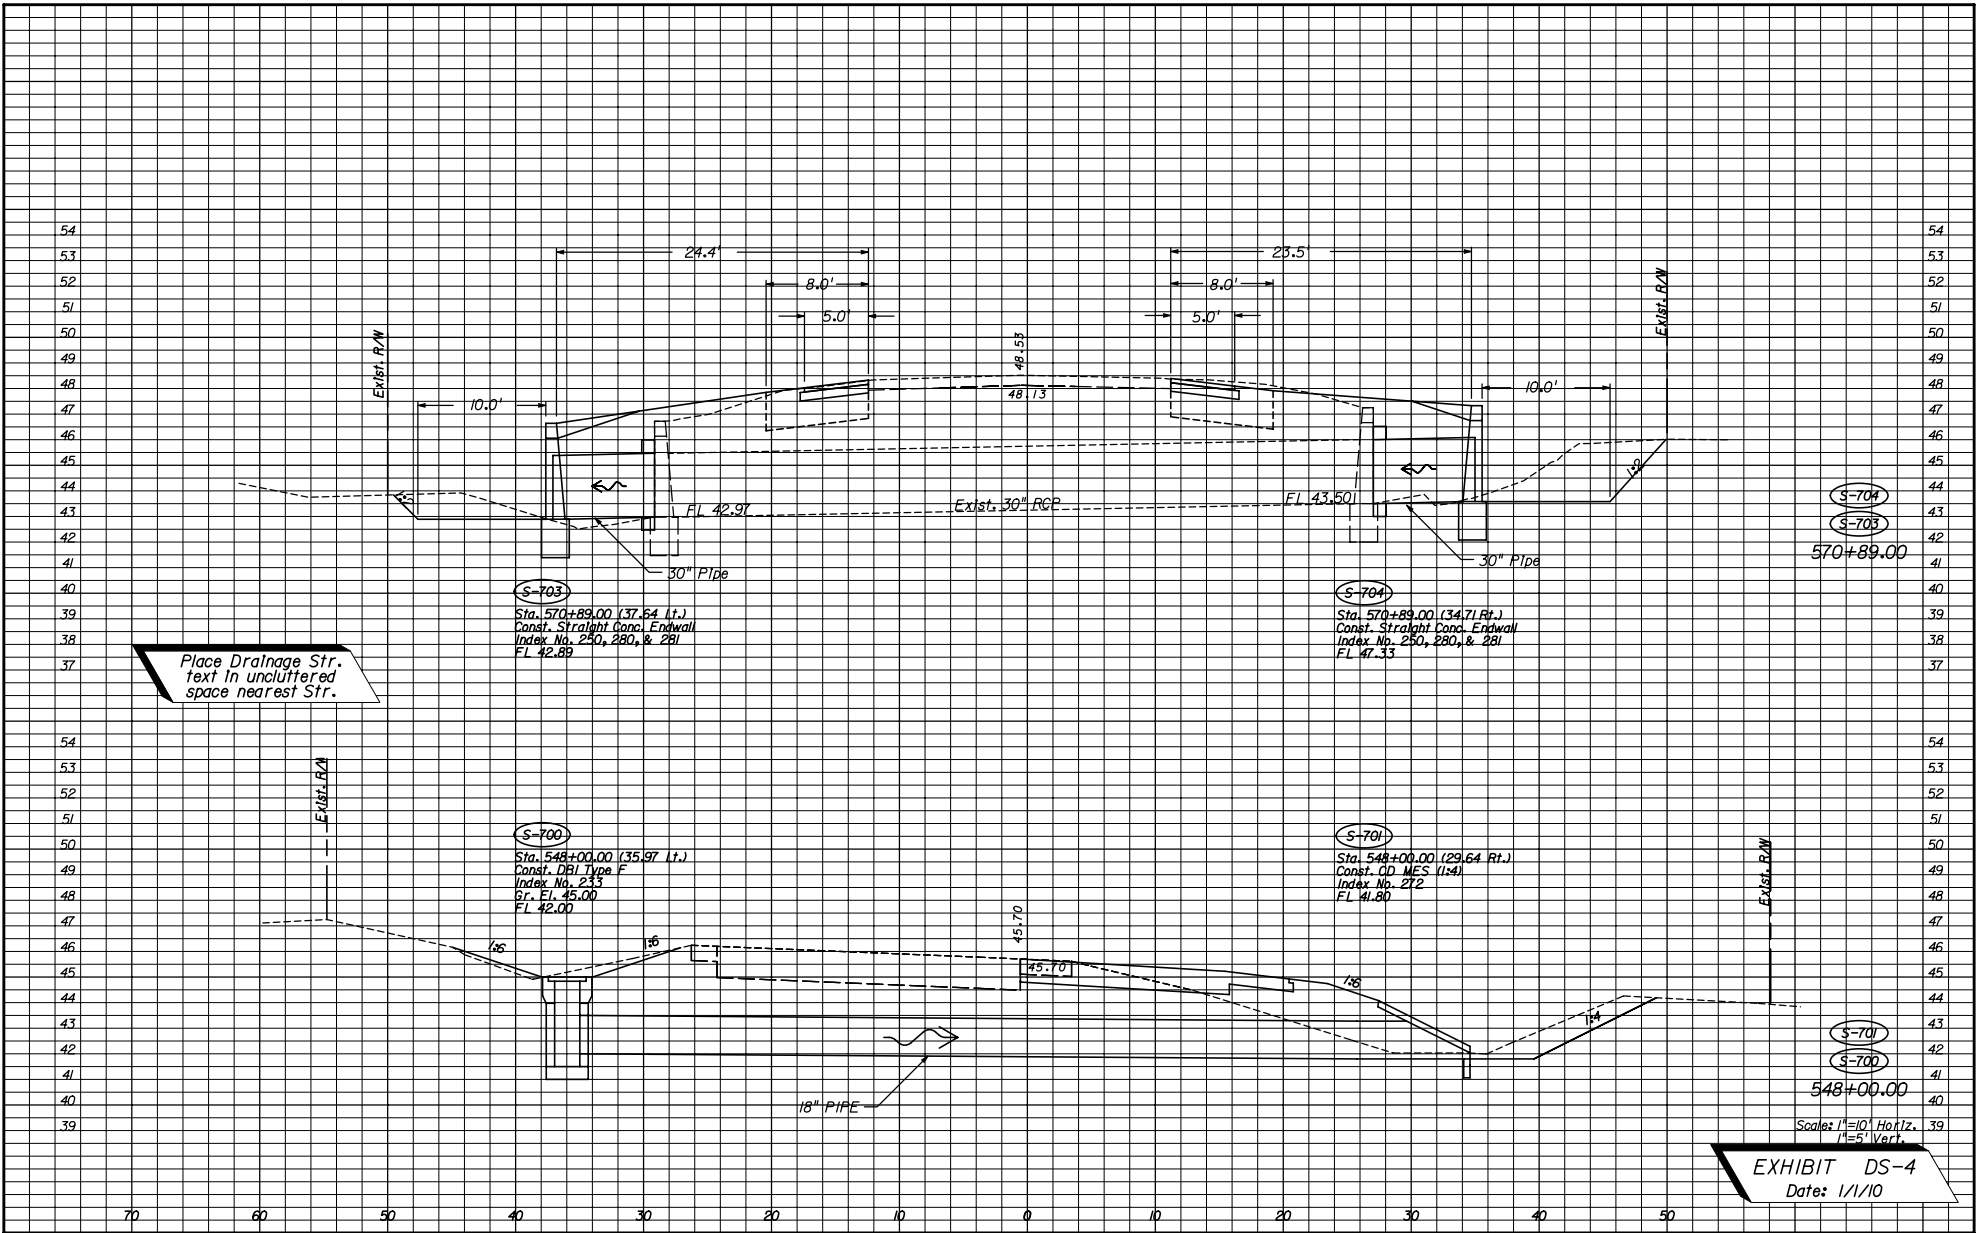

Place Drainage Str. text in uncluttered space nearest Str.

(S-703)
Sta. 570+89.00 (37.64 Ft.)
Const. Straight Conc. Endwall
Index No. 250, 280, & 281
FL 42.89

(S-704)
Sta. 570+89.00 (34.71 Ft.)
Const. Straight Conc. Endwall
Index No. 250, 280, & 281
FL 47.33

(S-700)
Sta. 548+00.00 (35.97 Ft.)
Const. DBI Type F
Index No. 233
Gr. El. 45.00
FL 42.00


(S-701)
Sta. 548+00.00 (29.64 Ft.)
Const. OD MES (1:4)
Index No. 272
FL 41.80

EXHIBIT DS-4
Date: 1/1/10

Scale: 1"=10' Hor/12"
1"=5' Vert.

REVISIONS		STATE OF FLORIDA DEPARTMENT OF TRANSPORTATION		SHEET NO.
DATE	DESCRIPTION	ROAD NO.	COUNTY	
		10	LEON	
			FINANCIAL PROJECT ID	
			123456-7-52-01	
DRAINAGE STRUCTURES				

NOTICE: THE OFFICIAL RECORD OF THIS SHEET IS THE ELECTRONIC FILE SIGNED AND SEALED UNDER RULE 61G05-23.003, F.A.C.

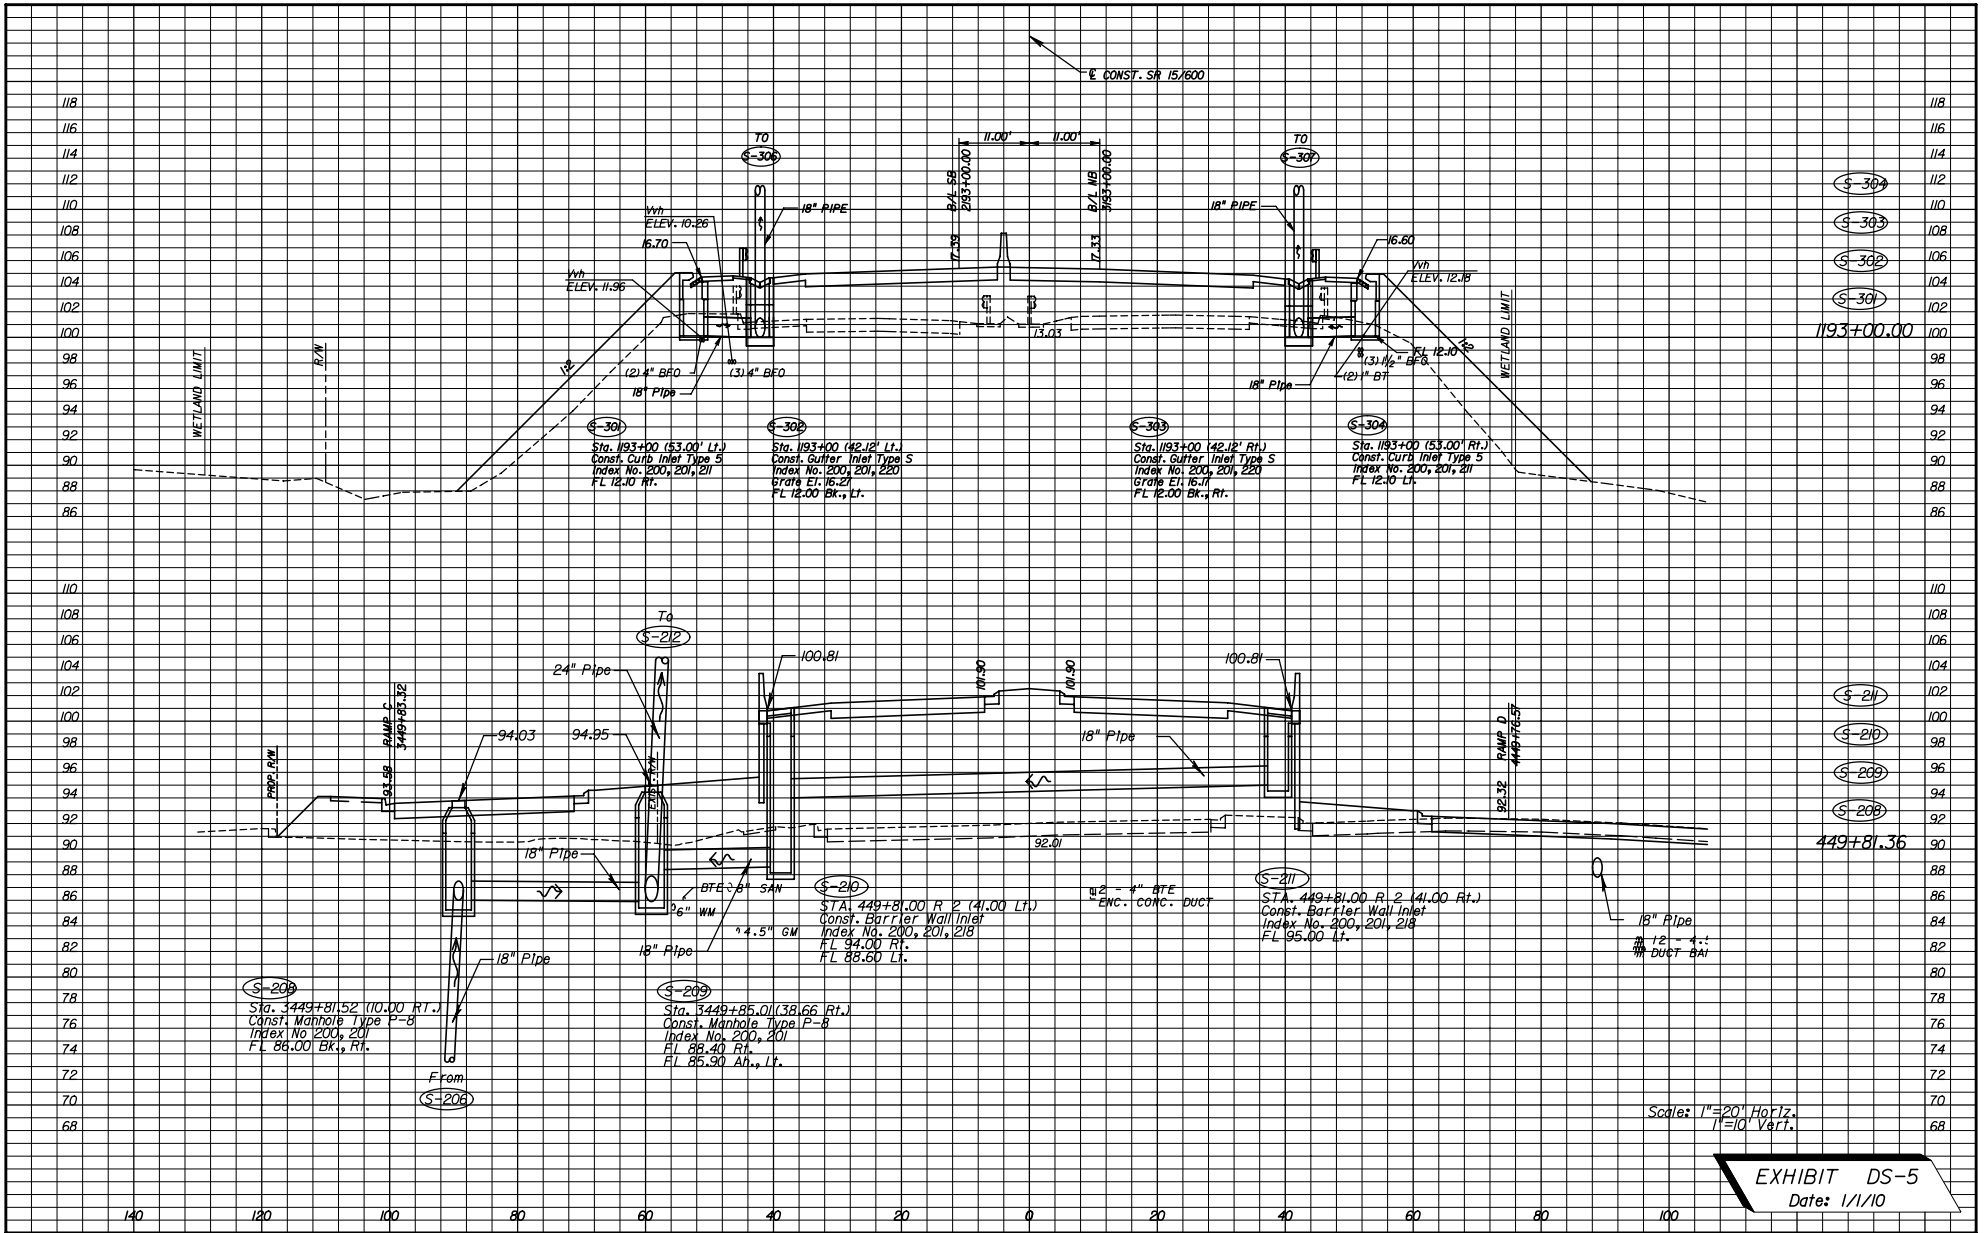


REVISIONS		STATE OF FLORIDA DEPARTMENT OF TRANSPORTATION		SHEET NO.
DATE	DESCRIPTION	DATE	DESCRIPTION	


ROAD NO.	COUNTY	FINANCIAL PROJECT ID
10	LEON	123456-7-52-01

NOTICE: THE OFFICIAL RECORD OF THIS SHEET IS THE ELECTRONIC FILE SIGNED AND SEALED UNDER RULE 6905-23.003, F.A.C.

 SELECTIVE CLEARING AND GRUBBING - GENERAL NOTES



 DESIGNATES AREAS TO REMAIN NATURAL. NO CLEARING OR GRUBBING IN THESE AREAS. NO EQUIPMENT SHALL ENTER THESE AREAS. NO STAGING, STORAGE OR DUMPING IN THIS AREA.




DESIGNATES AREAS WHERE TREES AND STUMPS OVER 3" IN DIAMETER SHALL BE CUT FLUSH WITH THE GROUND OR REMOVED, AND ALL UNDERGROWTH IS TO REMAIN NATURAL. NO EQUIPMENT SHALL ENTER THESE AREAS THAT WOULD IN ANY WAY DAMAGE THE PLANT MATERIAL TO REMAIN. NO STAGING, STORAGE, OR DUMPING IN THIS AREA.



DESIGNATES AREAS WHERE TREES OF 3" IN DIAMETER OR GREATER ARE TO REMAIN AND ALL UNDERGROWTH IS TO BE REMOVED. ONLY RUBBER TIRE EQUIPMENT SHALL ENTER THESE AREAS, AND REMAINING TREES SHALL BE PROTECTED FROM ROOT AND TRUNK DAMAGE. NO STAGING, STORAGE, OR DUMPING IN THIS AREA.



 DESIGNATES AREAS WHERE THE TYPE AND EXTENT OF CLEARING AND GRUBBING SHALL BE DETERMINED BY THE ENGINEER ACCORDING TO FIELD CONDITIONS.



DESIGNATES AREAS THAT SHALL REMAIN NATURAL WHEN, IN THE OPINION OF THE ENGINEER, ADEQUATE AND DESIRABLE NATURAL VEGETATION OR GRASS EXIST. WHERE THIS TYPE VEGETATION DOES NOT EXIST, ONLY HARROWING, DISKING, LEVELING, AND/OR CLEAN-UP SHALL BE UNDERTAKEN, TO A DEGREE SUFFICIENT TO PREPARE THE AREA FOR GRASSING OPERATIONS.

AREAS WHERE EQUIPMENT IS NOT ALLOWED AND OTHER LOCATIONS, AS DIRECTED BY THE ENGINEER, THAT MUST BE PROTECTED BY TREE GUARDS. THE LOCATION FOR TREE GUARDS SHALL BE SHOWN IN THE PLANS.

ALL OTHER AREAS NOT INCLUDED IN ONE OF THE ABOVE CATEGORIES, OR THOSE DESIGNATED BY THE TYPICAL SECTIONS, SHALL BE STANDARD CLEARING AND GRUBBING.

 
WHERE UNFORESEEN SITE CONDITIONS EXIST, ADJUSTMENTS OR EXCEPTIONS MAY BE MADE TO THE ABOVE PROCEDURE AT THE DIRECTION OF THE ENGINEER.

FINISH SOIL LAYER - GENERAL NOTES

STOCKPILING OF FINISH SOIL LAYER MATERIAL IS TO BE DONE ONLY IN AREAS REQUIRING STANDARD CLEARING AND GRUBBING AND/OR AREAS DESIGNATED AS TYPE 5 (SEE SELECTIVE CLEARING AND GRUBBING - GENERAL NOTES).


TYPE 4 AREAS MAY BE USED FOR STOCKPILING OF FINISH SOIL LAYER MATERIAL ONLY WHERE SUCH AREAS HAVE BEEN CLEARED, AT THE DIRECTION OF THE ENGINEER DURING CONSTRUCTION OPERATIONS.

SUFFICIENT AREA HAS BEEN DESIGNATED SO THAT ALL STOCKPILING MAY BE DONE IN ACCORDANCE WITH THE REQUIREMENTS LISTED ABOVE.



SOIL INFORMATION DETAIL

EXPLANATION OF SYMBOLS & SOIL TEXTURE ABBREVIATIONS

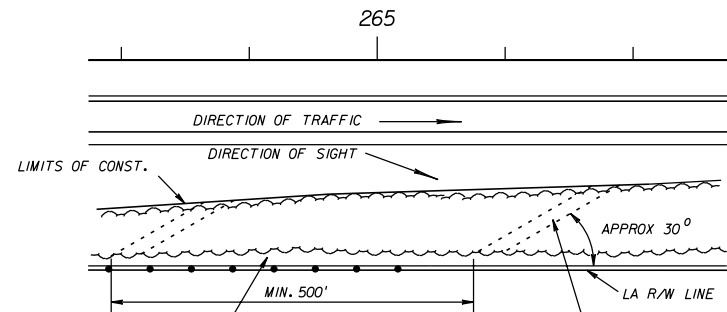

10' STRIP WHICH MAY BE CLEARED FOR FENCE CONSTRUCTION WITH SELECTED DESIRABLE TREES ALLOWED TO REMAIN, AS DIRECTED BY THE ENGINEER.

AT THE DIRECTION OF THE ENGINEER, DIAGONAL PATH MAY BE CUT IN AREAS TO REMAIN NATURAL, AS SHOWN ABOVE, FOR THE REMOVAL OF TIMBER AND STUMPS FROM THE AREA CLEARED FOR FENCE CONSTRUCTION.

ACCESS FOR FENCE CONSTRUCTION

(APPLIES TO ALL TYPES OF SELECTIVE CLEARING AND GRUBBING)

EXHIBIT SCG-1
Date: 1/1/09

REVISIONS				STATE OF FLORIDA DEPARTMENT OF TRANSPORTATION			SELECTIVE CLEARING AND GRUBBING	SHEET NO.
DATE	DESCRIPTION	DATE	DESCRIPTION	ROAD NO.	COUNTY	FINANCIAL PROJECT ID		
				10	LEON	123456-1-52-01		

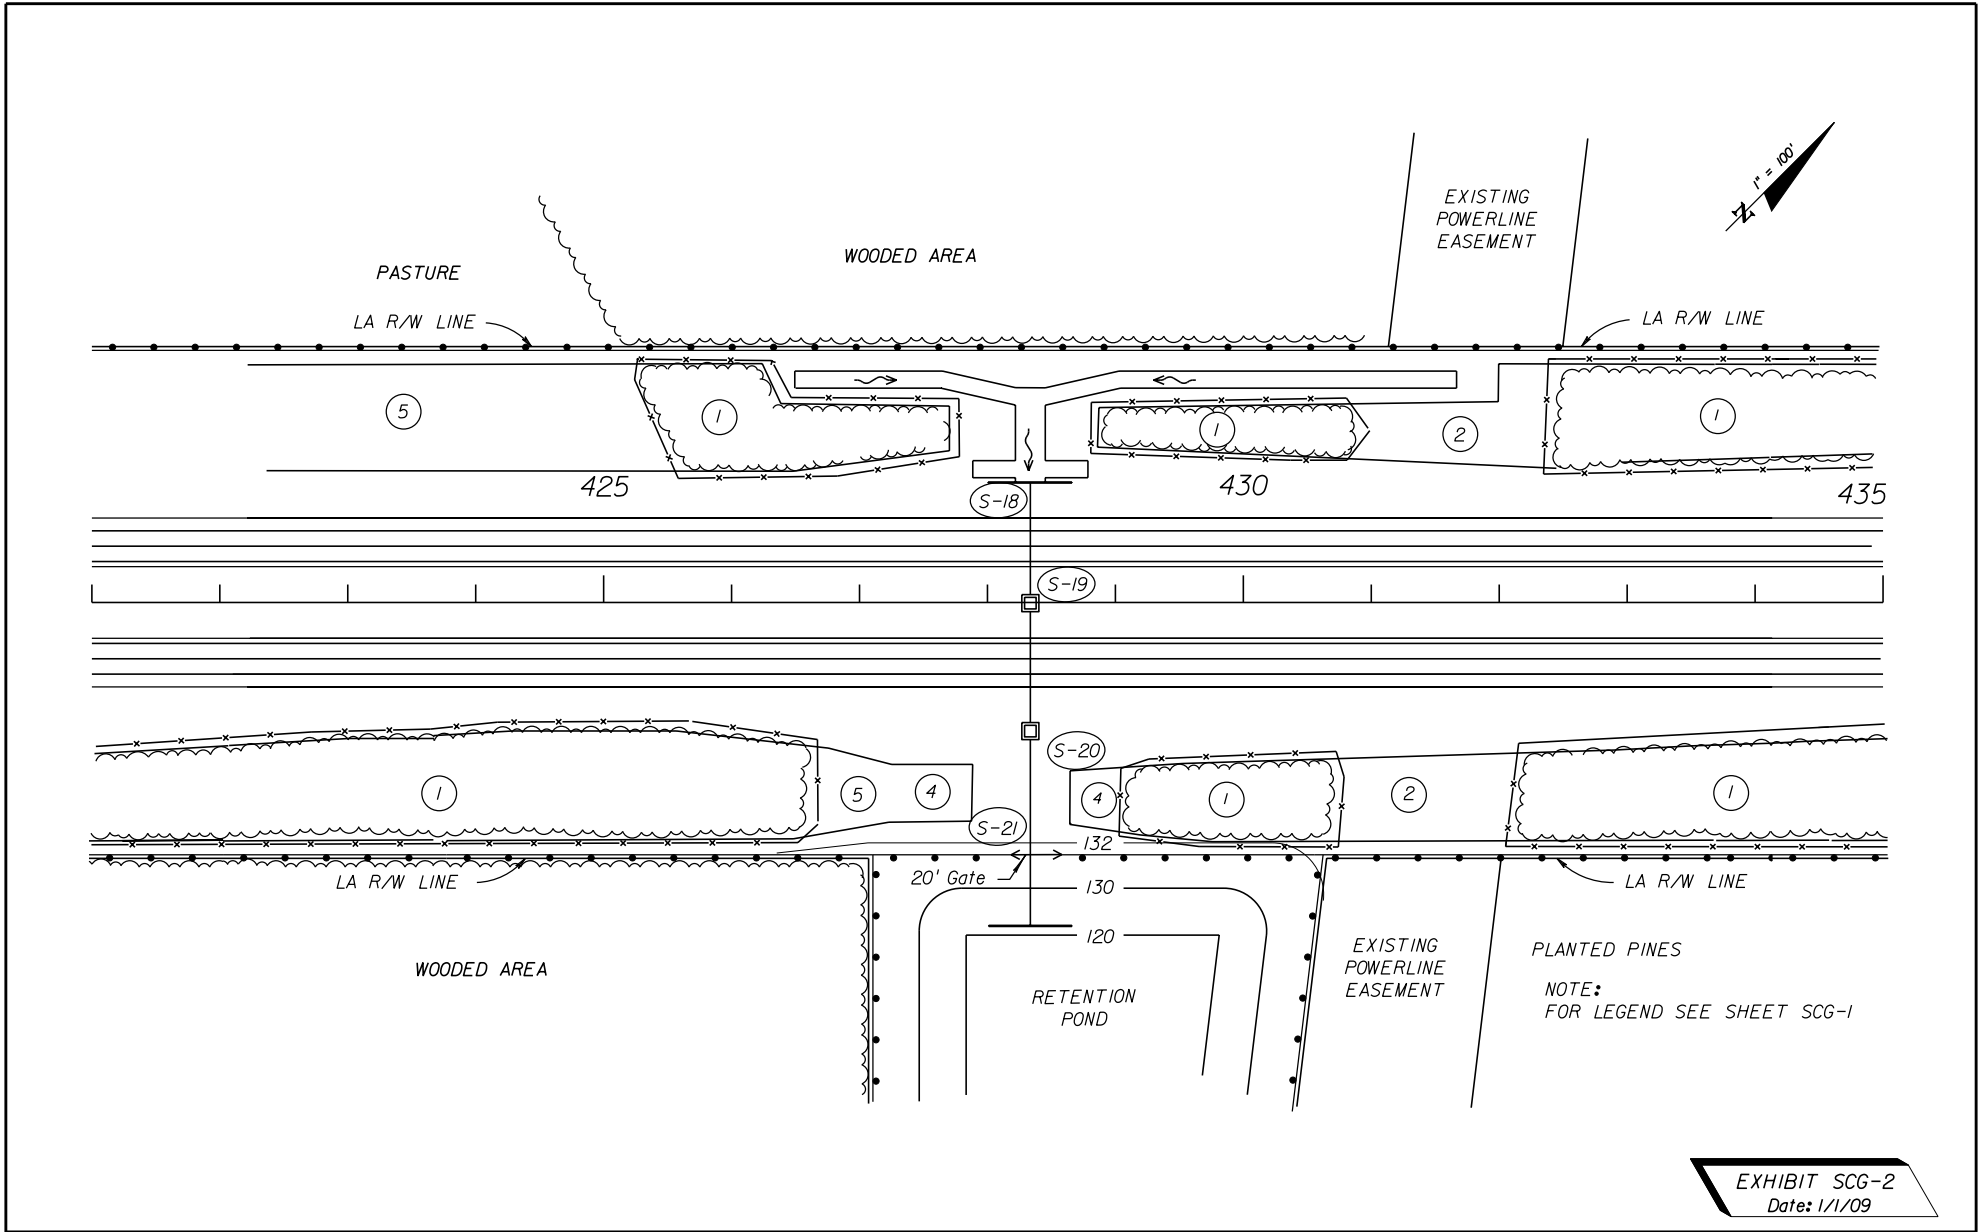


EXHIBIT SCG-2
Date: 1/1/09

REVISIONS				STATE OF FLORIDA DEPARTMENT OF TRANSPORTATION	ROAD NO.	COUNTY	FINANCIAL PROJECT ID	SHEET NO.
DATE	DESCRIPTION	DATE	DESCRIPTION					

SELECTIVE CLEARING AND GRUBBING

NOTICE: THE OFFICIAL RECORD OF THIS SHEET IS THE ELECTRONIC FILE SIGNED AND SEALED UNDER RULE 68G5-23.003, F.A.C.

PERMANENT RETAINING WALL SYSTEM DATA TABLES

GEOTECHNICAL INFORMATION						
		Reinforced Soil & Random Backfill	Loose Fine Sand	Firm Fine Sand	Loose Clayey Fine Sand	Firm Clayey Fine Sand
Depth Below Existing Ground Line (ft.)	Wall No. 1 & 2	—	0'-6'	6'-33'	33'-39'	—
	Wall No. 3	—	0'-10'	10'-26'	—	26'-39'
Effective Unit Weight (pcf)		110 (moist weight in-place)	118	118	120	110
Cohesion (psf)		0	0	0	122	122
Internal Friction Angle		30°	30°	32°	0	0

NOTE:
If the unit weight and/or internal friction angle of the fill proposed by the Contractor differs from that shown above, the Project Engineer will contact both the District Geotechnical Engineer and the Wall Designer for a possible redesign.

RETAINING WALL VARIABLES				
Wall No.	Wall Settlement			
	Long Term Settlement (in.)	Short Term Settlement (in.)	Differential Settlement	
			Longitudinal (%) (ft./100ft.)	Transverse (in.)
1 & 2	2" to 3"	1" to 2"	0.50	N/A
3	2" to 3"	1" to 2"	0.50	N/A

NOTE:
Design walls for the settlements noted in the table.
Long term settlement is measured from the end of wall fill placement.
Transverse differential settlement is measured from the face of wall to the end of the soil reinforcement.

SOIL REINFORCEMENT LENGTHS FOR EXTERNAL STABILITY												
Wall No. 1 & 2	Wall Height (ft.)	0-11	12	13-14	15	16-17	18	19-20	21	22-23	24	25
	Reinforcement Length (ft.)	8	9	10	11	12	13	14	15	16	17	18
	Factored Bearing Resistance (psf)	1984	2295	2546	2857	3108	3419	3671	3980	4233	4543	4851
Wall No. 3	Wall Height (ft.)	0-11	12	13-14	15	16-17	18	19-20	—	—	—	—
	Reinforcement Length (ft.)	8	9	10	11	12	13	14	—	—	—	—
	Factored Bearing Resistance (psf)	2467	2467	2467	2467	2467	2467	2467	—	—	—	—

NOTES:
1. The reinforcement strap lengths shown above are the minimum lengths required for external stability. The reinforcement lengths used in the construction of the retaining walls will be the longer of that required for external or internal stability (determined by proprietary wall companies).
2. The Factored Bearing Resistances shown above are the critical (lowest) values from all the load cases analyzed using LRFD methodology.

NOTES:

- Concrete facing panels surfaces treatment will be a fluted, trapezoid, V-groove, fractured rib 3/4" on 1 1/2" centers similar to Burke Form Liner, Pattern No. BG312 (Waterfall).
- If required, the soil reinforcement and fasteners for the abutment back wall will be designed and furnished by proprietary wall company. The soil reinforcement will be designed to resist a factored horizontal load of 3.5 kips/ft of back wall width. The cost of soil reinforcement and fasteners will be included in the cost of the retaining wall system.
- Applicable FDOT Wall Types for each wall location are listed below. See the Qualified Products List for approved wall systems and the Table of FDOT Wall Types on Index No. 5300 of the Design Standards for allowable wall type substitutions.

Wall No. 1, 2 & 3 - FDOT Wall Type 2B


4. See Design Standards Index No. 5300 for General Notes And Details.

5. Longitudinal dimensions shown in the plans are measured along the exterior face of the wall. Elevations shown are to the top of coping, top of leveling pad or top of wall footing.

Note: Use CADD Cell "05300".
Work this cell with Design Standards, Index No. 5300.

EXHIBIT CP-1
Date: 1/1/10

REVISIONS						DRAWN BY:			SHEET TITLE:			REF. DWG. NO.	
DATE	BY	DESCRIPTION	DATE	BY	DESCRIPTION	XXX MM-YY	XXX MM-YY	XXX MM-YY	STATE OF FLORIDA DEPARTMENT OF TRANSPORTATION			PERMANENT MSE WALL DATA TABLES AND NOTES	
									ROAD NO.	COUNTY	FINANCIAL PROJECT ID	PROJECT NAME:	SHEET NO.

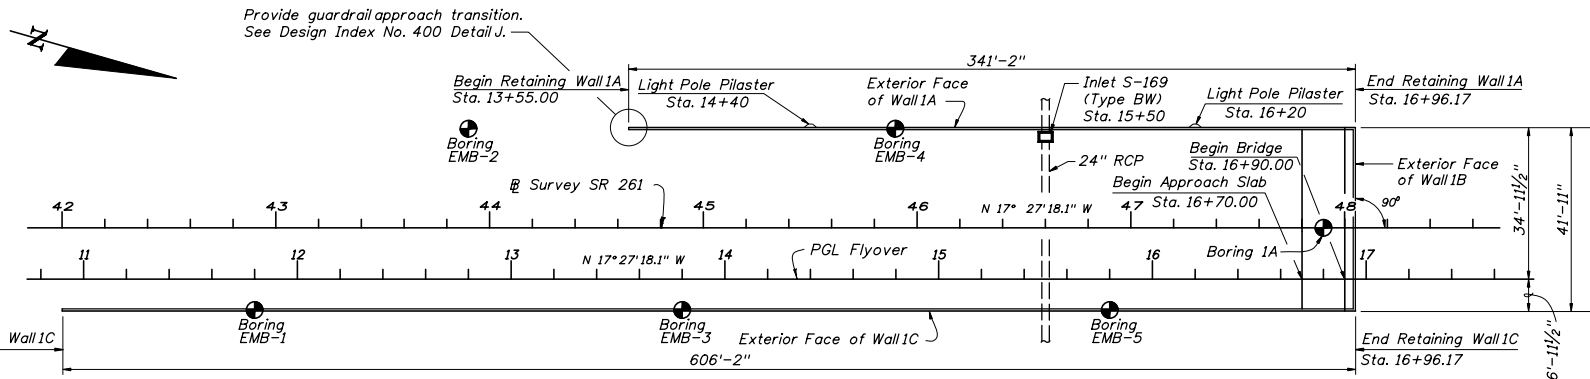

NOTES:

1. For Top of Coping Elevations see sheet BW-6.
2. Top of Leveling Pad shall be a minimum of 2'-0" below Proposed Ground Line.
3. Provide 3/4" open joints in Traffic Railing at a maximum of 90 ft. intervals.
4. ● indicates Soil Boring. See Sheets B-8 thru B-12a for boring data.
5. For Additional Information regarding Drainage Structures and Utility Locations, See Roadway Plans.



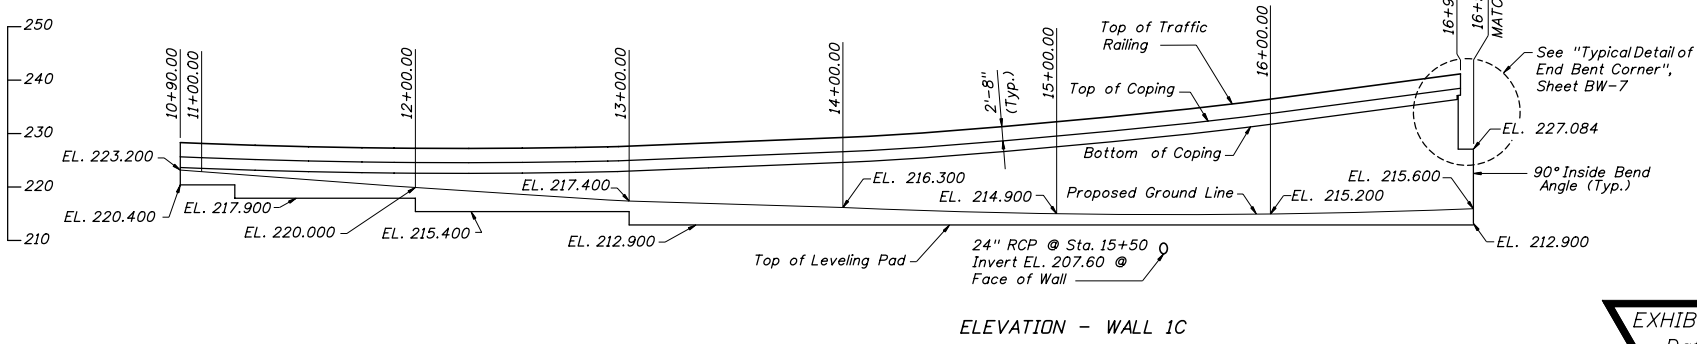


EXHIBIT CP-2
Date: 1/1/10

REVISIONS						DRAWN BY:			SHEET TITLE:			REF. DWG. NO.
DATE	BY	DESCRIPTION	DATE	BY	DESCRIPTION	XXX MM-YY	XXX MM-YY	STATE OF FLORIDA DEPARTMENT OF TRANSPORTATION			MSE WALL NO. 1 CONTROL DRAWING	
						XXX MM-YY	XXX MM-YY	ROAD NO.	COUNTY	FINANCIAL PROJECT ID	PROJECT NAME:	SHEET NO.
						XXX MM-YY	XXX MM-YY					
						XXX MM-YY	XXX MM-YY					

NOTICE: THE OFFICIAL RECORD OF THIS SHEET IS THE ELECTRONIC FILE SIGNED AND SEALED UNDER RULE 61G15-23.003, F.A.C.

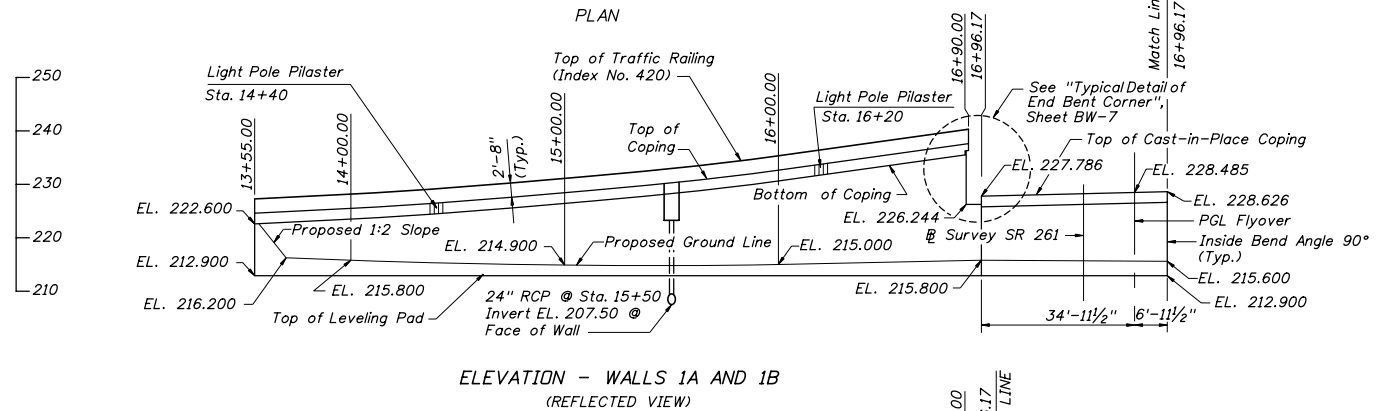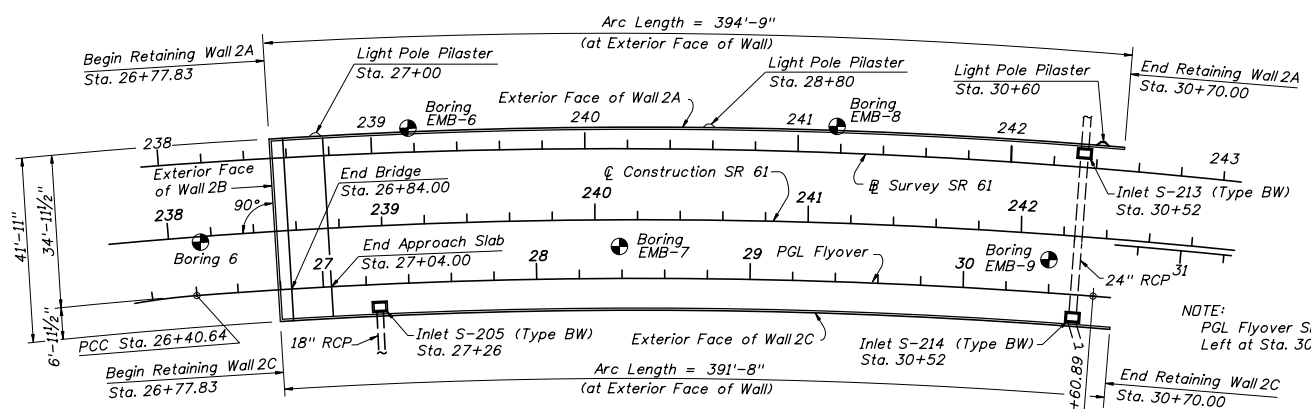


HORIZONTAL CURVE DATA

PI Sta. = 28+50.87
 $\Delta = 4^{\circ}28'13''$ Rt.
 $D = 1^{\circ}02'54''$
 $T = 210.23'$
 $L = 420.25'$
 $R = 5,386.25'$
PCC Sta. = 26+40.64
PT Sta. = 30+60.89

NOTE:
PGL Flyover Shifts 12'-0"
Left at Sta. 30+69.23


PLAN

250
240
230
220
210

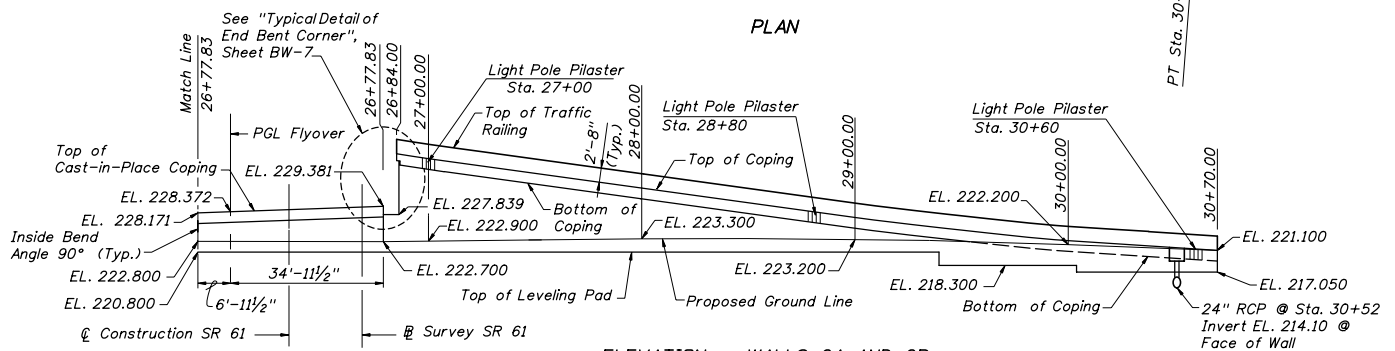

**ELEVATION - WALLS 2A AND 2B
(REFLECTED VIEW)**

250
240
230
220
210

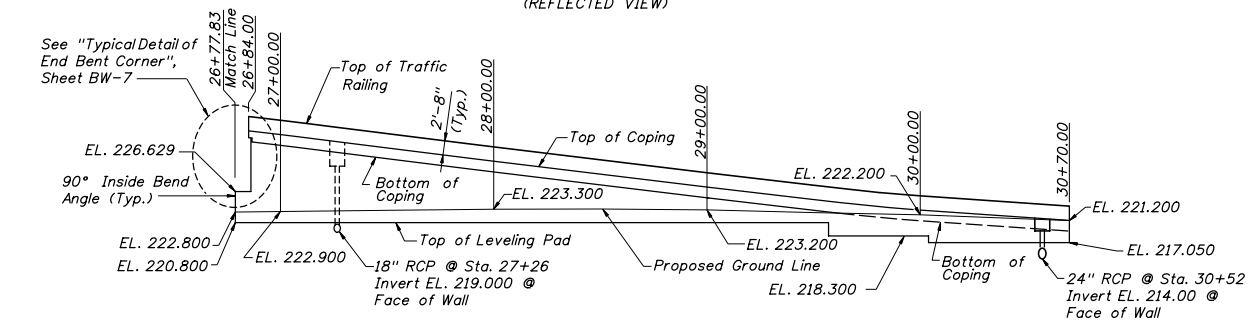

ELEVATION - WALL 2C

STATE PLANE COORDINATES

	N	E
PCC		
PI		(Not Available)
PT		

- NOTES:**
- For Top of Coping Elevations see sheet BW-4.
 - Top of Leveling Pad shall be a minimum of 2'-0" below Proposed Ground Line.
 - Provide $\frac{3}{4}$ " open joints in Traffic Railing at a maximum of 90 ft. intervals.
 - ⊙ indicates Soil Boring. See Sheets B-8 thru B-12a for boring data.
 - For Additional Information regarding Drainage Structures and Utility Locations, See Roadway Plans.

EXHIBIT CP-3
Date: 1/1/10

REVISIONS				DRAWN BY:			SHEET TITLE:			REF. DWG. NO.
DATE	BY	DESCRIPTION	DATE	BY	DESCRIPTION	XXX MM-YY	STATE OF FLORIDA DEPARTMENT OF TRANSPORTATION			
							ROAD NO.	COUNTY	FINANCIAL PROJECT ID	PROJECT NAME:

NOTICE: THE OFFICIAL RECORD OF THIS SHEET IS THE ELECTRONIC FILE SIGNED AND SEALED UNDER RULE 61G15-23.003, F.A.C.

WALL No. 1A

PGL Flyover Station	Exposed Face of Wall 1A Offset from PGL Flyover (ft.)	Top of Coping Elevation @ Wall 1A (ft.)
13+55.00	34.958	224.600
13+75.00	34.958	224.969
14+00.00	34.958	225.503
14+25.00	34.958	226.116
14+50.00	34.958	226.809
14+75.00	34.958	227.583
15+00.00	34.958	228.436
15+25.00	34.958	229.370
15+50.00	34.958	230.383
15+75.00	34.958	231.477
16+00.00	34.958	232.650
16+25.00	34.958	233.904
16+50.00	34.958	235.390
16+75.00	34.958	236.848
16+90.00	34.958	237.615

WALL No. 2A

PGL Flyover Station	Exposed Face of Wall 2A Offset from PGL Flyover (ft.)	Top of Coping Elevation @ Wall 2A (ft.)
26+78.83	34.958	-
26+84.00	34.958	239.246
27+00.00	34.958	238.327
27+25.00	34.958	236.948
27+50.00	34.958	235.569
27+75.00	34.958	234.191
28+00.00	34.958	232.812
28+25.00	34.958	231.433
28+50.00	34.958	230.055
28+75.00	34.958	228.676
29+00.00	34.958	227.297
29+25.00	34.958	226.058
29+50.00	34.958	224.927
29+75.00	34.958	223.891
30+00.00	34.958	222.950
30+25.00	34.958	222.109
30+50.00	34.958	221.525
30+70.00	22.958	221.121

WALL No. 1C

PGL Flyover Station	Exposed Face of Wall 1C Offset from PGL Flyover (ft.)	Top of Coping Elevation @ Wall 1C (ft.)
10+90.00	6.958	225.647
11+00.00	6.958	225.486
11+25.00	6.958	225.139
11+50.00	6.958	224.872
11+75.00	6.958	224.685
12+00.00	6.958	224.578
12+25.00	6.958	224.551
12+50.00	6.958	224.604
12+75.00	6.958	224.737
13+00.00	6.958	224.950
13+25.00	6.958	225.243
13+50.00	6.958	225.616
13+75.00	6.958	226.069
14+00.00	6.958	226.603
14+25.00	6.958	227.216
14+50.00	6.958	227.909
14+75.00	6.958	228.683
15+00.00	6.958	229.536
15+25.00	6.958	230.470
15+50.00	6.958	231.483
15+75.00	6.958	232.577
16+00.00	6.958	233.750
16+25.00	6.958	235.004
16+50.00	6.958	236.323
16+75.00	6.958	237.648
16+90.00	6.958	238.477
16+93.50	6.958	-

WALL No. 2C


PGL Flyover Station	Exposed Face of Wall 2C Offset from PGL Flyover (ft.)	Top of Coping Elevation @ Wall 2C (ft.)
26+78.83	6.958	-
26+84.00	6.958	238.015
27+00.00	6.958	237.310
27+25.00	6.958	236.055
27+50.00	6.958	234.804
27+75.00	6.958	233.554
28+00.00	6.958	232.314
28+25.00	6.958	231.102
28+50.00	6.958	229.890
28+75.00	6.958	228.678
29+00.00	6.958	227.466
29+25.00	6.958	226.258
29+50.00	6.958	225.127
29+75.00	6.958	224.091
30+00.00	6.958	223.150
30+25.00	6.958	222.307
30+50.00	6.958	221.656
30+70.00	18.958	221.201

- NOTES:
 1. Offsets are given to the exterior face of the proprietary wall.
 2. For proposed ground elevations for all walls, see Sheets BW-2 and BW-3.

EXHIBIT CP-4
 Date: 1/1/10

REVISIONS						DRAWN BY: XXX MM-YY			STATE OF FLORIDA DEPARTMENT OF TRANSPORTATION			SHEET TITLE: MSE WALLS NOS. 1 AND 2 ELEVATIONS		REF. DWG. NO.
DATE	BY	DESCRIPTION	DATE	BY	DESCRIPTION	CHECKED BY: XXX MM-YY	ROAD NO.	COUNTY	FINANCIAL PROJECT ID	PROJECT NAME	SHEET NO.			

#USER# #DATE# #TIME# #FILES#

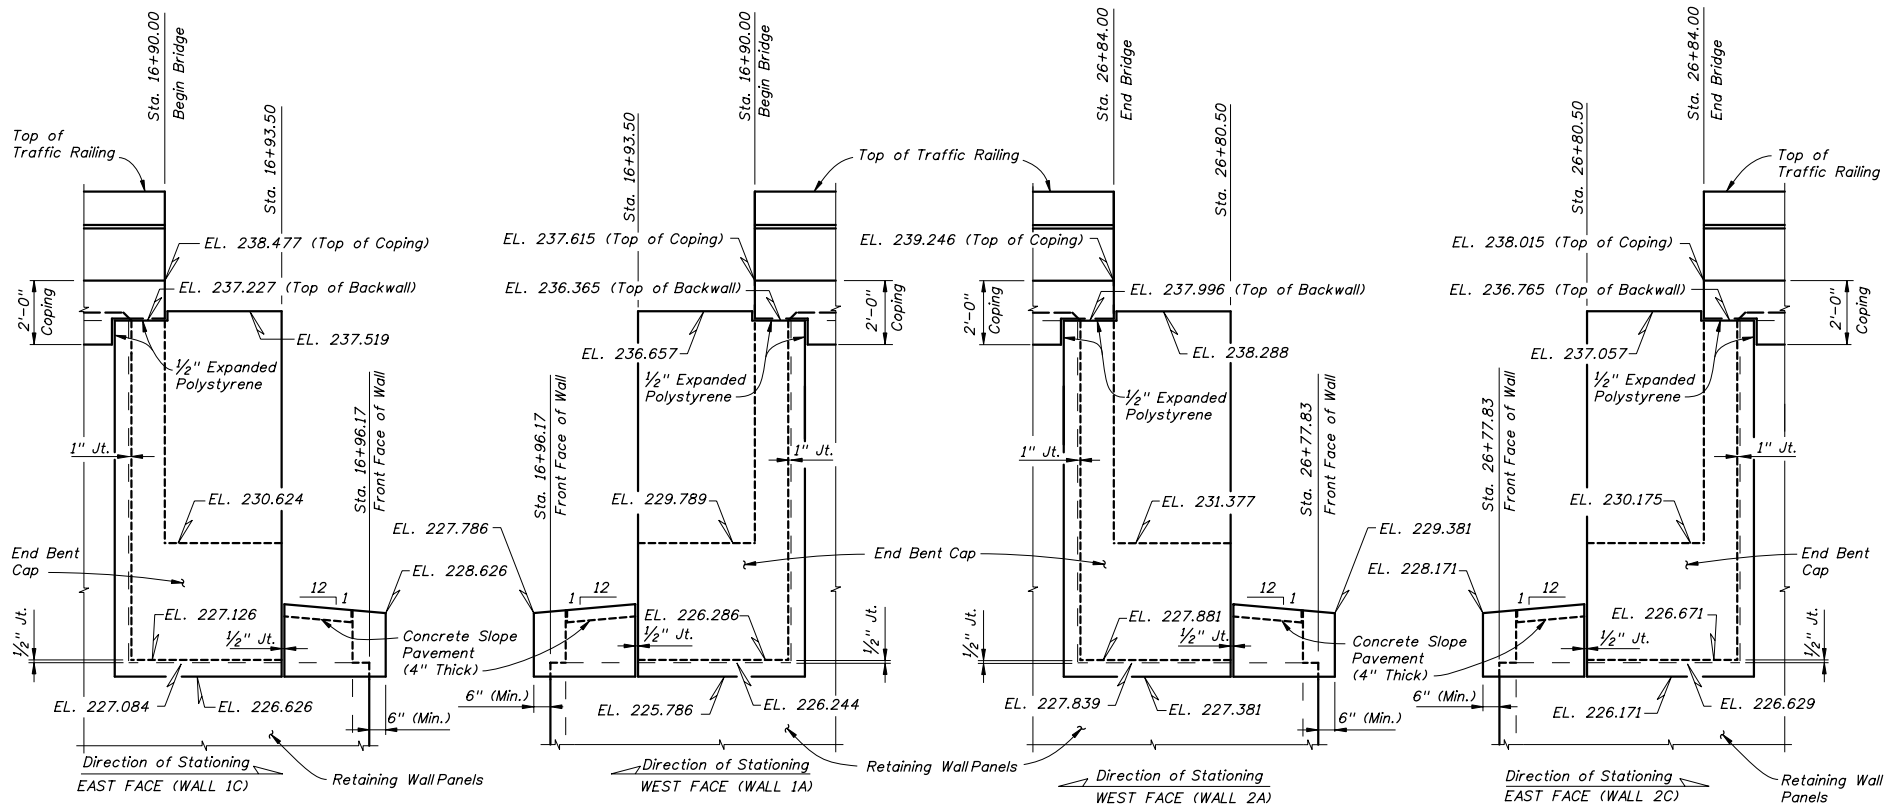

END BENT NO. 1

END BENT NO. 7

NOTE:
 1/2" and 1" Joints to be
 Preformed Joint Filler,
 unless otherwise shown.

EXHIBIT CP-5
 Date: 1/1/10

REVISIONS						DRAWN BY: XXX MM-YY	STATE OF FLORIDA DEPARTMENT OF TRANSPORTATION			SHEET TITLE: MSE WALLS MISCELLANEOUS DETAILS	REF. DWG. NO.
DATE	BY	DESCRIPTION	DATE	BY	DESCRIPTION		ROAD NO.	COUNTY	FINANCIAL PROJECT ID		

#USER# #DATE# #TIME# #FILES#

NOTICE: THE OFFICIAL RECORD OF THIS SHEET IS THE ELECTRONIC FILE SIGNED AND SEALED UNDER RULE 61G15-23.003, F.A.C.

TEMPORARY RETAINING WALL SYSTEM DATA TABLES

GEO TECHNICAL INFORMATION						
		Reinforced Soil & Random Backfill	Loose Fine Sand	Firm Fine Sand	Loose Clayey Fine Sand	Firm Clayey Fine Sand
Depth Below Existing Ground Line (ft.)	Wall No. 1	—	0'-9'	9'-23'	23'-37'	37'-45'
	Wall No. 2	—	0'-9'	9'-23'	23'-37'	37'-45'
Effective Unit Weight (pcf)		110	118	118	120	110
Cohesion (psf)		0	0	0	0	0
Internal Friction Angle		30°	34°	34°	35°	30°
Depth Below Existing Ground Line (ft.)	Wall No. 3	—	0'-10'	10'-15'	15'-17'	17'-45'
	Wall No. 4	—	0'-10'	10'-15'	15'-17'	17'-45'
Effective Unit Weight (pcf)		110	116	118	120	116
Cohesion (psf)		0	0	0	4177	0
Internal Friction Angle		30°	32°	34°	0	34°

NOTES:

1. See the Qualified Products List for approved Wall Systems (Type 3).
2. See Design Standards Index No. 5301 for General Notes and Details

NOTE:

If the unit weight and/or internal friction angle of the fill proposed by the Contractor differs from that shown above, the Project Engineer will contact both the District Geotechnical Engineer and the Wall Designer for a possible redesign.

RETAINING WALL VARIABLES				
Wall No.	Wall Settlement			Air Contaminants Classification
	Long Term Settlement (in.)	Short Term Settlement (in.)	Differential Settlement (%) (ft./100 ft.)	
1 & 2	1/2"	3/8"	0.50	Extremely Aggressive
3 & 4	1/2"	1/4"	0.50	Extremely Aggressive

NOTE:

Design walls for the settlements noted in the table. Long term settlement is measured from the beginning of wall construction.

SOIL REINFORCEMENT LENGTHS FOR EXTERNAL STABILITY										
Walls 1 thru 4	Wall Height (ft.)	5'-0"	5'-6"	6'-0"	6'-6"	7'-0"	7'-6"			
	Reinforcement Length (ft.)	7'-0"	7'-0"	7'-0"	7'-0"	7'-0"	7'-0"			
	Factored Bearing Resistance (psf)	1082	1241	1426	1648	1454	1623			

NOTES:


1. The reinforcement strap lengths shown above are the minimum lengths required for external stability. The reinforcement lengths used in the construction of the retaining walls will be the longer of that required for external or internal stability (determined by proprietary wall companies).
2. The Factored Bearing Resistances shown above are the critical (lowest) values from all the load cases analyzed using LRFD methodology.

Note: Use CADD Cell "05301".
Work this cell with Design Standards, Index No. 5301.


EXHIBIT CP-6
Date: 1/1/10

REVISIONS						DRAWN BY:			STATE OF FLORIDA			SHEET TITLE:			REF. DWG. NO.
DATE	BY	DESCRIPTION	DATE	BY	DESCRIPTION	XXX MM-YY	XXX MM-YY	XXX MM-YY	DEPARTMENT OF TRANSPORTATION			TEMPORARY MSE WALL DATA TABLES AND NOTES			
									ROAD NO.	COUNTY	FINANCIAL PROJECT ID	PROJECT NAME:			
															SHEET NO.

#USER# #DATE# #TIME# #FILES#

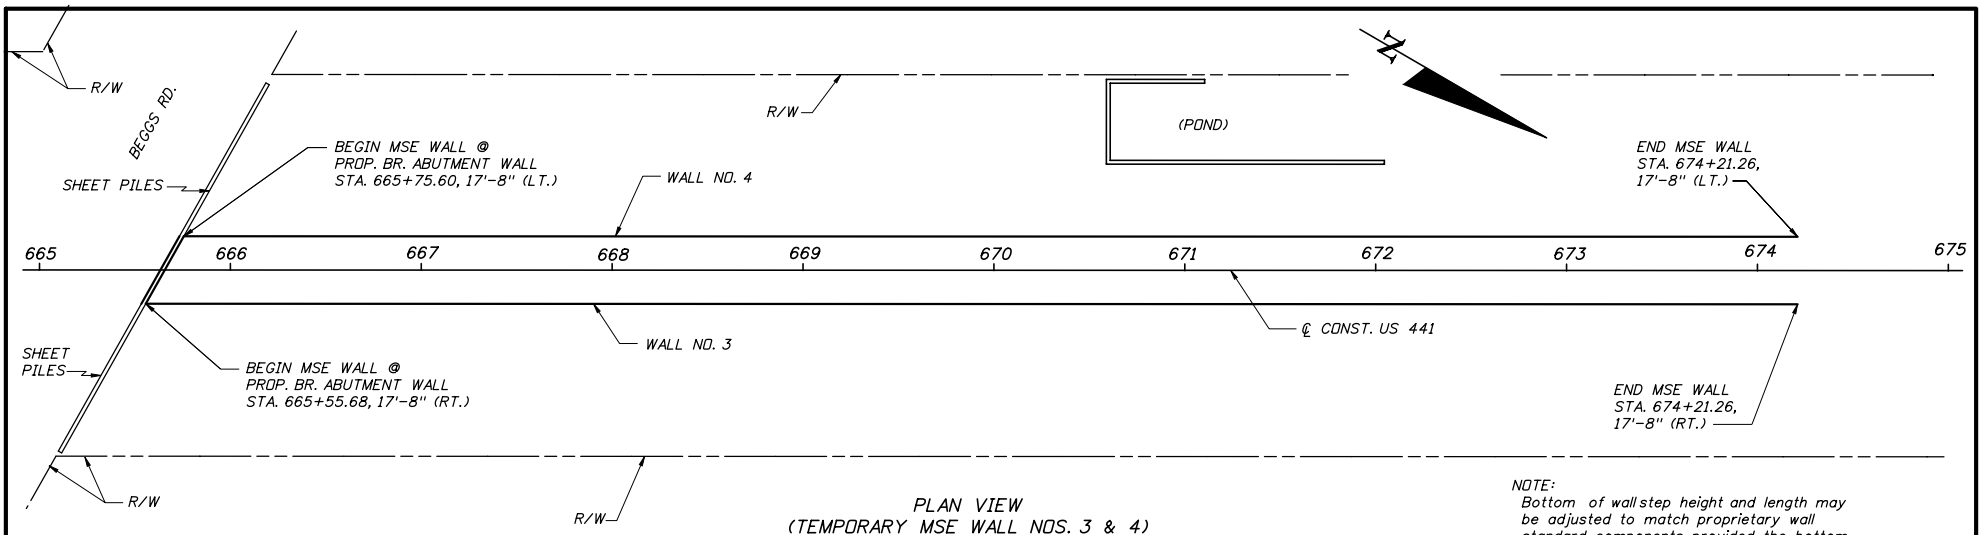

NOTE:
Bottom of wall step height and length may be adjusted to match proprietary wall standard components provided the bottom of the wall remains below existing ground.

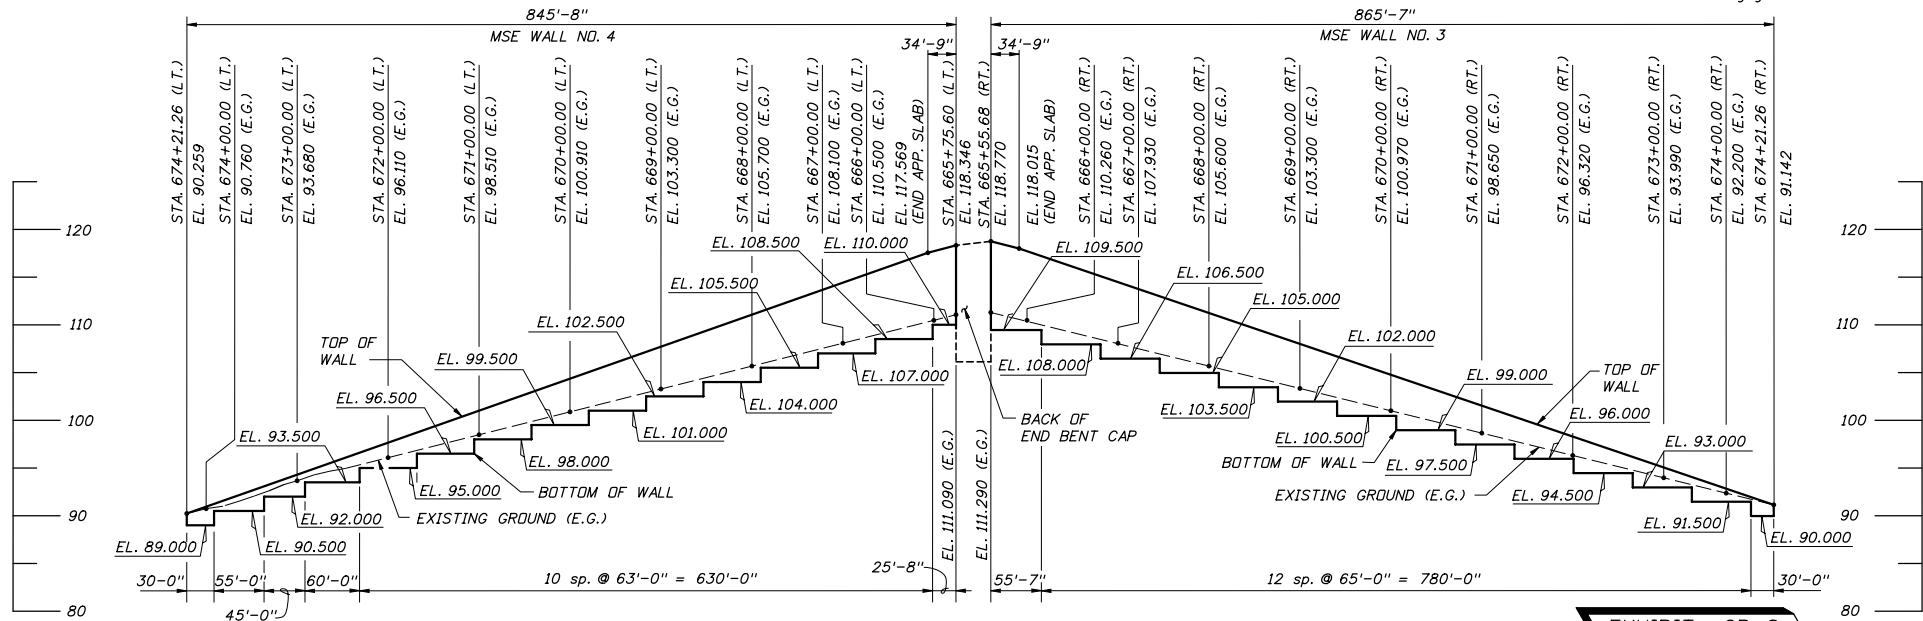

**EXPANDED ELEVATION VIEW
(TEMPORARY MSE WALL NOS. 3 & 4, LOOKING AT FRONT FACE OF WALL)**

**EXHIBIT CP-8
Date: 1/1/10**

REVISIONS				DRAWN BY:		SHEET TITLE:		REF. DWG. NO.
DATE	BY	DESCRIPTION	DATE	BY	XXX MM-YY	TEMPORARY MSE WALL NOS. 3 & 4 CONTROL DRAWING		
					CHECKED BY:	STATE OF FLORIDA DEPARTMENT OF TRANSPORTATION		
					DESIGNED BY:	ROAD NO.	COUNTY	FINANCIAL PROJECT ID
					CHECKED BY:	PROJECT NAME:		SHEET NO.
						#USER#	#DATE#	#TIME#
							#FILES#	

NOTICE: THE OFFICIAL RECORD OF THIS SHEET IS THE ELECTRONIC FILE SIGNED AND SEALED UNDER RULE 61G15-23.003, F.A.C.

TABULATION OF QUANTITIES/PLANT SCHEDULE

PAY ITEM NO.	PAYSIZE	SYM	BOTANICAL NAME	COMMON NAME	INSTALLED SIZE	MAX. MAINTAINED SIZE	SPACING	REMARKS	UNIT	SHEET NUMBERS										TOTAL THIS SHEET		GRAND TOTAL	
										LD-5		LD-6		LD-7		LD-8		LD-9		PLAN	FINAL	PLAN	FINAL
										PLAN	FINAL	PLAN	FINAL	PLAN	FINAL	PLAN	FINAL	PLAN	FINAL				
570-1-2		SOD	STEMOTAPHRUM SECUNDATUM	ST. AUGUSTINE GRASS				LAY SOLIDLY IN ALL INDICATED AREAS	SY	330.78		140.89		346.11		4193.44		44		5055.22		5055.22	
580-1-1	SMALL	AG	ARACHIS GLABRATA	PERENNIAL PEANUT	1 GAL.	6" HT.	18" OC	MOW REGULARLY TO PROMOTE FLOWERING	EA	1655		1118		2729		0		334		5836		5836	
	SMALL	LEG	LIRIOPE MUSCARI "EVERGREEN GIANT"	EVERGREEN GIANT LIRIOPE	1 GAL.	16" HT.	24" OC	THIN BY PLANT DIVISION EVERY 3-5 YEARS	EA	434		381		0		805		0		1620		1620	
	SMALL	AS	ARISTIDA STRICTA	WIREGRASS	1 GAL.	2'-4' HT. 2'-3' SPREAD	2' OC	NO SERIOUS PESTS	EA	465		513		0		0		0		978		978	
	SMALL	ND	ILEX VOMITORIA "SHELLINGS"	DWARF YAUPON	3 GAL.	3'-4' HT. 3'-4' SPREAD	3' OC	9 FEMALES TO 1 MALE/ MINIMAL PRUNING REQUIRED	EA	89		134		0		109		0		332		332	
	SMALL	HF	HERMEROCALLIS FULVA	DAYLILY	1 GAL.	4' HT.	24" OC	THIN BY PLANT DIVISION EVERY 3-5 YEARS	EA	131		288		530		0		0		949		949	
	SMALL	TA	TRACHELOSPERMUM ASIATICUM	STAR JASMINE	1 QUART	2' HT. 4'-5' SPREAD	24" OC	TRIM TO MAINTAIN BEDLINES	EA	0		753		431		0		383		1567		1567	
	SMALL	CL	COREOPSIS	COREOPSIS	1 GAL.	3' HT.	24" OC	REMOVE DEAD STEMS	EA	0		0		0		453		0		453		453	
	SMALL	IV	IRIS VIRGINICA	SOUTHERN BLUE FLAG IRIS	1 GAL.	18" HT.	12" OC	THIN BY PLANT DIVISION EVERY 3-5 YEARS	EA	0		0		0		461		0		461		461	
580-1-2	LARGE	QV	QUERCUS VIRGINIANA	LIVE OAK	14' HT. 65 GAL.	40' HT.	AS SHOWN ON PLANS	2" MINIMUM CALIPER/ MINIMAL PRUNING REQUIRED	EA	7		1		0		9		0		17		17	
	LARGE	VO	VIBURNUM OBOVATUM	WALTER'S VIBURNUM	42" HT. 7 GAL	6' HT.	48" OC	PRUNE TO MAINTAIN NATURAL SHAPE	EA	181		183		0		57		0		424		424	
	LARGE	LIS	LAGERSTROEMIA INDICA	CREPE MYRTLE STANDARD	8'-10' HT. 30 GAL.	20' HT.	AS SHOWN ON PLANS	MULTI-TRUNK 3" MINIMUM CALIPER/" PER BRANCH	EA	0		13		2		0		3		18		18	
	LARGE	IOE	ILEX OPACA "EAST PALATKA"	EAST PALATKA HOLLY	12' HT. 30 GAL.	25' HT.	AS SHOWN ON PLANS	9 FEMALES TO 1 MALE/ MINIMAL PRUNING REQUIRED	EA	0		3		0		0		0		3		3	
	LARGE	TD	TAXODIUM DISTICHUM	BALD CYPRESS	8' HT. 30 GAL.	50' HT.	AS SHOWN ON PLANS	2" MINIMUM CALIPER/ MINIMAL PRUNING REQUIRED	EA	0		0		0		3		0		3		3	
	LARGE	BN	BETULA NIGRA	RIVER BIRCH	12' HT. 30 GAL.	50' HT.	AS SHOWN ON PLANS	2" MINIMUM CALIPER/ WELL SHAPED	EA	0		0		0		3		0		3		3	

Pay size in accordance with the Basis of Estimates Manual

Small plants Include:

1. All ground covers
2. Shrubs to less than 7 gallon
3. Trees to less than 7 gallon
4. Palms clustering type less than 6 foot overall height
5. Cycads to less than 7 gallon

Large plants Include:

1. Shrubs 7 gallon or greater
2. Trees 7 gallon and greater
3. All palms single trunk
4. Palms clustering type 6 foot overall height and greater
5. Cycads 7 gallon or greater
6. All sabal palms (a.k.a. sabal palmetto, cabbage palm, state tree)

EXHIBIT: LD-1
Date: 1/1/10

REVISIONS				STATE OF FLORIDA DEPARTMENT OF TRANSPORTATION			TABULATION OF QUANTITIES/ PLANT SCHEDULE	SHEET NO.
DATE	DESCRIPTION	DATE	DESCRIPTION	ROAD NO.	COUNTY	FINANCIAL PROJECT ID		
				10	LEON	123456-1-52-01		

NOTICE: THE OFFICIAL RECORD OF THIS SHEET IS THE ELECTRONIC FILE SIGNED AND SEALED UNDER RULE 6160-11.011, F.A.C.

THIS EXHIBIT IS AN EXAMPLE NARRATIVE OF A STORMWATER POLLUTION PREVENTION PLAN (SWPPP) FOR A MAJOR RECONSTRUCTION PROJECT. ACTUAL PROJECT CONDITIONS OFTEN DICTATE DIFFERENT APPROACHES THAN SHOWN HERE. THE ENGINEER IS RESPONSIBLE FOR DEVELOPING A SITE SPECIFIC SWPPP THAT COMPLIES WITH VOLUME I CHAPTER 11 OF THE PLANS PREPARATION MANUAL.

THE FOLLOWING NARRATIVE OF THE STORMWATER POLLUTION PREVENTION PLAN CONTAINS REFERENCES TO THE STANDARD SPECIFICATIONS FOR ROAD AND BRIDGE CONSTRUCTION, THE DESIGN STANDARDS, AND OTHER SHEETS OF THESE CONSTRUCTION PLANS. THE FIRST SHEET OF THE CONSTRUCTION PLANS (CALLED THE KEY SHEET) CONTAINS AN INDEX TO THE OTHER SHEETS. THE COMPLETE STORMWATER POLLUTION PREVENTION PLAN INCLUDES SEVERAL ITEMS: THIS NARRATIVE DESCRIPTION, THE DOCUMENTS REFERENCED IN THIS NARRATIVE, THE CONTRACTOR'S APPROVED EROSION CONTROL PLAN REQUIRED BY SPECIFICATION SECTION 104, AND REPORTS OF INSPECTIONS MADE DURING CONSTRUCTION.

1.0 SITE DESCRIPTION:

1.A. NATURE OF CONSTRUCTION ACTIVITY:

THE PROJECT IS THE RECONSTRUCTION OF SR 007 (JAMES BOND BOULEVARD) TO A MAJOR URBAN ROADWAY. THIS INVOLVES CONSTRUCTING ROADWAY SURFACE, CURB AND GUTTER, SIDEWALK, UNDERGROUND STORM DRAIN SYSTEMS, AND STORMWATER MANAGEMENT FACILITIES. THE PROJECT EXTENDS FROM NORTH OF PAUL RUSSELL ROAD TO PERKINS STREET, A DISTANCE OF APPROXIMATELY 1.1 MILES.

1.B. SEQUENCE OF MAJOR SOIL DISTURBING ACTIVITIES:

IN THE SEDIMENT AND EROSION CONTROL PLAN, THE CONTRACTOR SHALL PROVIDE A DETAILED SEQUENCE OF CONSTRUCTION FOR ALL CONSTRUCTION ACTIVITIES. THE CONTRACTOR SHALL FOLLOW THE SEQUENCE OF MAJOR ACTIVITIES DESCRIBED BELOW, UNLESS THE CONTRACTOR PROPOSES A DIFFERENT SEQUENCE THAT IS EQUAL OR BETTER AT CONTROLLING EROSION AND TRAPPING SEDIMENT AND IS APPROVED BY THE ENGINEER.

FOR EACH CONSTRUCTION PHASE, INSTALL PERIMETER CONTROLS AFTER CLEARING AND GRUBBING NECESSARY FOR INSTALLATION OF CONTROLS BUT BEFORE BEGINNING OTHER WORK FOR THE CONSTRUCTION PHASE. REMOVE PERIMETER CONTROLS ONLY AFTER ALL UPSTREAM AREAS ARE STABILIZED.

1. CLEARING AND GRUBBING, EARTHWORK, AND STORM DRAIN CONSTRUCTION FOR THE OUTFALL FROM THE PONDS.
2. CLEARING AND GRUBBING, EARTHWORK FOR POND CONSTRUCTION.
3. STORM DRAIN AND ROADWAY UNDERDRAIN CONSTRUCTION. CONSTRUCT THE STORM DRAIN PIPE IN THE UPSTREAM DIRECTION.
4. EARTHWORK ASSOCIATED WITH THE CONSTRUCTION OF ROADWAY, GRAVITY WALL, CURB, SUBGRADE, BASE, PAVEMENT, AND SIDEWALK.
5. CONSTRUCT UNDERDRAIN IN POND BOTTOM.

1.C. AREA ESTIMATES:

TOTAL SITE AREA: 19.6 ACRES.
TOTAL AREA TO BE DISTURBED: 19.6 ACRES.

1.D. RUNOFF DATA:

RUNOFF COEFFICIENTS:

BEFORE: 0.62
DURING: VARIES FROM 0.62 TO 0.76
AFTER: 0.76

SOILS DATA: THE RESULTS OF THE SOIL BORINGS ALONG THE ROADWAY ARE SHOWN IN THE ROADWAY SOIL SURVEY SHEET(S). THE RESULTS OF SOIL BORINGS DONE IN THE PONDS ARE SHOWN ON THE POND DETAIL SHEETS. THE NUMBERS FOR THESE ARE IDENTIFIED ON THE KEY SHEET OF THESE CONSTRUCTION PLANS. IN GENERAL, THE SOILS ARE CLAYEY SANDS.

OUTFALL INFORMATION:

THERE ARE 4 OUTFALLS.

***1 DESCRIPTION: EXISTING POND AT LAURA LEE.**

LOCATION: LATITUDE 30° 24' 30"N, LONGITUDE, 84° 16' 45"W.
EST. DRAINAGE AREA SIZE: 13.6 ACRES.
RECEIVING WATER NAME: NOT APPLICABLE.

***2 DESCRIPTION: POND 1. THIS DISCHARGES TO THE STORM DRAIN SYSTEM THAT RUNS UNDER ORANGE AVENUE. THIS SYSTEM IN TURN DISCHARGES TO THE BOX CULVERT AT STA. 531+00.**

LOCATION: LATITUDE 30° 24' 45"N, LONGITUDE 84° 17' 00"W.
EST. DRAINAGE AREA SIZE: 7.3 ACRES.
RECEIVING WATER NAME: EAST DITCH.

***3 DESCRIPTION: BOX CULVERT AT STA. 531+00.**

LOCATION: LATITUDE 30° 24' 45"N, LONGITUDE 84° 17' 00"W
EST. DRAINAGE AREA SIZE: 4.2 SQUARE MILES.
RECEIVING WATER NAME: EAST DITCH.

***4 DESCRIPTION: POND 2. THIS DISCHARGES TO THE SR 007 STORM DRAIN SYSTEM THAT DRAINS TO THE BOX CULVERT AT STA. 531+00.**

LOCATION: LATITUDE 30° 25' 00"N, LONGITUDE 84° 17' 00"W.
EST. DRAINAGE AREA SIZE: 15.4 ACRES.
RECEIVING WATER NAME: EAST DITCH.

1.E. SITE MAP:

THE CONSTRUCTION PLANS ARE BEING USED AS THE SITE MAPS. THE LOCATION OF THE REQUIRED INFORMATION IS DESCRIBED BELOW. THE SHEET NUMBERS FOR THE PLAN SHEETS REFERENCED ARE IDENTIFIED ON THE KEY SHEET OF THESE CONSTRUCTION PLANS.

DRAINAGE PATTERNS: THE DRAINAGE BASIN DIVIDES AND FLOW DIRECTIONS ARE SHOWN ON THE DRAINAGE MAPS. THE BACK OF SIDEWALK PROFILE SHEETS SHOW OVERLAND FLOW DIRECTION AT THE RIGHT OF WAY LINE. THE ARROWS ABOVE AND BELOW THE PROFILE REPRESENT THE FLOW DIRECTION AT THE LEFT AND RIGHT PROPERTY LINE, RESPECTIVELY. ARROWS POINTING TO THE PROFILE INDICATE RUNOFF COMING TO THE SITE. POINTING AWAY FROM THE SITE INDICATE RUNOFF LEAVING THE SITE.

APPROXIMATE SLOPES: THE SLOPES OF THE SITE CAN BE SEEN IN THE CROSS SECTION SHEETS AND THE PLAN-PROFILE SHEETS. THERE ARE POND CROSS SECTIONS LOCATED WITH THE POND DETAIL SHEETS.

AREAS OF SOIL DISTURBANCE: THE AREAS TO BE DISTURBED ARE INDICATED ON THE PLAN-PROFILE SHEETS, THE CROSS SECTION SHEETS, AND THE POND DETAIL SHEETS. ANY AREAS WHERE PERMANENT FEATURES ARE SHOWN TO BE CONSTRUCTED ABOVE OR BELOW GROUND WILL BE DISTURBED.

AREAS NOT TO BE DISTURBED: ESSENTIALLY THE WHOLE PROJECT WILL BE DISTURBED DURING CONSTRUCTION.

LOCATIONS OF TEMPORARY CONTROLS: THESE ARE SHOWN ON THE EROSION CONTROL SHEETS EXCEPT FOR THE CONTROLS ASSOCIATED WITH THE BOX CULVERT REPLACEMENT WHICH ARE SHOWN ON THE BOX CULVERT CONSTRUCTION DETAIL SHEET. TABLES PROVIDING SUMMARIES OF TEMPORARY EROSION AND SEDIMENT CONTROL ITEMS ARE PROVIDED IN THE SUMMARY OF QUANTITY SHEETS.

LOCATIONS OF PERMANENT CONTROLS: THE STORMWATER PONDS ARE THE PRIMARY PERMANENT STORMWATER MANAGEMENT CONTROLS. THESE ARE SHOWN ON THE POND DETAIL SHEETS.

AREAS TO BE STABILIZED: TEMPORARY STABILIZATION PRACTICES ARE SHOWN IN THE SAME LOCATION AS THE TEMPORARY CONTROLS MENTIONED ABOVE. PERMANENT STABILIZATION IS SHOWN ON THE TYPICAL SECTION SHEETS, THE PLAN-PROFILE SHEETS AND THE POND DETAIL SHEETS.

SURFACE WATERS: THE ONLY SURFACE WATER WITHIN THE SITE IS THE EAST DITCH, WHICH FLOWS THROUGH THE CULVERT AT STATION 531+00. THIS IS LOCATED ON THE PLAN-PROFILE SHEETS AND THE BOX CULVERT CONSTRUCTION DETAIL SHEET.

DISCHARGE POINTS TO SURFACE WATERS: THERE IS ONLY ONE. THIS IS SHOWN ON THE PLAN-PROFILE SHEETS AT THE EAST DITCH (CULVERT AT STATION 531+00).

1.F. RECEIVING WATERS:

SEE ITEM 1.D FOR THE OUTFALL LOCATIONS AND RECEIVING WATER NAMES. THERE ARE NO WETLAND AREAS ON THE PROJECT SITE.

EXHIBIT SWP-1
DATE: 1/1/10

REVISIONS				STATE OF FLORIDA DEPARTMENT OF TRANSPORTATION			STORMWATER POLLUTION PREVENTION PLAN	SHEET NO.
DATE	DESCRIPTION	DATE	DESCRIPTION	ROAD NO.	COUNTY	FINANCIAL PROJECT ID		
				7	LEON	123456-1-52-01		

#USER# #DATE# #TIME# #FILE#

NOTICE: THE OFFICIAL RECORD OF THIS SHEET IS THE ELECTRONIC FILE SIGNED AND SEALED UNDER RULE 6805-23.003, F.A.C.

THIS EXHIBIT IS AN EXAMPLE NARRATIVE OF A STORMWATER POLLUTION PREVENTION PLAN (SWPPP) FOR A MAJOR RECONSTRUCTION PROJECT. ACTUAL PROJECT CONDITIONS OFTEN DICTATE DIFFERENT APPROACHES THAN SHOWN HERE. THE ENGINEER IS RESPONSIBLE FOR DEVELOPING A SITE SPECIFIC SWPPP THAT COMPLIES WITH VOLUME I CHAPTER 11 OF THE PLANS PREPARATION MANUAL.

2.0 CONTROLS:

2.A. EROSION AND SEDIMENT CONTROLS:

IN THE SEDIMENT AND EROSION CONTROL PLAN, THE CONTRACTOR SHALL DESCRIBE THE PROPOSED STABILIZATION AND STRUCTURAL PRACTICES BASED ON THE CONTRACTOR'S PROPOSED TEMPORARY TRAFFIC CONTROL (TTC) PLAN. THE FOLLOWING RECOMMENDED GUIDELINES ARE BASED ON THE TEMPORARY TRAFFIC CONTROL PLAN OUTLINED IN THE CONSTRUCTION PLANS. WHERE FOLLOWING THE TEMPORARY TRAFFIC CONTROL PLAN OUTLINED IN THESE CONSTRUCTION PLANS, THE CONTRACTOR MAY CHOSE TO ACCEPT THE FOLLOWING GUIDELINES OR MODIFY THEM IN THE SEDIMENT AND EROSION CONTROL PLAN, SUBJECT TO APPROVAL BY THE ENGINEER. AS WORK PROGRESSES, THE CONTRACTOR SHALL MODIFY THE PLAN TO ADAPT TO SEASONAL VARIATION, CHANGES IN CONSTRUCTION ACTIVITIES, AND THE NEED FOR BETTER PRACTICES.

FOR EACH CONSTRUCTION PHASE, INSTALL PERIMETER CONTROLS AFTER CLEARING AND GRUBBING NECESSARY FOR INSTALLATION OF CONTROLS BUT BEFORE BEGINNING OTHER WORK FOR THE CONSTRUCTION PHASE. REMOVE PERIMETER CONTROLS ONLY AFTER ALL UPSTREAM AREAS ARE STABILIZED.

PHASE I OF TEMPORARY TRAFFIC CONTROL PLANS.

ROADWAY, STATION 501+10 TO 520+40 RIGHT: IMMEDIATELY AFTER CONSTRUCTING THE TEMPORARY PAVEMENT, STABILIZE THE ENTIRE AREA BETWEEN THE TEMPORARY PAVEMENT AND THE RIGHT OF WAY LINE USING TEMPORARY SOD.

OUTFALL OF POND 1:

CONSTRUCT THE OUTFALL PIPE FROM S-106 TOWARDS THE POND. THE CONTRACTOR SHALL HAVE INLET PROTECTION AVAILABLE AT ALL TIMES DURING THE PIPE CONSTRUCTION TO SUBSTANTIALLY BLOCK RUNOFF IN THE TRENCH FROM ENTERING THE PIPE. CONSTRUCT PIPE TO THE POND AND CONSTRUCT THE OUTLET STRUCTURE OF THE POND.

POND 1 CONSTRUCTION:

CLEAR AND GRUB THE POND SITE. INITIALLY EXCAVATE THE POND ONLY ENOUGH TO CONSTRUCT SEDIMENT BARRIERS AS DETAILED IN THE TTC PLAN. THEN EXCAVATE THE POND TO APPROXIMATE PROPOSED DIMENSIONS. TURF ALL DISTURBED AREAS OF THE POND SITE ABOVE ELEVATION 51.0. FINAL GRADING WILL BE DONE AT THE END OF PHASE TWO OF THE TTC PLAN.

ROADWAY, STATION 510+10 TO 523+70 LEFT:

CONSTRUCT THE STORM DRAIN FROM THE POND TO THE ROADWAY AND THEN IN THE UPSTREAM DIRECTION ALONG THE LEFT SIDE OF THE PROJECT. DURING THE SUBSOIL EXCAVATION, AND CONSTRUCTION OF THE ROADWAY UNDERDRAIN, STORM DRAIN, AND WALL, USE S-19 AS THE PRIMARY INLET FOR CONVEYANCE TO THE POND. STAGE CONSTRUCT THE INLET AS DETAILED IN THE TTC PLAN.

ROADWAY, STATION 501+10 TO 510+40 LEFT:

DURING THE SUBSOIL EXCAVATION AND CONSTRUCTION OF THE UNDERDRAIN, STORM DRAIN, AND WALL, USE S-12 AS THE PRIMARY INLET FOR CONVEYANCE TO THE LAURA LEE POND. S-12 SHOULD BE CONSTRUCTED BEFORE DISTURBING SOIL UPSTREAM. STAGE CONSTRUCT AND PROTECT THE INLET AS DETAILED IN THE TTC PLAN.

PHASE II OF THE TEMPORARY TRAFFIC CONTROL PLAN:

ROADWAY, STATION 510+10 TO 523+10 RIGHT:

DURING THE SUBSOIL EXCAVATION AND CONSTRUCTION OF THE ROADWAY UNDERDRAIN AND STORM DRAIN, USE S-20 AS THE PRIMARY INLET FOR CONVEYANCE TO POND 1. STAGE CONSTRUCT AND PROTECT THE INLET IN A MANNER SIMILAR TO S-19 IN PHASE I OF THE TTC PLAN.

ROADWAY, STATION 501+10 TO 510+40 RIGHT:

DURING THE SUBSOIL EXCAVATION AND CONSTRUCTION OF THE UNDERDRAIN, STORM DRAIN, AND WALLS, USE S-10 AS THE PRIMARY INLET FOR CONVEYANCE TO THE LAURA LEE POND. STAGE CONSTRUCT AND PROTECT THE INLET IN A MANNER SIMILAR TO S-12 IN PHASE I OF THE TTC PLAN.

POND 1 CONSTRUCTION:

AFTER ENTIRE BASIN IS PERMANENTLY STABILIZED, CONSTRUCT UNDERDRAIN IN THE POND BOTTOM.

2.A.1 STABILIZATION PRACTICES:

IN THE SEDIMENT AND EROSION CONTROL PLAN, THE CONTRACTOR SHALL DESCRIBE THE STABILIZATION PRACTICES PROPOSED TO CONTROL EROSION. THE CONTRACTOR SHALL INITIATE ALL STABILIZATION MEASURES AS SOON AS PRACTICAL, BUT IN NO CASE MORE THAN 7 DAYS, IN PORTIONS OF THE SITE WHERE CONSTRUCTION ACTIVITIES HAVE TEMPORARILY OR PERMANENTLY CEASED. THE STABILIZATION PRACTICES SHALL INCLUDE AT LEAST THE FOLLOWING, UNLESS OTHERWISE APPROVED BY THE ENGINEER.

THE PARAGRAPH ABOVE REFERS TO A 7 DAY LIMIT BEFORE INITIATING STABILIZATION. THE DEP GENERIC PERMIT SPECIFIES 7 DAYS, BUT STRICTER REQUIREMENTS FROM OTHER PERMITTING AGENCIES WILL OFTEN APPLY AND SHOULD BE NOTED. FOR EXAMPLE, ST. JOHNS RIVER WATER MANAGEMENT DISTRICT HAS A 7 DAY LIMIT IN 40C-42 F.A.C.

TEMPORARY:

- * ARTIFICIAL COVERINGS IN ACCORDANCE WITH SPECIFICATION SECTION 104.
- * TURF AND SOD IN ACCORDANCE WITH SPECIFICATION SECTION 104.

PERMANENT:

- * ASPHALT OR CONCRETE SURFACE.
- * SOD IN ACCORDANCE WITH SPECIFICATION SECTION 570.

2.A.2 STRUCTURAL PRACTICES:

IN THE SEDIMENT AND EROSION CONTROL PLAN, THE CONTRACTOR SHALL DESCRIBE THE PROPOSED STRUCTURAL PRACTICES TO CONTROL OR TRAP SEDIMENT AND OTHERWISE PREVENT THE DISCHARGE OF POLLUTANTS FROM EXPOSED AREAS OF THE SITE. SEDIMENT CONTROLS SHALL BE IN PLACE BEFORE DISTURBING SOIL UPSTREAM OF THE CONTROL. THE STRUCTURAL PRACTICES SHALL INCLUDE AT LEAST THE FOLLOWING, UNLESS OTHERWISE APPROVED BY THE ENGINEER:

TEMPORARY:

- * SEDIMENT BARRIERS IN ACCORDANCE WITH DESIGN STANDARD 102 AND SPECIFICATION SECTION 104.
- * INLET PROTECTION IN ACCORDANCE WITH DESIGN STANDARD 102 AND SPECIAL DETAILS SHOWN IN THE TTC PLAN.
- * SEDIMENT CONTAINMENT SYSTEM: THE PERMANENT STORMWATER PONDS WILL BE TEMPORARILY MODIFIED ACCORDING TO THE DETAILS IN THE TTC PLAN.

PERMANENT:

- * STORMWATER PONDS.
- * SOD.

2.B STORMWATER MANAGEMENT:

SEVERAL STORM DRAIN SYSTEMS WILL BE CONSTRUCTED TO CONVEY RUNOFF TO THREE (3) STORMWATER RETENTION / DETENTION PONDS. THE FACILITIES HAVE BEEN PERMITTED BY THE FLORIDA DEPARTMENT OF ENVIRONMENTAL PROTECTION (FDEP) AND THE CITY OF NARCOOSSEE AND COMPLY WITH APPLICABLE DESIGN STANDARDS.

EXHIBIT SWP-2
DATE: 1/1/10

REVISIONS				STATE OF FLORIDA DEPARTMENT OF TRANSPORTATION			STORMWATER POLLUTION PREVENTION PLAN	SHEET NO.
DATE	DESCRIPTION	DATE	DESCRIPTION	ROAD NO.	COUNTY	FINANCIAL PROJECT ID		
				7	LEON	123456-1-52-01		

#USER#

#DATE#

#TIME#

#FILE#

NOTICE: THE OFFICIAL RECORD OF THIS SHEET IS THE ELECTRONIC FILE SIGNED AND SEALED UNDER RULE 68G-23.003, F.A.C.

THIS EXHIBIT IS AN EXAMPLE NARRATIVE OF A STORMWATER POLLUTION PREVENTION PLAN (SWPPP) FOR A MAJOR RECONSTRUCTION PROJECT. ACTUAL PROJECT CONDITIONS OFTEN DICTATE DIFFERENT APPROACHES THAN SHOWN HERE. THE ENGINEER IS RESPONSIBLE FOR DEVELOPING A SITE SPECIFIC SWPPP THAT COMPLIES WITH VOLUME I CHAPTER 11 OF THE PLANS PREPARATION MANUAL.

2.C OTHER CONTROLS:

2.C.1 WASTE DISPOSAL:

IN THE SEDIMENT AND EROSION CONTROL PLAN, THE CONTRACTOR SHALL DESCRIBE THE PROPOSED METHODS TO PREVENT THE DISCHARGE OF SOLID MATERIALS, INCLUDING BUILDING MATERIALS, TO WATERS OF THE UNITED STATES. THE PROPOSED METHODS SHALL INCLUDE AT LEAST THE FOLLOWING, UNLESS OTHERWISE APPROVED BY THE ENGINEER:

- * PROVIDING LITTER CONTROL AND COLLECTION WITHIN THE PROJECT DURING CONSTRUCTION ACTIVITIES.
- * DISPOSING OF ALL FERTILIZER OR OTHER CHEMICAL CONTAINERS ACCORDING TO EPA'S STANDARD PRACTICES AS DETAILED BY THE MANUFACTURER.
- * DISPOSING OF SOLID MATERIALS INCLUDING BUILDING AND CONSTRUCTION MATERIALS OFF THE PROJECT SITE BUT NOT IN SURFACE WATERS, OR WETLANDS.

2.C.2 OFF-SITE VEHICLE TRACKING & DUST CONTROL:

IN THE SEDIMENT AND EROSION CONTROL PLAN, THE CONTRACTOR SHALL DESCRIBE THE PROPOSED METHODS FOR MINIMIZING OFFSITE VEHICLE TRACKING OF SEDIMENTS AND GENERATING DUST. THE PROPOSED METHODS SHALL INCLUDE AT LEAST THE FOLLOWING, UNLESS OTHERWISE APPROVED BY THE ENGINEER.

- * COVERING LOADED HAUL TRUCKS WITH TARPULINS.
- * REMOVING EXCESS DIRT FROM ROADS DAILY.
- * STABILIZING CONSTRUCTION ENTRANCES ACCORDING TO DESIGN STANDARD 106.
- * USING ROADWAY SWEEPERS DURING DUST GENERATING ACTIVITIES SUCH AS EXCAVATION AND MILLING OPERATIONS.

2.C.3 STATE AND LOCAL REGULATIONS FOR WASTE DISPOSAL, SANITARY SEWER, OR SEPTIC TANK REGULATIONS:

IN THE SECTION 104 EROSION CONTROL PLAN, THE CONTRACTOR SHALL DESCRIBE THE PROPOSED PROCEDURES TO COMPLY WITH APPLICABLE STATE AND LOCAL REGULATIONS FOR WASTE DISPOSAL, AND SANITARY SEWER OR SEPTIC SYSTEMS.

2.C.4 FERTILIZERS AND PESTICIDES:

IN THE SEDIMENT AND EROSION CONTROL PLAN, THE CONTRACTOR SHALL DESCRIBE THE PROCEDURES FOR APPLYING FERTILIZERS AND PESTICIDES. THE PROPOSED PROCEDURES SHALL COMPLY WITH APPLICABLE SUBSECTIONS OF SECTION 570 OF THE SPECIFICATIONS.

2.C.5 TOXIC SUBSTANCES:

IN THE SEDIMENT AND EROSION CONTROL PLAN, THE CONTRACTOR SHALL PROVIDE A LIST OF TOXIC SUBSTANCES THAT ARE LIKELY TO BE USED ON THE JOB AND PROVIDE A PLAN ADDRESSING THE GENERATION, APPLICATION, MIGRATION, STORAGE, AND DISPOSAL OF THESE SUBSTANCES.

2.D.4 APPROVED STATE AND LOCAL PLANS AND PERMITS:

- * FDEP RULE CHAPTER 62-25 F.A.C.
- * CITY OF NARCOOSSEE ENVIRONMENTAL MANAGEMENT ORDINANCE NUMBER 90-0-0044AA.

3.0 MAINTENANCE:

IN THE SEDIMENT AND EROSION CONTROL PLAN, THE CONTRACTOR SHALL PROVIDE A PLAN FOR MAINTAINING ALL EROSION AND SEDIMENT CONTROLS THROUGHOUT CONSTRUCTION. THE MAINTENANCE PLAN SHALL AT A MINIMUM, COMPLY WITH THE FOLLOWING:

- * SILT FENCE: MAINTAIN PER SECTION 104. THE CONTRACTOR SHOULD ANTICIPATE REPLACING SILT FENCE ON 12 MONTH INTERVALS.
- * SEDIMENT BARRIERS : REMOVE SEDIMENT AS PER MANUFACTURER'S RECOMMENDATIONS OR WHEN WATER PONDS IN UNACCEPTABLE AMOUNTS OR AREAS.
- * PONDS ONE AND TWO: THE PONDS ARE TEMPORARY SEDIMENT BASINS UNTIL THE AREAS THAT DRAIN TO THEM ARE STABILIZED, SO UNTIL THEN, REMOVE SEDIMENT FROM THE POND WHEN IT BECOMES 1.5' DEEP AT ANY POINT.

4.0 INSPECTIONS:

QUALIFIED PERSONNEL SHALL INSPECT THE FOLLOWING ITEMS AT LEAST ONCE EVERY SEVEN CALENDAR DAYS AND WITHIN 24 HOURS OF THE END OF A STORM THAT IS 0.50 INCHES OR GREATER. TO COMPLY, THE CONTRACTOR SHALL INSTALL AND MAINTAIN RAIN GAUGES AND RECORD THE DAILY RAINFALL. WHERE SITES HAVE BEEN PERMANENTLY STABILIZED, INSPECTIONS SHALL BE CONDUCTED AT LEAST ONCE EVERY MONTH. THE CONTRACTOR SHALL ALSO INSPECT THAT CONTROLS INSTALLED IN THE FIELD AGREE WITH THE LATEST STORMWATER POLLUTION PREVENTION PLAN.

- * POINTS OF DISCHARGE TO WATERS OF THE UNITED STATES.
- * POINTS OF DISCHARGE TO MUNICIPAL SEPARATE STORM DRAIN SYSTEMS.
- * DISTURBED AREAS OF THE SITE THAT HAVE NOT BEEN FINALLY STABILIZED.
- * AREAS USED FOR STORAGE OF MATERIALS THAT ARE EXPOSED TO PRECIPITATION.
- * STRUCTURAL CONTROLS.
- * STORMWATER MANAGEMENT SYSTEMS.
- * LOCATIONS WHERE VEHICLES ENTER OR EXIT THE SITE.

THE CONTRACTOR SHALL INITIATE REPAIRS WITHIN 24 HOURS OF INSPECTIONS THAT INDICATE ITEMS ARE NOT IN GOOD WORKING ORDER.

IF INSPECTIONS INDICATE THAT THE INSTALLED STABILIZATION AND STRUCTURAL PRACTICES ARE NOT SUFFICIENT TO MINIMIZE EROSION, RETAIN SEDIMENT, AND PREVENT DISCHARGING POLLUTANTS, THE CONTRACTOR SHALL PROVIDE ADDITIONAL MEASURES, AS APPROVED BY THE ENGINEER.

5.0 NON-STORMWATER DISCHARGES:

IN THE SECTION 104 EROSION CONTROL PLAN, THE CONTRACTOR SHALL IDENTIFY ALL ANTICIPATED NON-STORMWATER DISCHARGES (EXCEPT FLOWS FROM FIRE FIGHTING ACTIVITIES). THE CONTRACTOR SHALL DESCRIBE THE PROPOSED MEASURES TO PREVENT POLLUTION OF THESE NON-STORMWATER DISCHARGES. IF THE CONTRACTOR ENCOUNTERS CONTAMINATED SOIL OR GROUNDWATER, CONTACT DAVE LETTERMAN, DISTRICT HAZARDOUS MATERIALS COORDINATOR AT (305) 63B-R549.

EXHIBIT SWP-3
DATE: 1/1/10

REVISIONS				STATE OF FLORIDA DEPARTMENT OF TRANSPORTATION			STORMWATER POLLUTION PREVENTION PLAN	SHEET NO.
DATE	DESCRIPTION	DATE	DESCRIPTION	ROAD NO.	COUNTY	FINANCIAL PROJECT ID		
				7	LEON	123456-1-52-01		

#USER# #DATE# #TIME# #FILE#

NOTICE: THE OFFICIAL RECORD OF THIS SHEET IS THE ELECTRONIC FILE SIGNED AND SEALED UNDER RULE 68G5-23.003, F.A.C.

